


Rev	Date	Amendments	By	Check
P01	03/03/2022	TENDER ISSUE	AW	JW

- NOTES:
- THIS DRAWING SHALL BE READ IN CONJUNCTION WITH THE PROJECT SPECIFICATION AND ALL OTHER CONTRACT DOCUMENTATION.
  - DESIGN TO BE UNDERTAKEN IN ACCORDANCE WITH THE PERFORMANCE SPECIFICATION, ROOM DATA SHEETS & ALL APPLICABLE GUIDES & STANDARDS.
  - THIS DRAWING IS PREPARED TO DEMONSTRATE A PRELIMINARY PROPOSAL FOR THE PURPOSES OF PLANNING AND TENDER. THE LIGHTING SCHEME HAS BEEN PREPARED WITH CONSIDERATION OF APPROPRIATE BRITISH STANDARDS (I.E. BS EN 12464) AS WELL AS OTHER GOOD PRACTICE GUIDANCE INCLUDING CIBSE LG6 AND ILP GUIDANCE NOTES FOR THE REDUCTION OF OBTRUSIVE LIGHT GNO1.
  - THE FINAL LIGHTING SCHEME SHALL BE SUBJECT TO DETAILED DESIGN AS THE PROJECT PROGRESSES, AND SHALL TAKE INTO ACCOUNT THE FINAL BUILDING FORM, LANDSCAPE DESIGN, PLANNING RECOMMENDATIONS, ETC. ANY DEVELOPMENT OF THE DESIGN WILL BE WITHIN THE PARAMETERS INDICATED ON THIS DRAWING.
  - CONTROL OF EXTERNAL LIGHTING IS PROPOSED AS PHOTOCCELL CONTROL WITH TIMECLOCK OVERRIDE. THE TIMECLOCK SHALL BE SET TO SWITCH LIGHTING OFF BETWEEN THE HOURS OF 23.00 AND 06.00 IN ACCORDANCE WITH THE ILP GUIDANCE NOTES FOR THE REDUCTION OF OBTRUSIVE LIGHT GNO1 UNLESS OTHERWISE STIPULATED BY THE PLANNING AUTHORITY. A MANUAL KEYSWITCH SHALL BE PROVIDED AT THE MAIN ENTRANCE TO OVERRIDE THE TIMECLOCK IF REQUIRED, WITH THE FOLLOWING SETTINGS:
    - AUTOMATIC OPERATION (NORMAL)
    - MANUAL OVERRIDE OF ALL EXTERNAL LIGHTING, ONLY TO BE USED IN EMERGENCY SITUATIONS
  - CONTRACTOR TO MAKE ALLOWANCE FOR EMERGENCY BULKHEAD FITTINGS ABOVE ALL EMERGENCY EXITS.



LUMINAIRE SCHEDULE:

Code	Description	Symbol name	Symbol
0049003 0049033	START SURFACE IP66 1500LM 840 IK10 BLK	EX1	EX1
0049011 0049033	START SURFACE IP66 1500LM 840 EM3 IK10 BLK + EYELID	EX1E	EX1E
0049003	START SURFACE IP66 1500LM 840 IK10 BLK	EX2	EX2
0047943	START BOLLARD L IP65 1100LM 840 BLK	EX3	EX3
0066618	SKYLINE STREET S 1-5KLM NW MR22 I 9022 3000LM VARIANT	EX4	EX4
0041769	SYLSAFE TWIN TS C EM3 NM MS	EM	EM

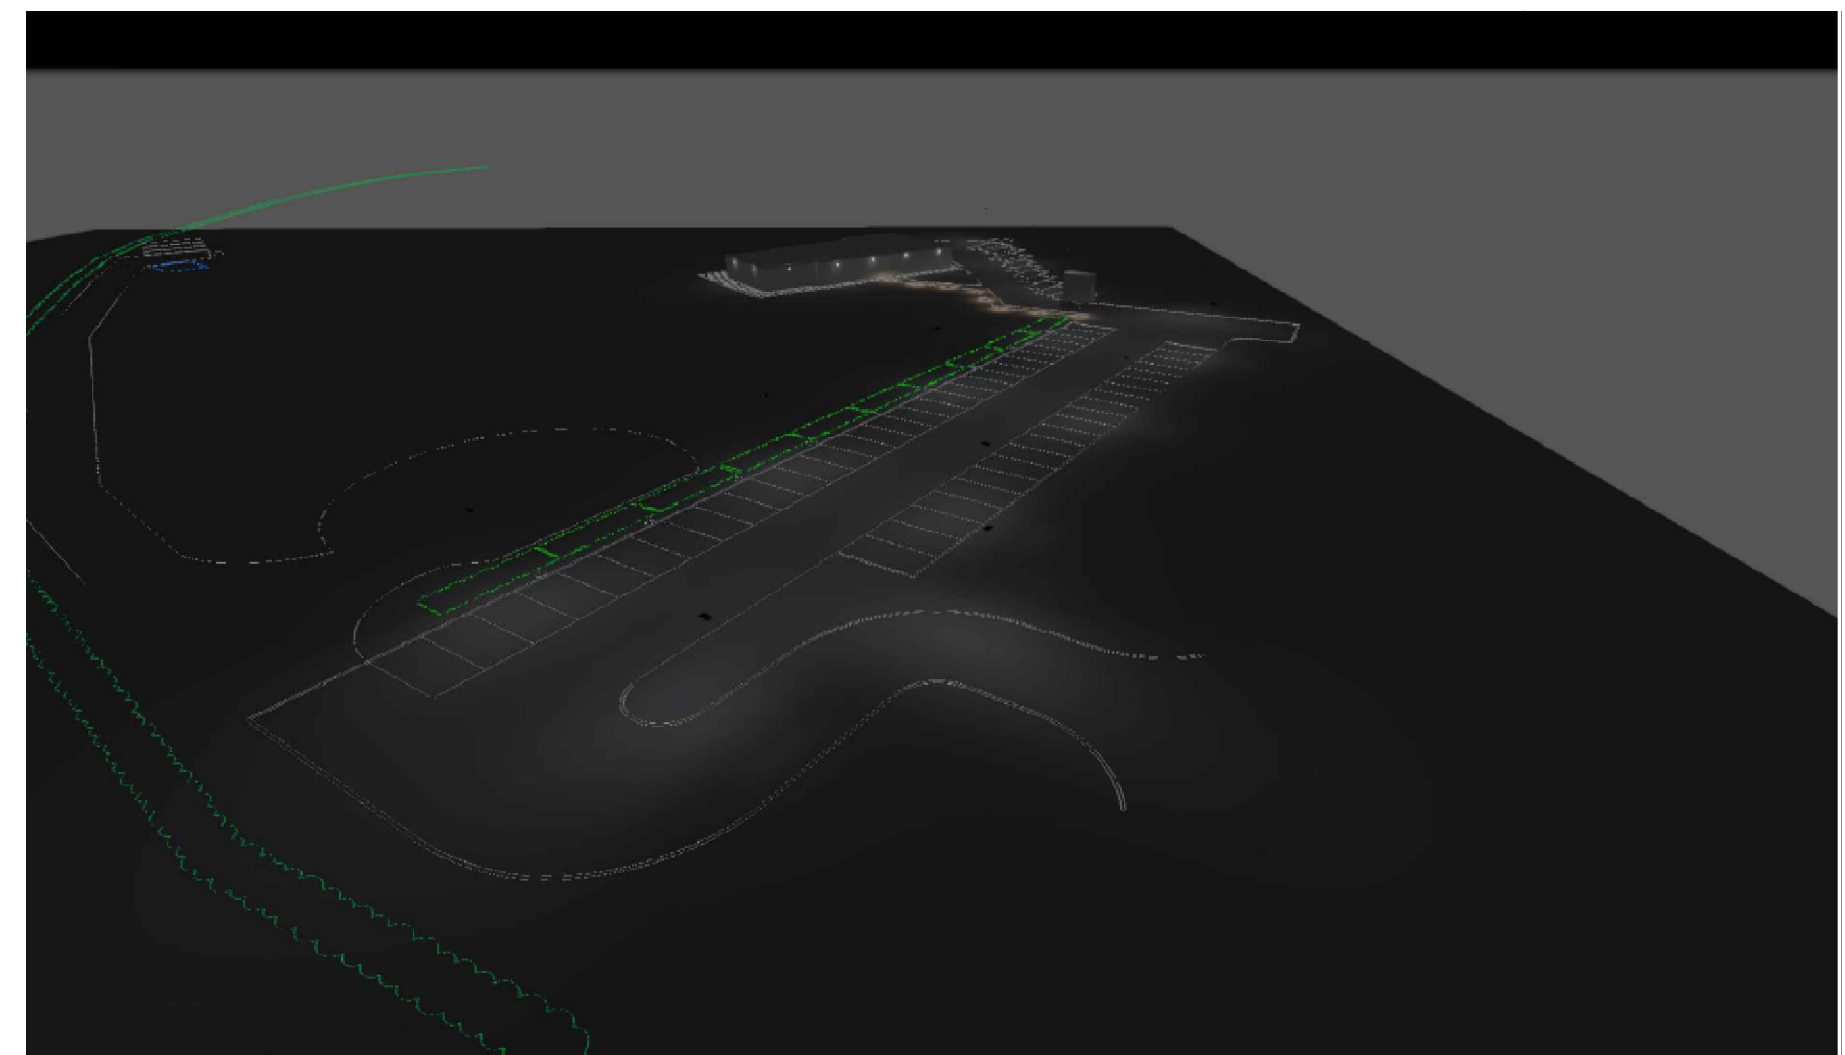

Client  
WENDOVER CRICKET CLUB

Project  
NEW PAVILION

Title  
EXTERNAL LIGHTING LAYOUT

Drawing Type  
DESIGN INTENT

Drawing No. 1438-E-100  
Revision P01

Scale 1:300  
Original Size A1  
Date 03/03/2022

Drawn JR  
Engineer JR  
Checked JW

DESIGN INTENT

