

KEY:

ESP NIGHTHAWK LED FLOODLIGHT WITH PIR SENSOR
 Colour: Black
 Wall mounted LED PIR Security floodlight
 Nichia LEDs
 Integrated PIR movement sensor 160degree range
 On/ off over-ride
 Size: H290 x W180 x D140mm



FORUM LEDA WALL MOUNTED ADJUSTABLE PIR SENSOR
 Colour: Black
 IP54, Class I
 Max 60W Decorative Filament
 Aluminium
 Mains Voltage
 Size: H215 x W115 x D175mm



FARO BARCELONA BAST LED OUTDOOR POST LIGHT
 Colour: Dark Grey
 Clear polycarbonate diffuser
 Aluminium
 IP65
 Mains voltage
 25W, White light output
 Size: H960 x W160 x D160mm

 



INTEGRAL ULTRA SLIM 6.5W WARM WHITE DIMMABLE LED TILTABLE
 Colour: Black
 6.5W alloy adjustable downlight
 Warm white (3000K) light colour
 IP40 rated
 Maximum 25 degree tilt
 Size: D25 x Dia 83mm Cut out 65mm.



NOTES:
 Do Not Scale.
 Report all discrepancies, errors and omissions.
 Verify all dimensions on site before commencing any work on site or preparing shop drawings.
 All materials, components and workmanship are to comply with the relevant British Standards, Codes of Practice, and appropriate manufacturers recommendations that from time to time shall apply.
 For all specialist work, see relevant drawings.
 This drawing and design are copyright of BWW Architects.

Rev	Date	Description

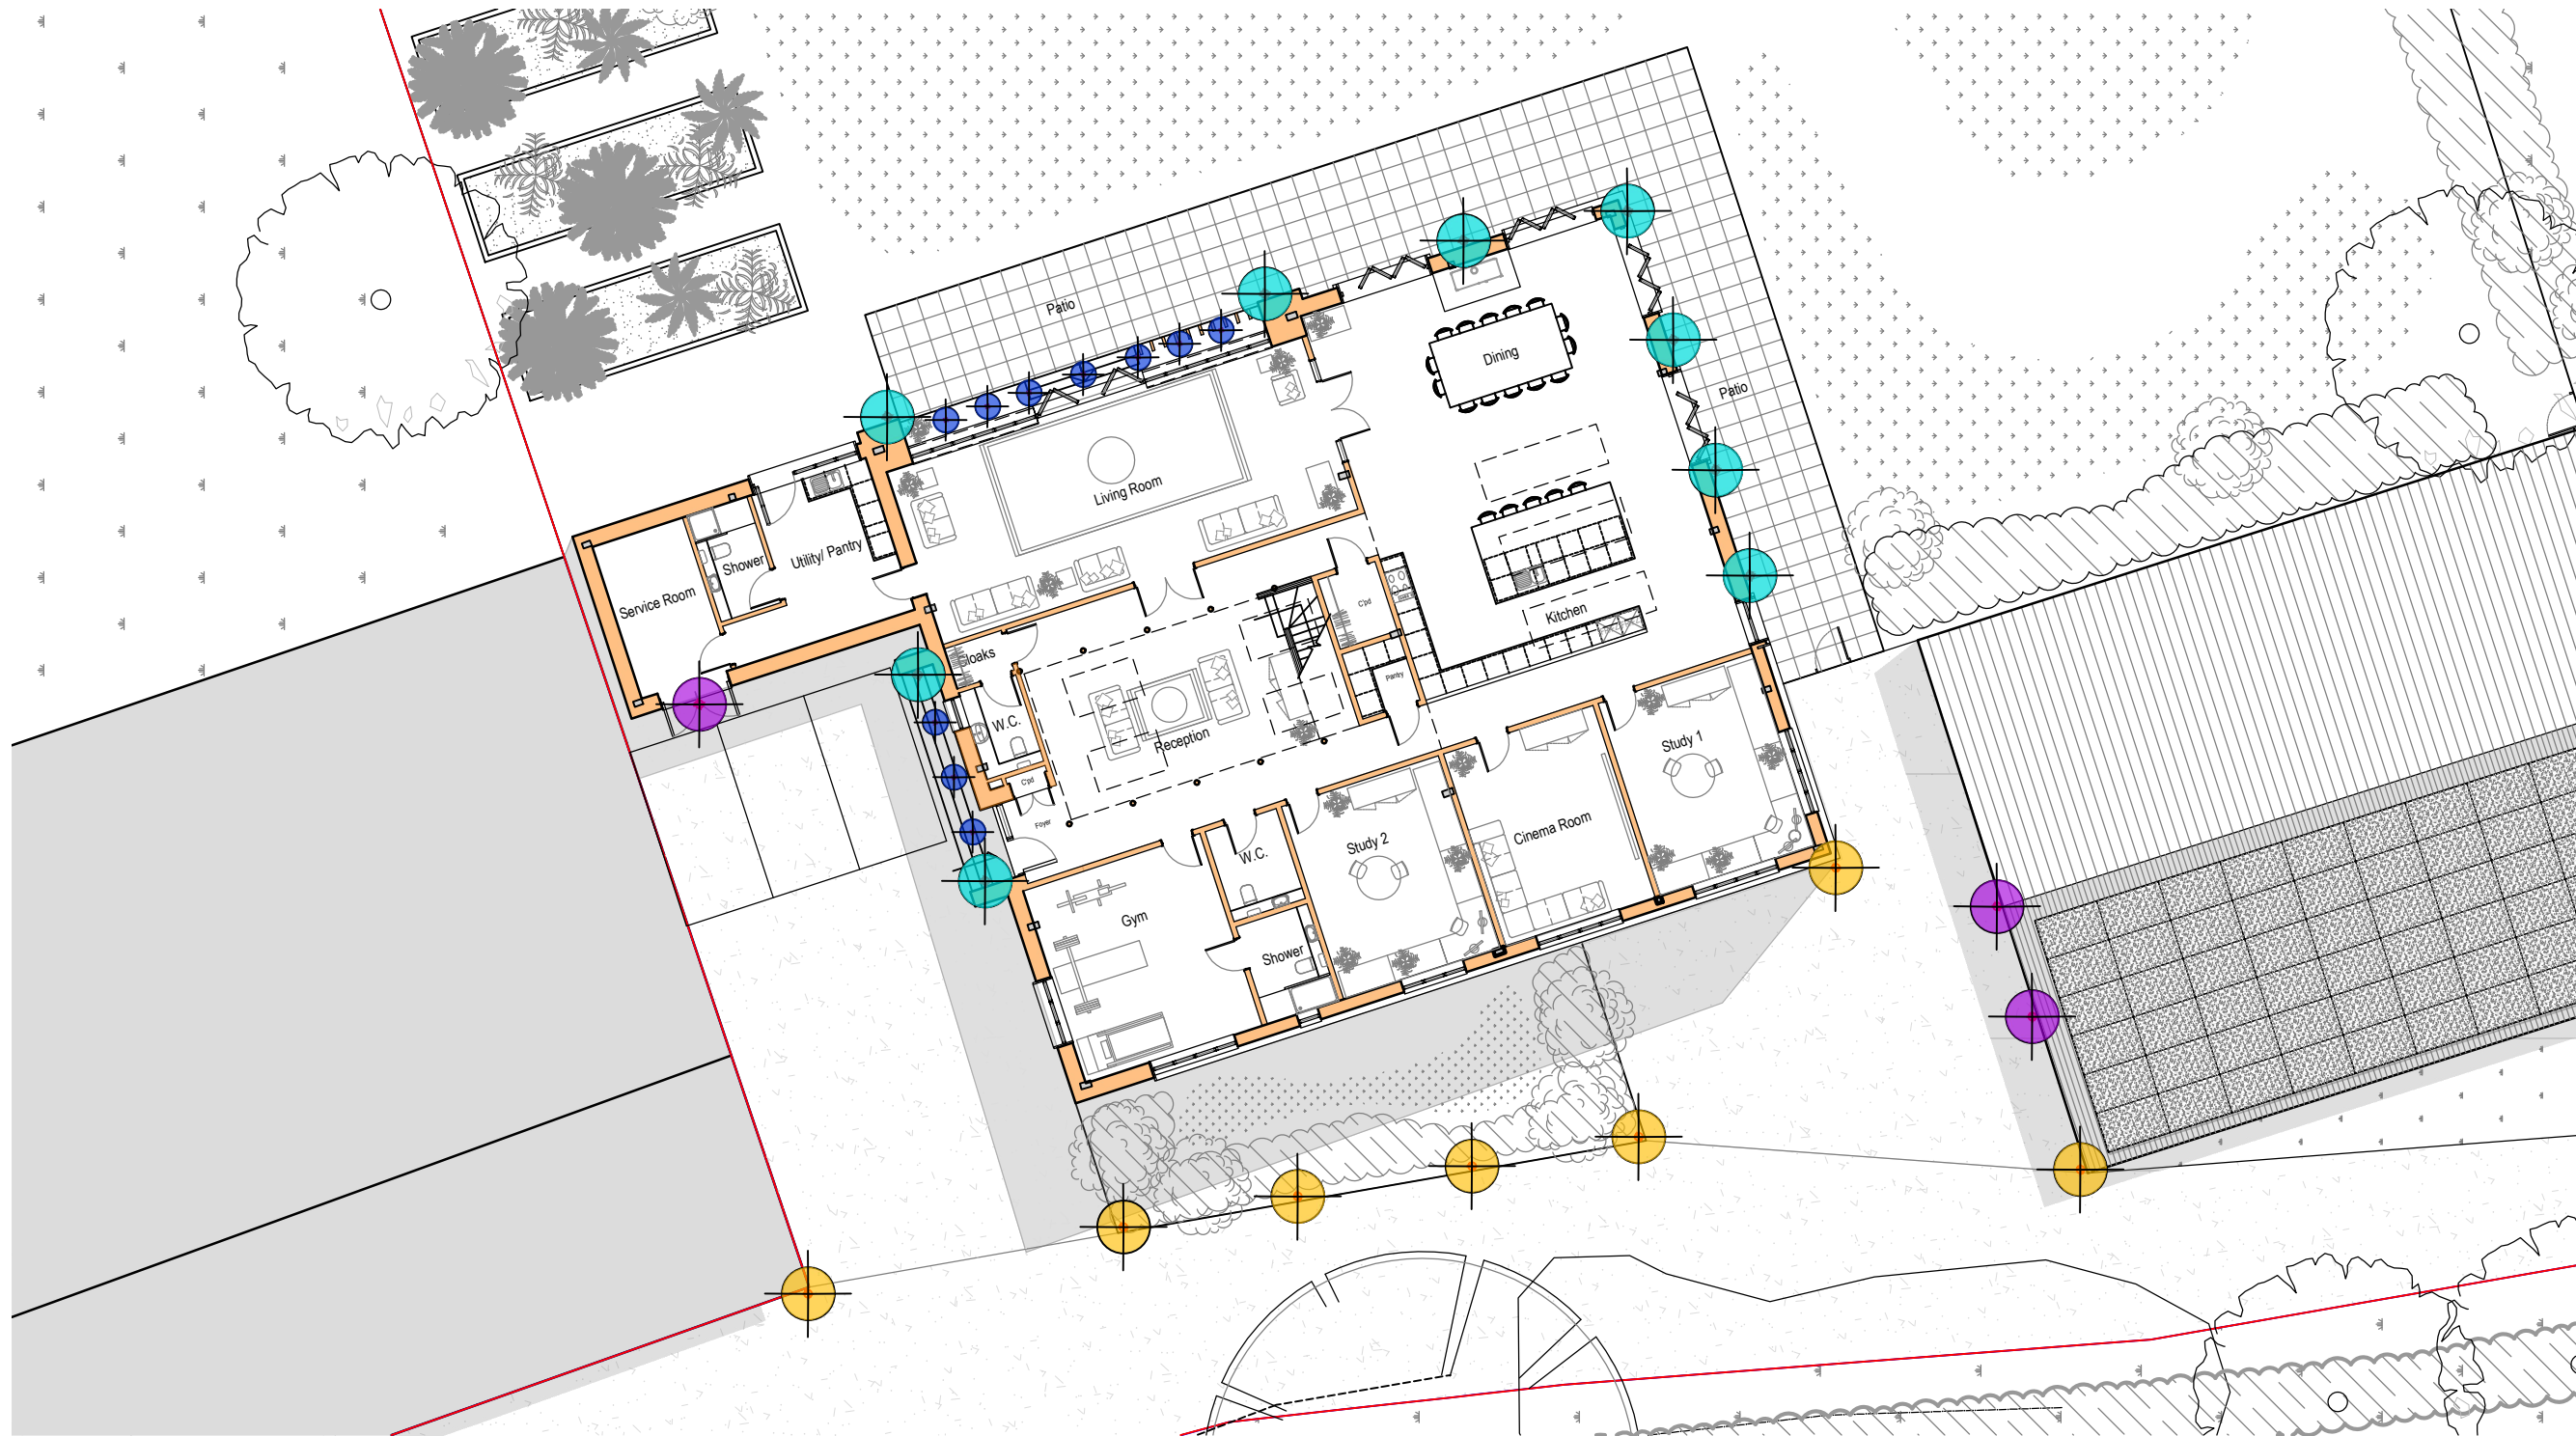

5 10
 Scale 1:200

PLANNING

Project Title
**Proposed Barn Conversion at
 Minnis Farm
 Worth
 Deal
 Kent
 CT14 0DQ**

Drawing Description
**Proposed Site Plan
 Proposed Lighting Plan**

Scale
 1:200@ A3
 Date
 June 2023

Drawn by
 BW
 Checked by
 BW



92, Old Dover Road, Canterbury, Kent 07787763656

LIGHT - COLOUR - SCALE - TEXTURE

Drawing Number Revision

0029C_07 -