



Osprey Charging Network Ltd
 3rd Floor, Martin House
 5 Martin Lane, London, EC4R 0DP

Plan 1

SITE:
 Maidenhead Aquatics - Basingstoke - RG25 2DJ

PROJECT:
 Maidenhead Aquatics

DATE:
 10/08/23

TITLE:
 Site Plan Proposed

SCALE AT A4:
 1:500

DRAWN:
 TL

 





REVISION:
 V1


AMENDMENTS:

REV:	DESCRIPTION:	BY:	DATE:
V1	Initial Draft	TL	10/08/23



Key

-  Development Site
-  Feeder Pillar
-  Power Unit
-  EV Chargepoint
-  Substation
-  Bollard

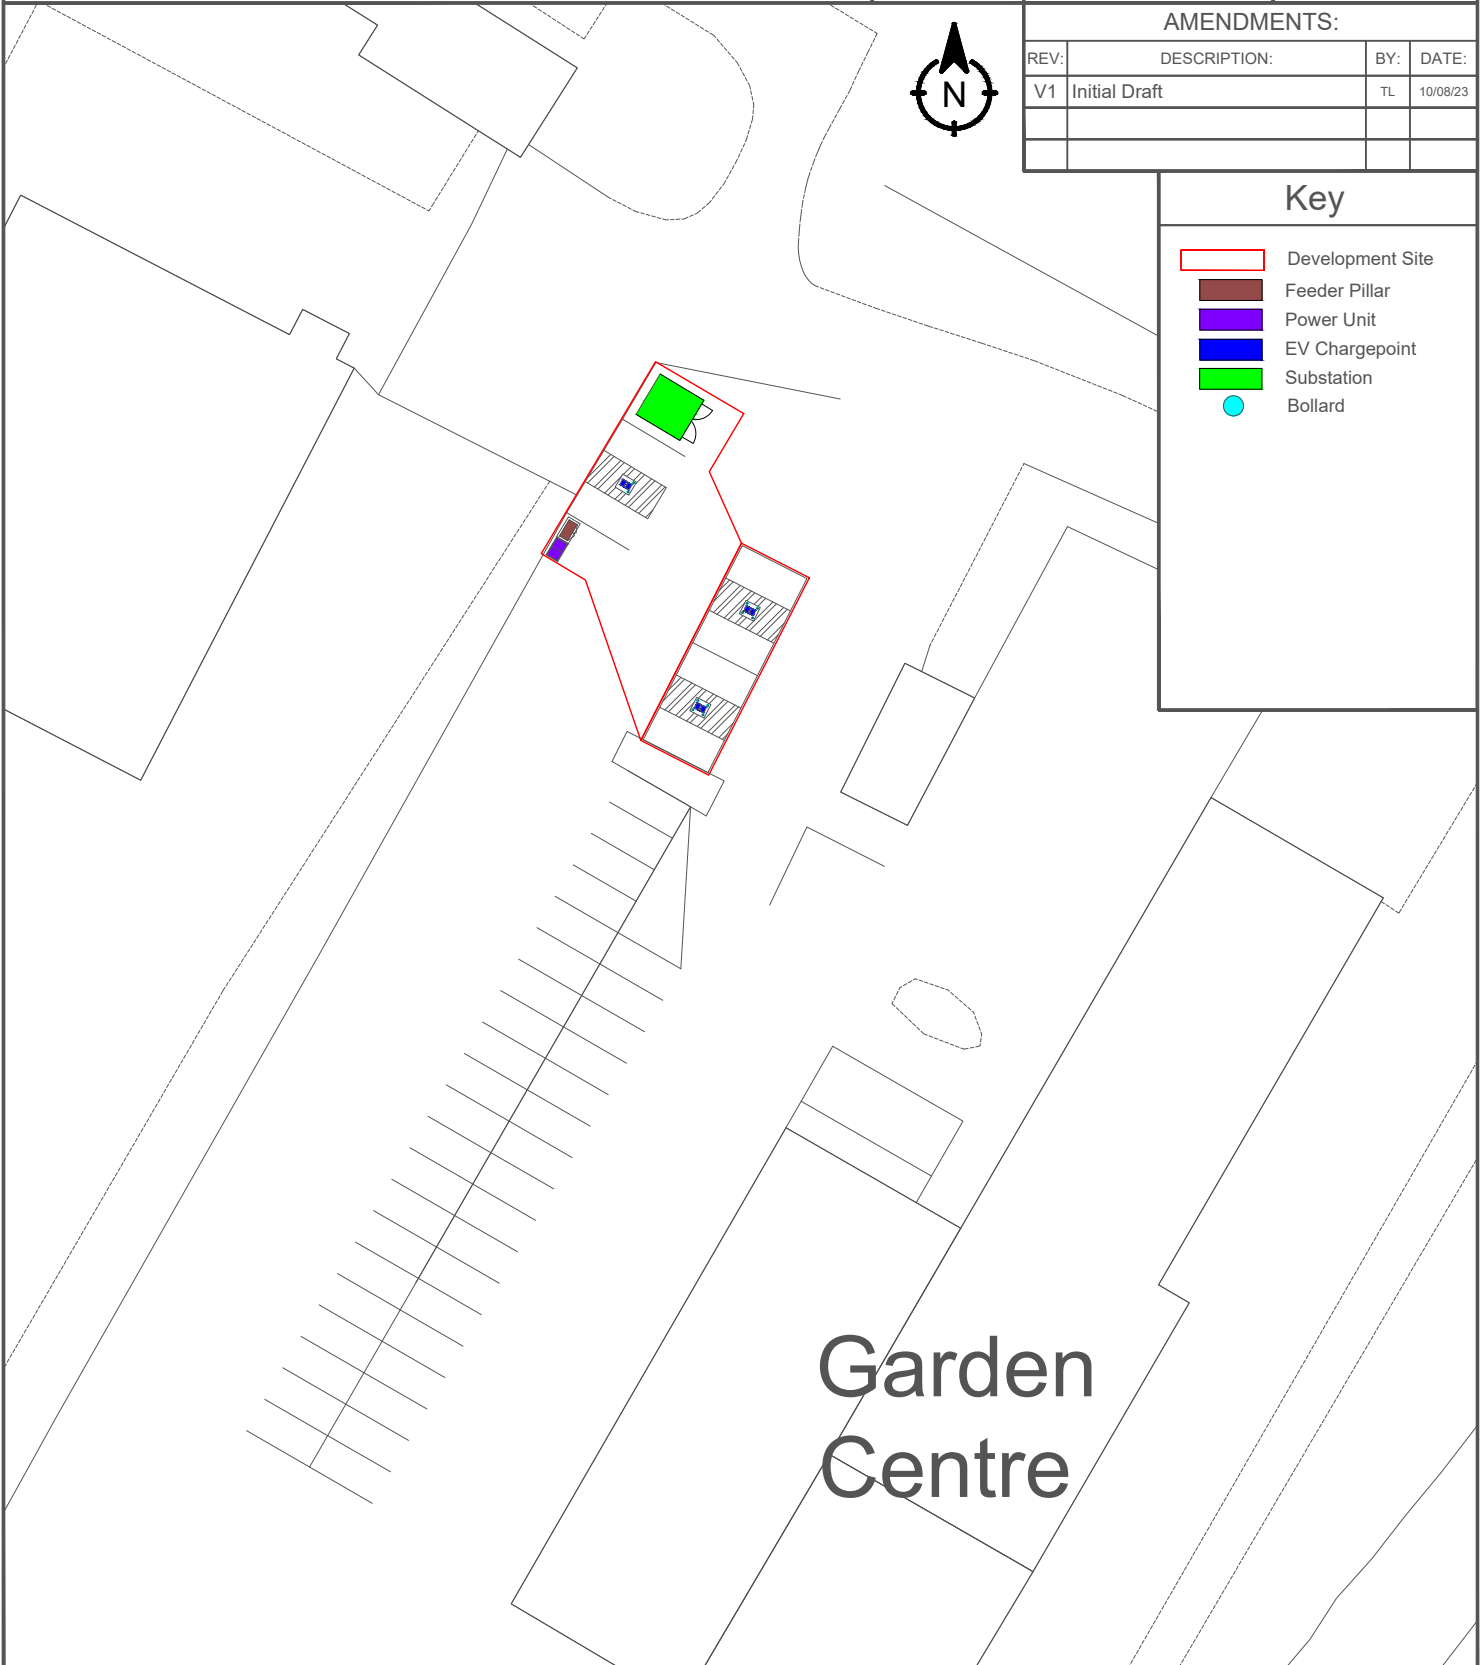

Garden Centre

1:500

