



Osprey Charging Network Ltd

3rd Floor, Martin House
5 Martin Lane, London, EC4R 0DP

Plan 2

SITE: Maidenhead Aquatics - Basingstoke - RG25 2DJ

PROJECT: Maidenhead Aquatics

DATE: 10/08/23

TITLE: Site Plan Existing

SCALE AT A4: 1:500

DRAWN: TL

 





REVISION: V1


AMENDMENTS:

REV:	DESCRIPTION:	BY:	DATE:
V1	Initial Draft	TL	10/08/23



Key

-  Development Site
-  Feeder Pillar
-  Power Unit
-  EV Chargepoint
-  Substation
-  Bollard

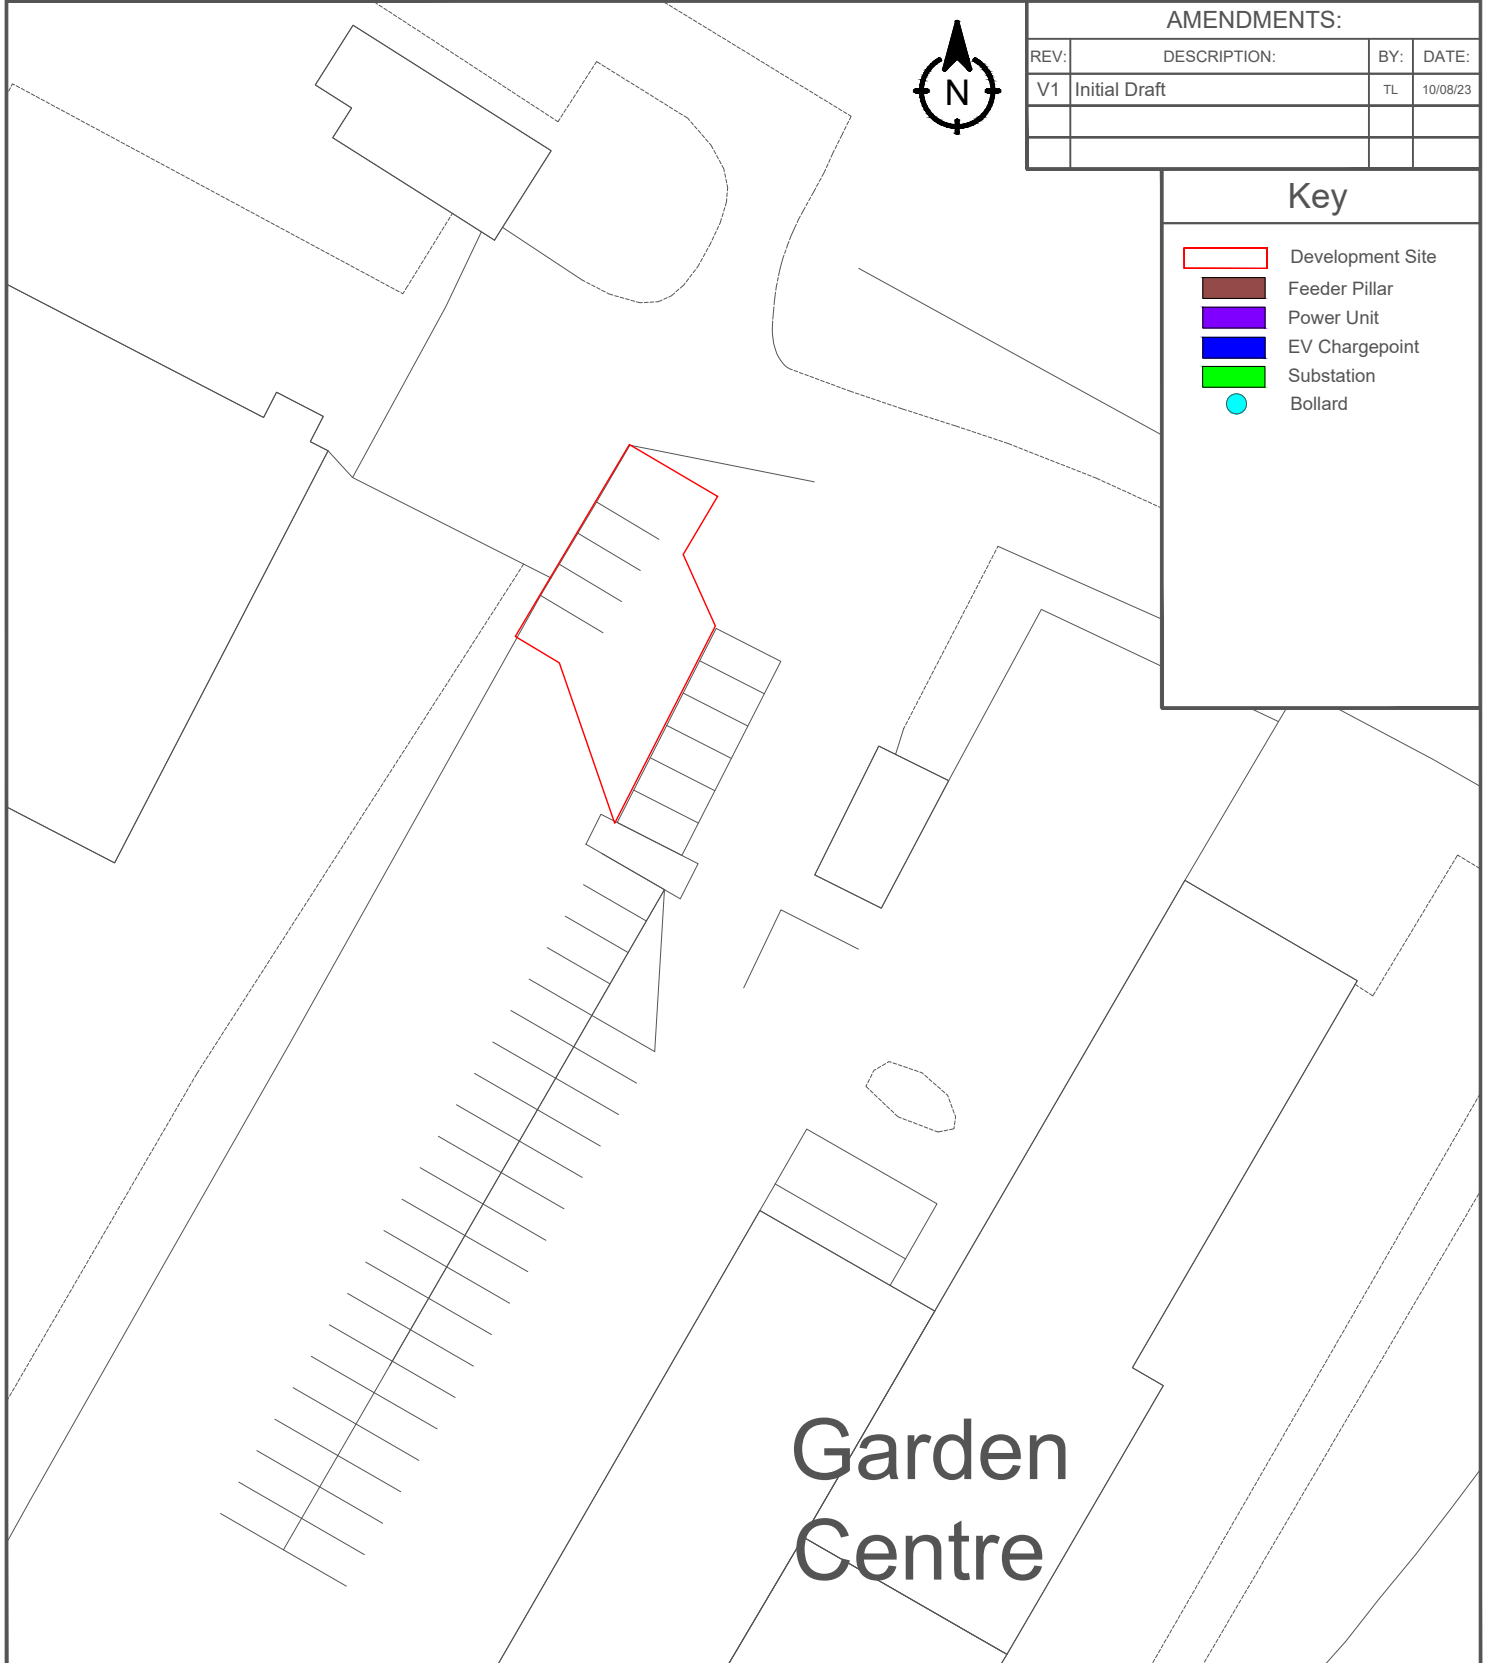

1:500

