



Do not scale from this drawing.

**SAFETY HEALTH AND ENVIRONMENTAL INFORMATION**

IN ADDITION TO THE HAZARD/RISKS NORMALLY ASSOCIATED WITH THE TYPES OF WORK DETAILED ON THIS DRAWING, NOTE THE FOLLOWING RISKS AND INFORMATION:


RISKS LISTED HERE ARE NOT EXHAUSTIVE. REFER TO DESIGN ASSESSMENT FORM NO.

CONSTRUCTION

DEMOLITION

FOR INFORMATION RELATING TO USE, CLEANING AND MAINTENANCE SEE THE HEALTH AND SAFETY FILE

IT IS ASSUMED THAT ALL WORKS WILL BE CARRIED OUT BY A COMPETENT CONTRACTOR WORKING, WHERE APPROPRIATE, TO AN APPROVED METHOD STATEMENT.

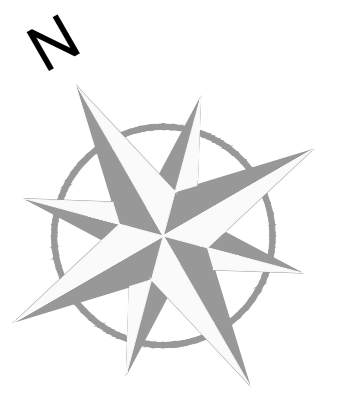


- Notes**
- THIS DRAWING IS TO BE READ IN CONJUNCTION WITH ALL OTHER FAIRHURST DRAWINGS AND SPECIFICATIONS FOR THIS PROJECT & THE TOPOGRAPHICAL SURVEY BY GREENMATCH REF 38138\_T\_REV10.
  - CONTRACTOR IS TO CHECK AND CONFIRM ALL DIMENSIONS ON SITE PRIOR TO COMMENCING WORKS
  - ANY DISCREPANCIES BETWEEN THE ENGINEERS DRAWINGS AND SITE CONDITIONS TO BE REPORTED TO THE ENGINEER IMMEDIATELY AND INSTRUCTIONS RECEIVED BEFORE PROCEEDING
  - ORIGINAL TOPOGRAPHICAL SURVEY LEVELS SHOWN ON THIS DRAWINGS PRIOR TO PLATEAU UPLIFT WORKS
  - ALL ADOPTABLE FEATURES HAS BEEN DESIGNED ACCORDING TO - SSI(SURVEY SECTOR GUIDANCE) APPENDIX C - DESIGN AND CONSTRUCTION GUIDANCE AND WESSA WATER PUMPING STATION ADDENDUM.

**Legend:**

— SITE BOUNDARY CORRESPONDING WITH LAND REGISTRY PLAN

ITEMS REVISED

ISSUED IN ABEYANCE

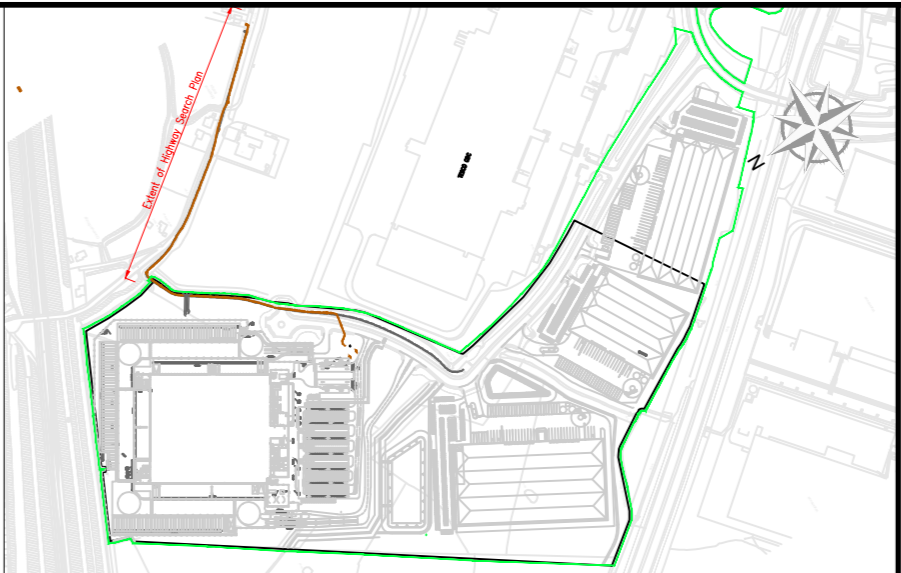

**EQUATION**

Project Title: **MATRIX 49 AVONMOUTH**

Drawing Title: **S104 - SITE LOCATION PLAN**

**FAIRHURST**

Oak House, Reads Crescent, MATCHEL, WILTSHIRE

Subsidiary: S104  
 Project Ref: 138577  
 Scale: 1:500  
 Status: Tender

Drawn: SS  
 Checked: BH  
 Date: 18.12.22

Project Ref: BRS8-FRH-XX-EX-DR-CV-2040

Revision: **P04**

Rev.	Date	Description	Drawn	Checked	Approved
P04	28/02/23	UPDATED TO INCORPORATE WW COMMENTS	DH	DT	DT
P03	18/04/23	UPDATED TO INCORPORATE WW COMMENTS	DH	DT	DT
P02	28/07/23	UPDATED ACCORDING TO WW COMMENTS	TA	DT	DT