

CORRIDOR

TPMPS OFFICE

FRONT STAIR

DOWN

GENERAL DB A - CRITICAL DB B - CW  
CW METERING & TOP EXT DB A METERING EXT

ISOL B

EB-01

NEW PRIMARY BONDING BAR

A/C 01

A/C 02

A/C 03

CAB 03

CAB 04

CAB 05

CAB 01

CAB 02

UPS A

UPS B

CONDENSER No. 1

CONDENSER No. 2

CONDENSER No. 3

DUCTWORK TO RUN CEILING VOID

GAS


A

A


# PROPOSAL

NOTE: DO NOT SCALE OFF THIS DRAWING.  
ALWAYS WORK TO NOTED DIMENSIONS

LOCATION PLAN:

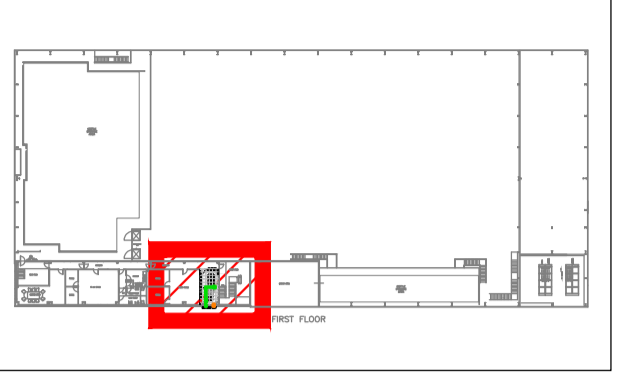

LEGEND:

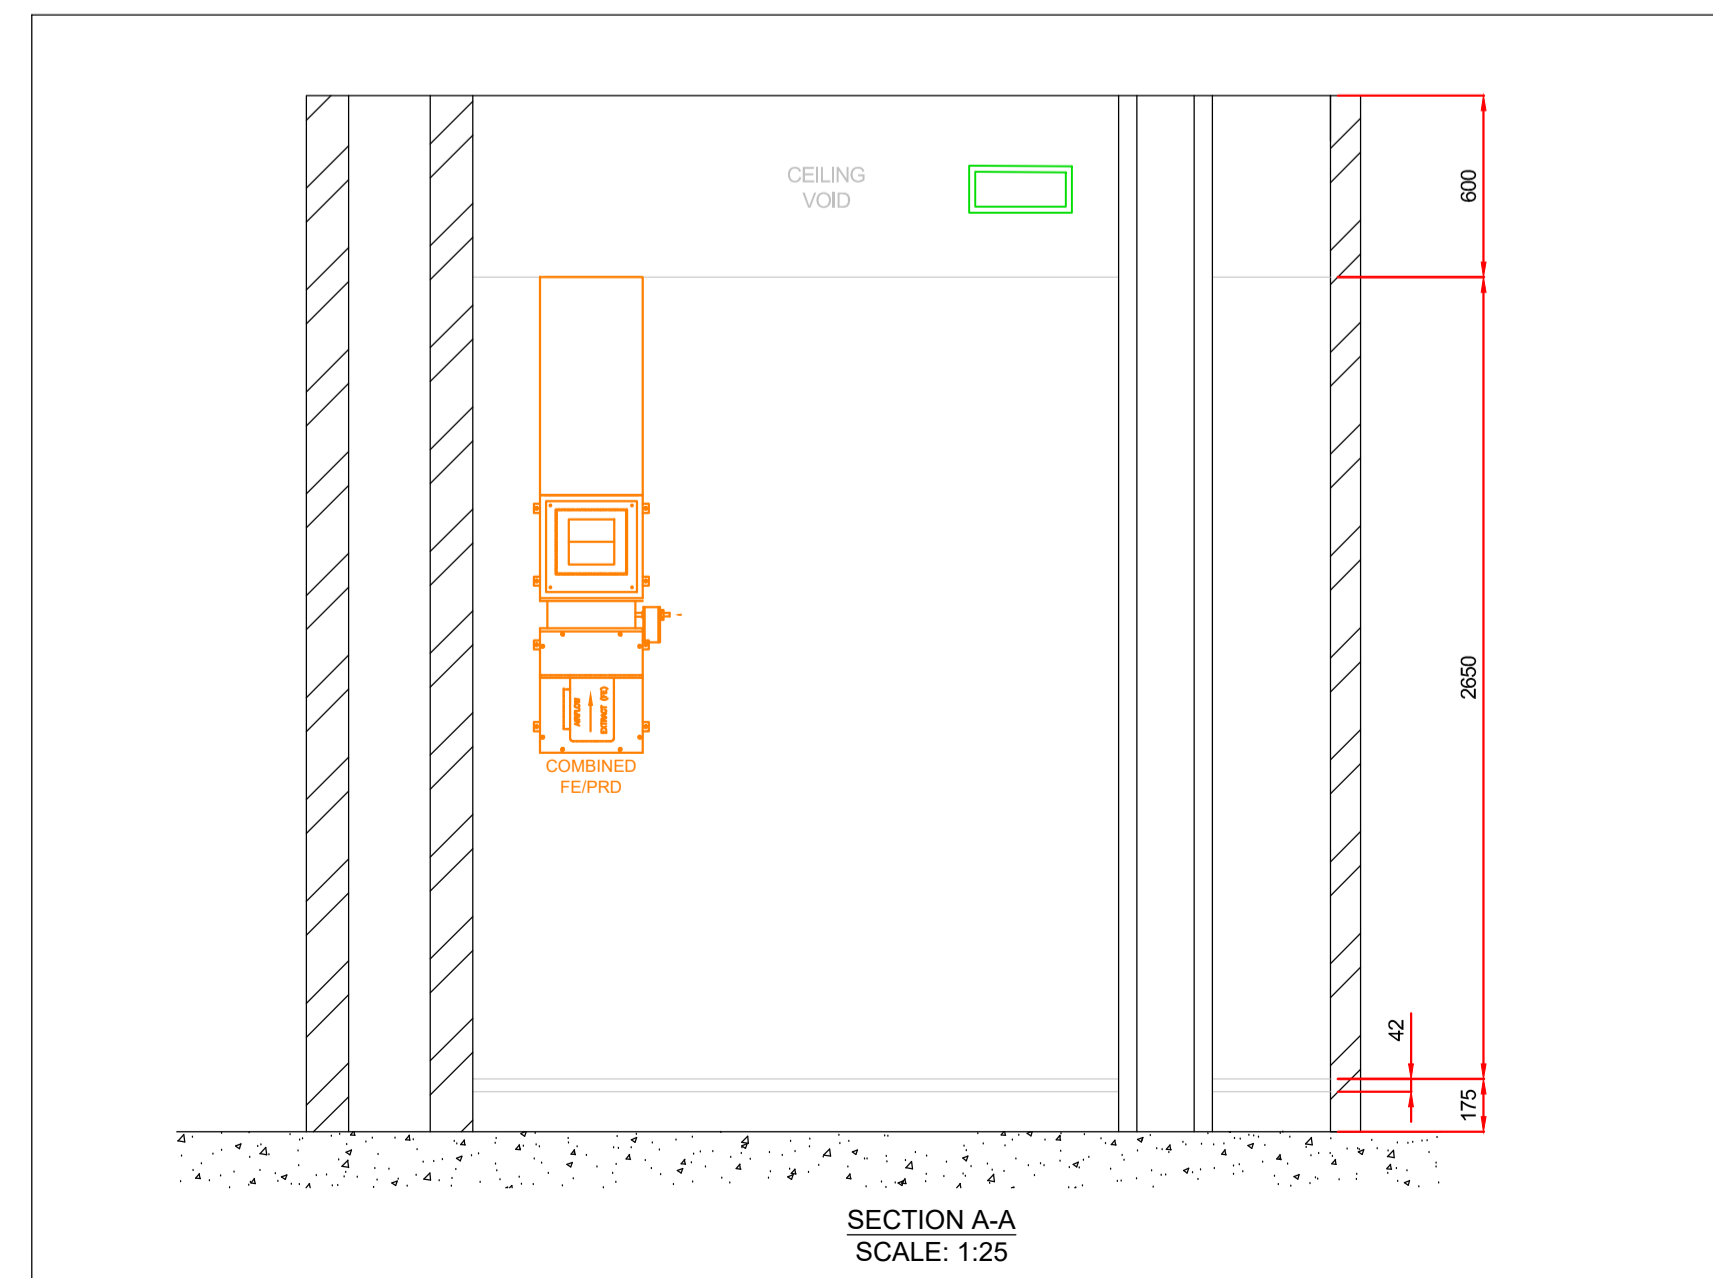

P01	PROPOSAL ISSUE	14/07/23	SE	JC
REV	DESCRIPTION	DATE	BY	CHK



SUDLOWS LIMITED  
DUCIE WORKS  
HULME HALL LANE  
MANCHESTER M40 8HH

TELEPHONE: 0800 783 5697  
FAX: 0161 205 0295  
EMAIL: CAD@SUDLOWS.COM  
WWW.SUDLOWS.COM

Client:



Site:

BELLSHILL

Status:

PROPOSAL

Scale:

1:25

Date Created:

12/07/23

Drawn By:

SE

Sheet Size:

A1

Drawing Title:

VENTILATION LAYOUT

DC2

FIRST FLOOR

Project No.:

PR85150

Suitability:

S3

Drawing No.:

SUD-XX-01-DR-M-7001

Rev:

P01