


# PROPOSAL


NOTE: DO NOT SCALE OFF THIS DRAWING.  
ALWAYS WORK TO NOTED DIMENSIONS

LOCATION PLAN:

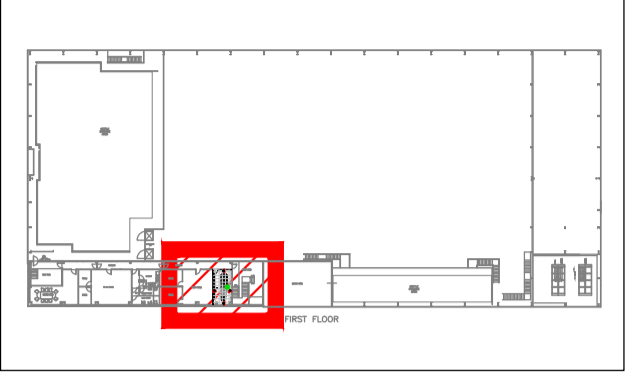

LEGEND:

- ANSELL LUMINAIRE ATOREV05
- ANSELL LUMINAIRE ATOREV05/SM3

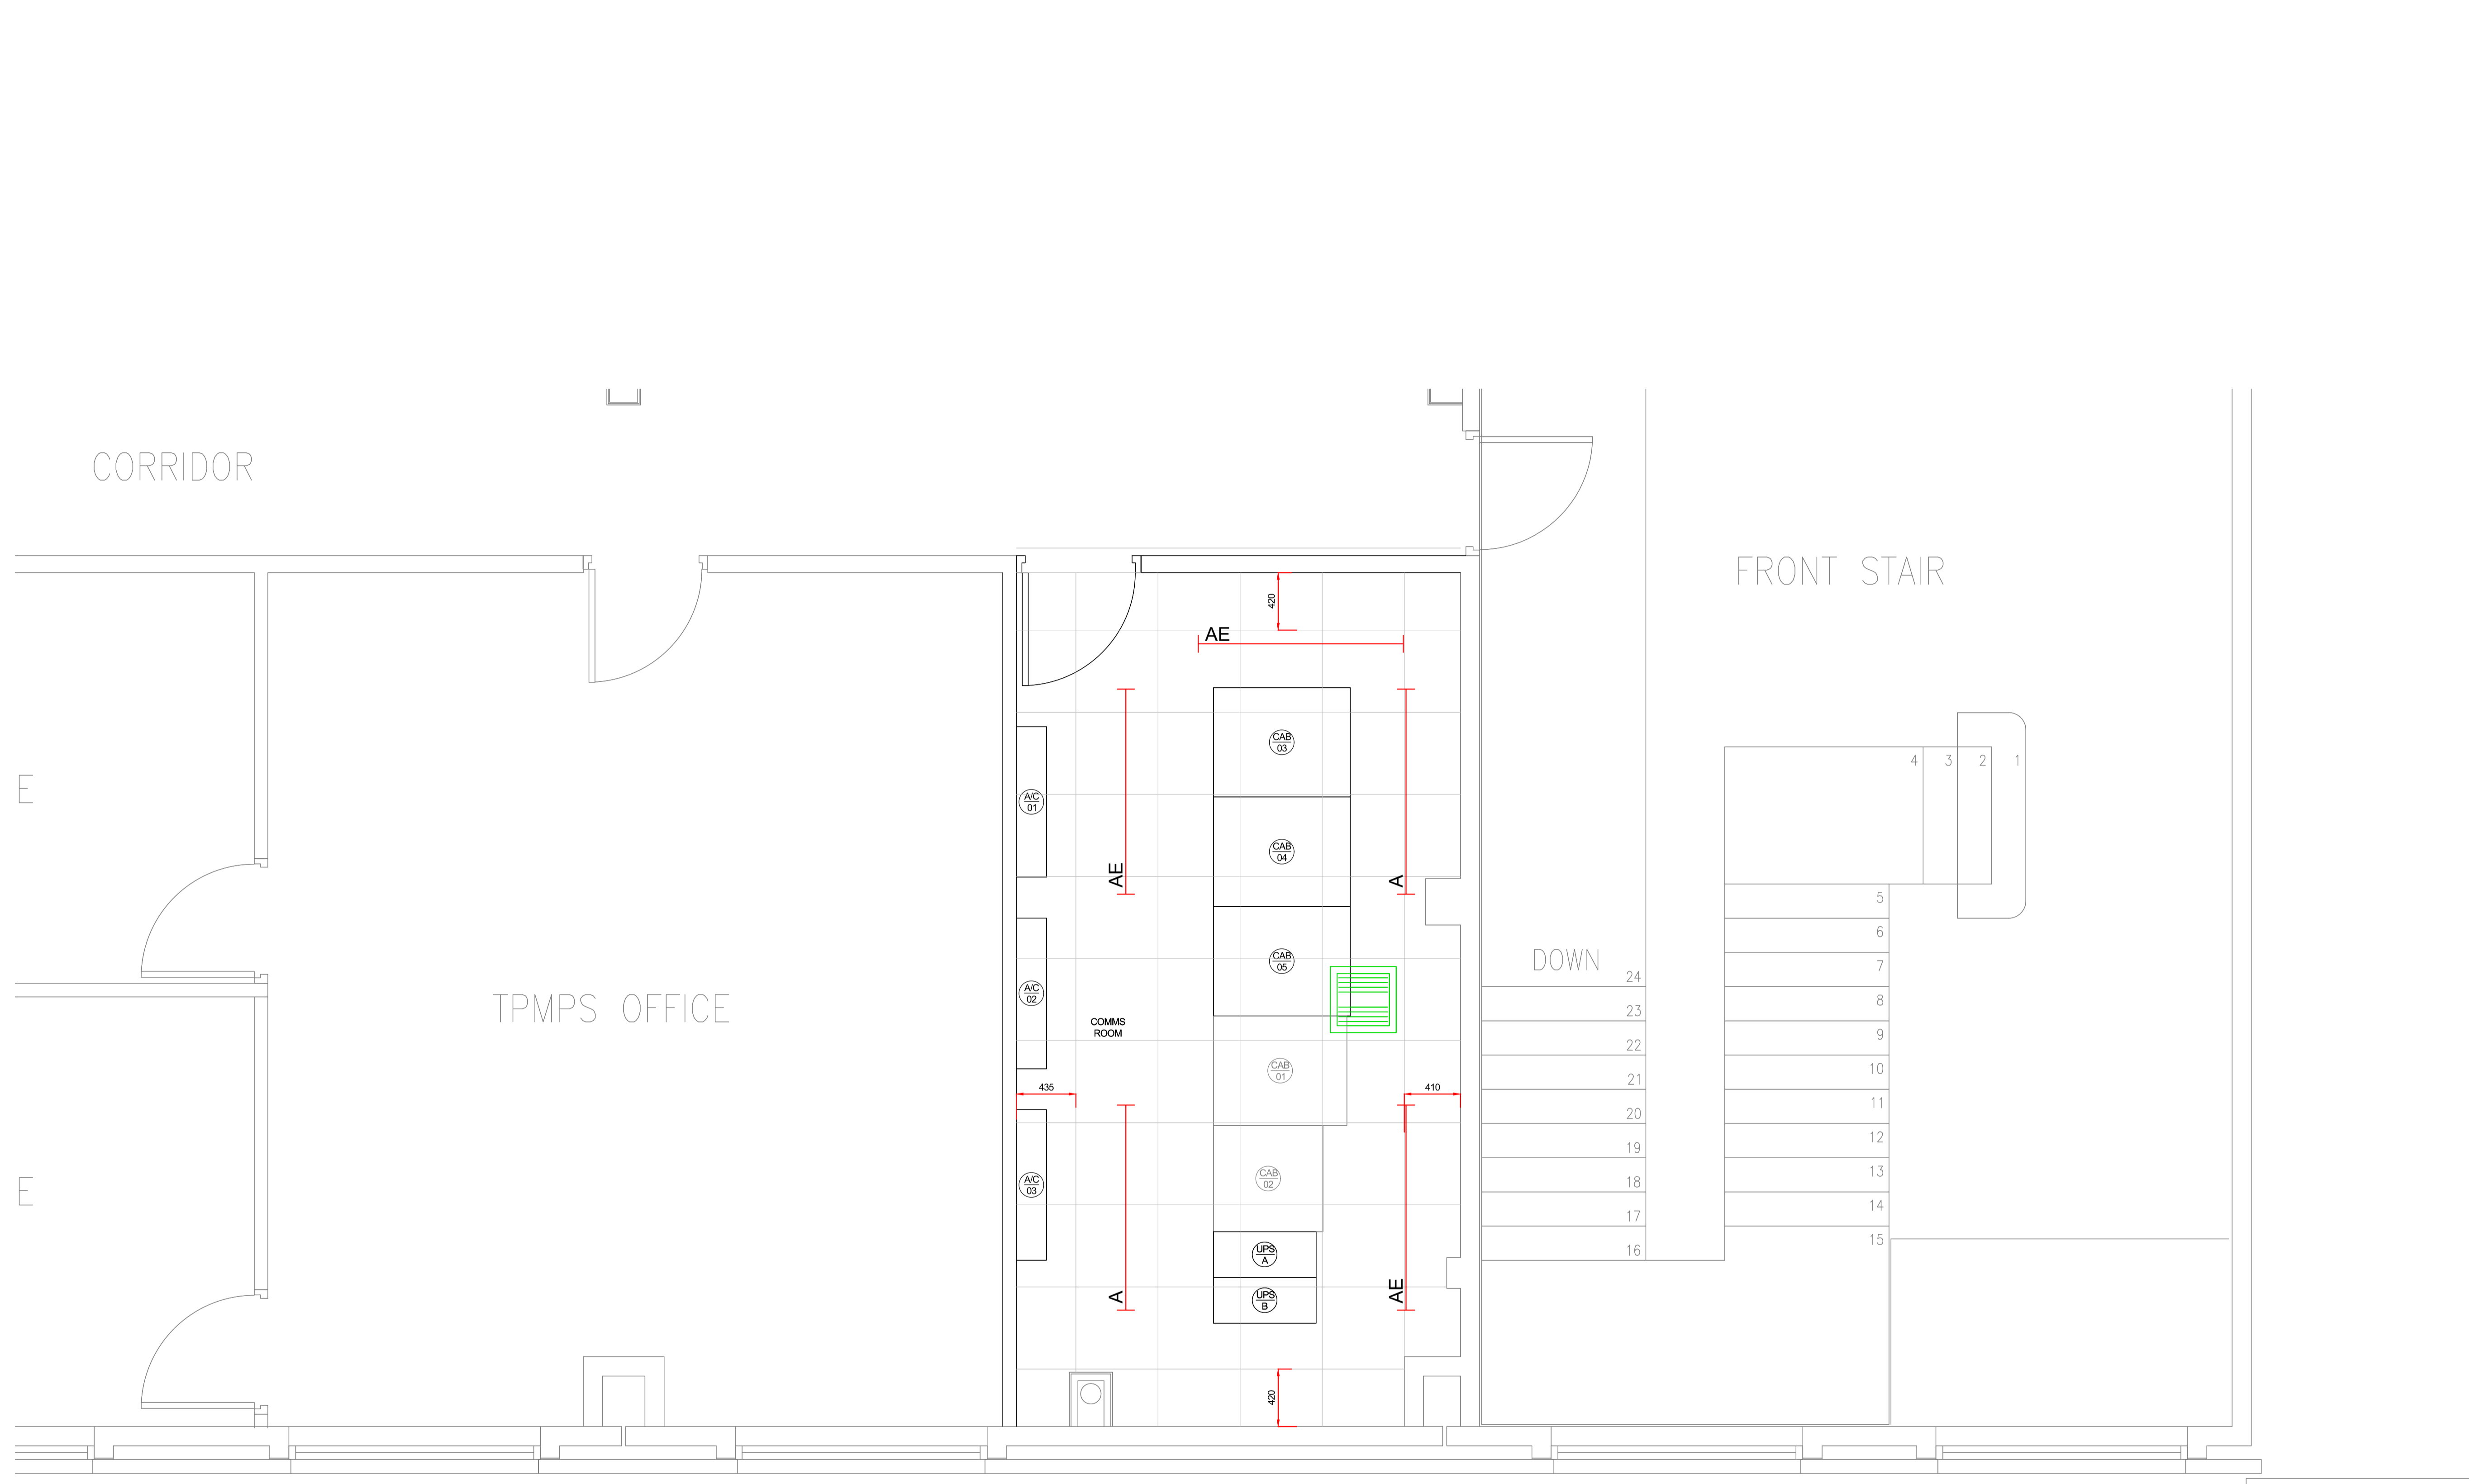

P01	PROPOSAL ISSUE	14/07/23	SE	PJ
REV	DESCRIPTION	DATE	BY	CHK



SUDLOWS LIMITED  
DUCIE WORKS  
HULME HALL LANE  
MANCHESTER M40 8HH

TELEPHONE: 0800 783 5697  
FAX: 0161 205 0295  
EMAIL: CAD@SUDLOWS.COM  
WWW.SUDLOWS.COM

Client:



Site:  
**BELLSHILL**

Status: **PROPOSAL** Scale: **1:25**

Date Created: **12/07/23** Drawn By: **SE** Sheet Size: **A1**

Drawing Title:  
**REFLECTED CEILING PLAN  
DC2  
FIRST FLOOR**

Project No.: **PR85150** Suitability: **S3**

Drawing No.: **SUD-XX-01-DR-Z-0007** Rev: **P01**