 



N.B: Existing drainage layout indicative only. Which connects into package treatment plant.

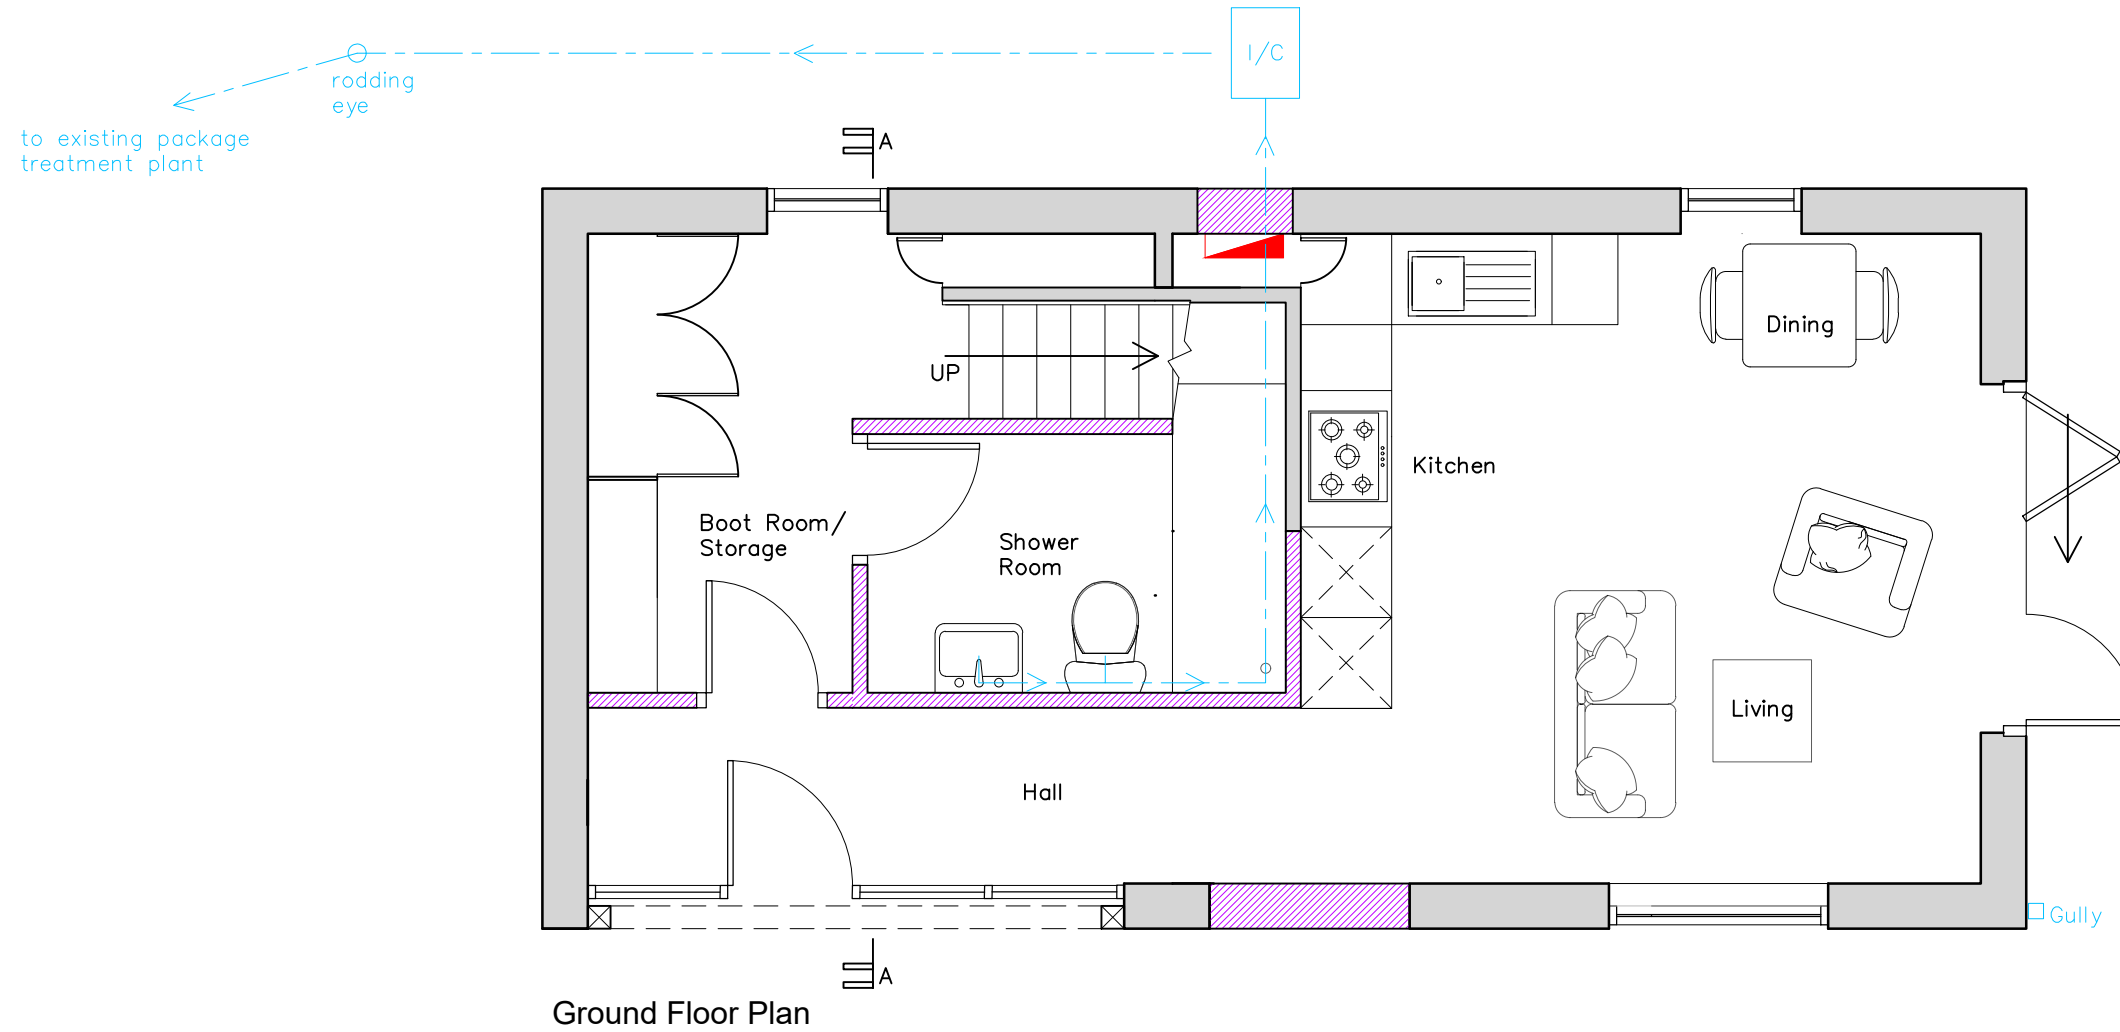

Revisions:

Rev A:	Revised Following Client Comments	Aug 2023
Rev B:	Revised Following Client Comments	Aug 2023
Rev C:	Foul Drainage Added	Oct 2023

Client:
Mr & Mrs Moulton
 Job Title:
Saybridge Lodge, Blackmore
 Drawing Title:

Proposed Floor Plans		
Scale:	Drawn By:	Date:
1:50 @ A3	LA	June 2023
Job Number:	Drawing Number:	Status:
6975	03C	Planning

whitworth

Chartered Architects & Chartered Building Surveyors
 Unit 12 Park Farm, Fornham St Genevieve, Bury St Edmunds, IP28 6TS
 01284 760421 info@whitworth.co.uk www.whitworth.co.uk

NOTE:
 Do not scale from this drawing. Confirm all dimensions on site. Refer any discrepancies to the Architect before work is put in hand. Read this drawing in conjunction with the relevant sections of the specification, schedule of works and other drawings.

This drawing is copyright of whitworth.

