
 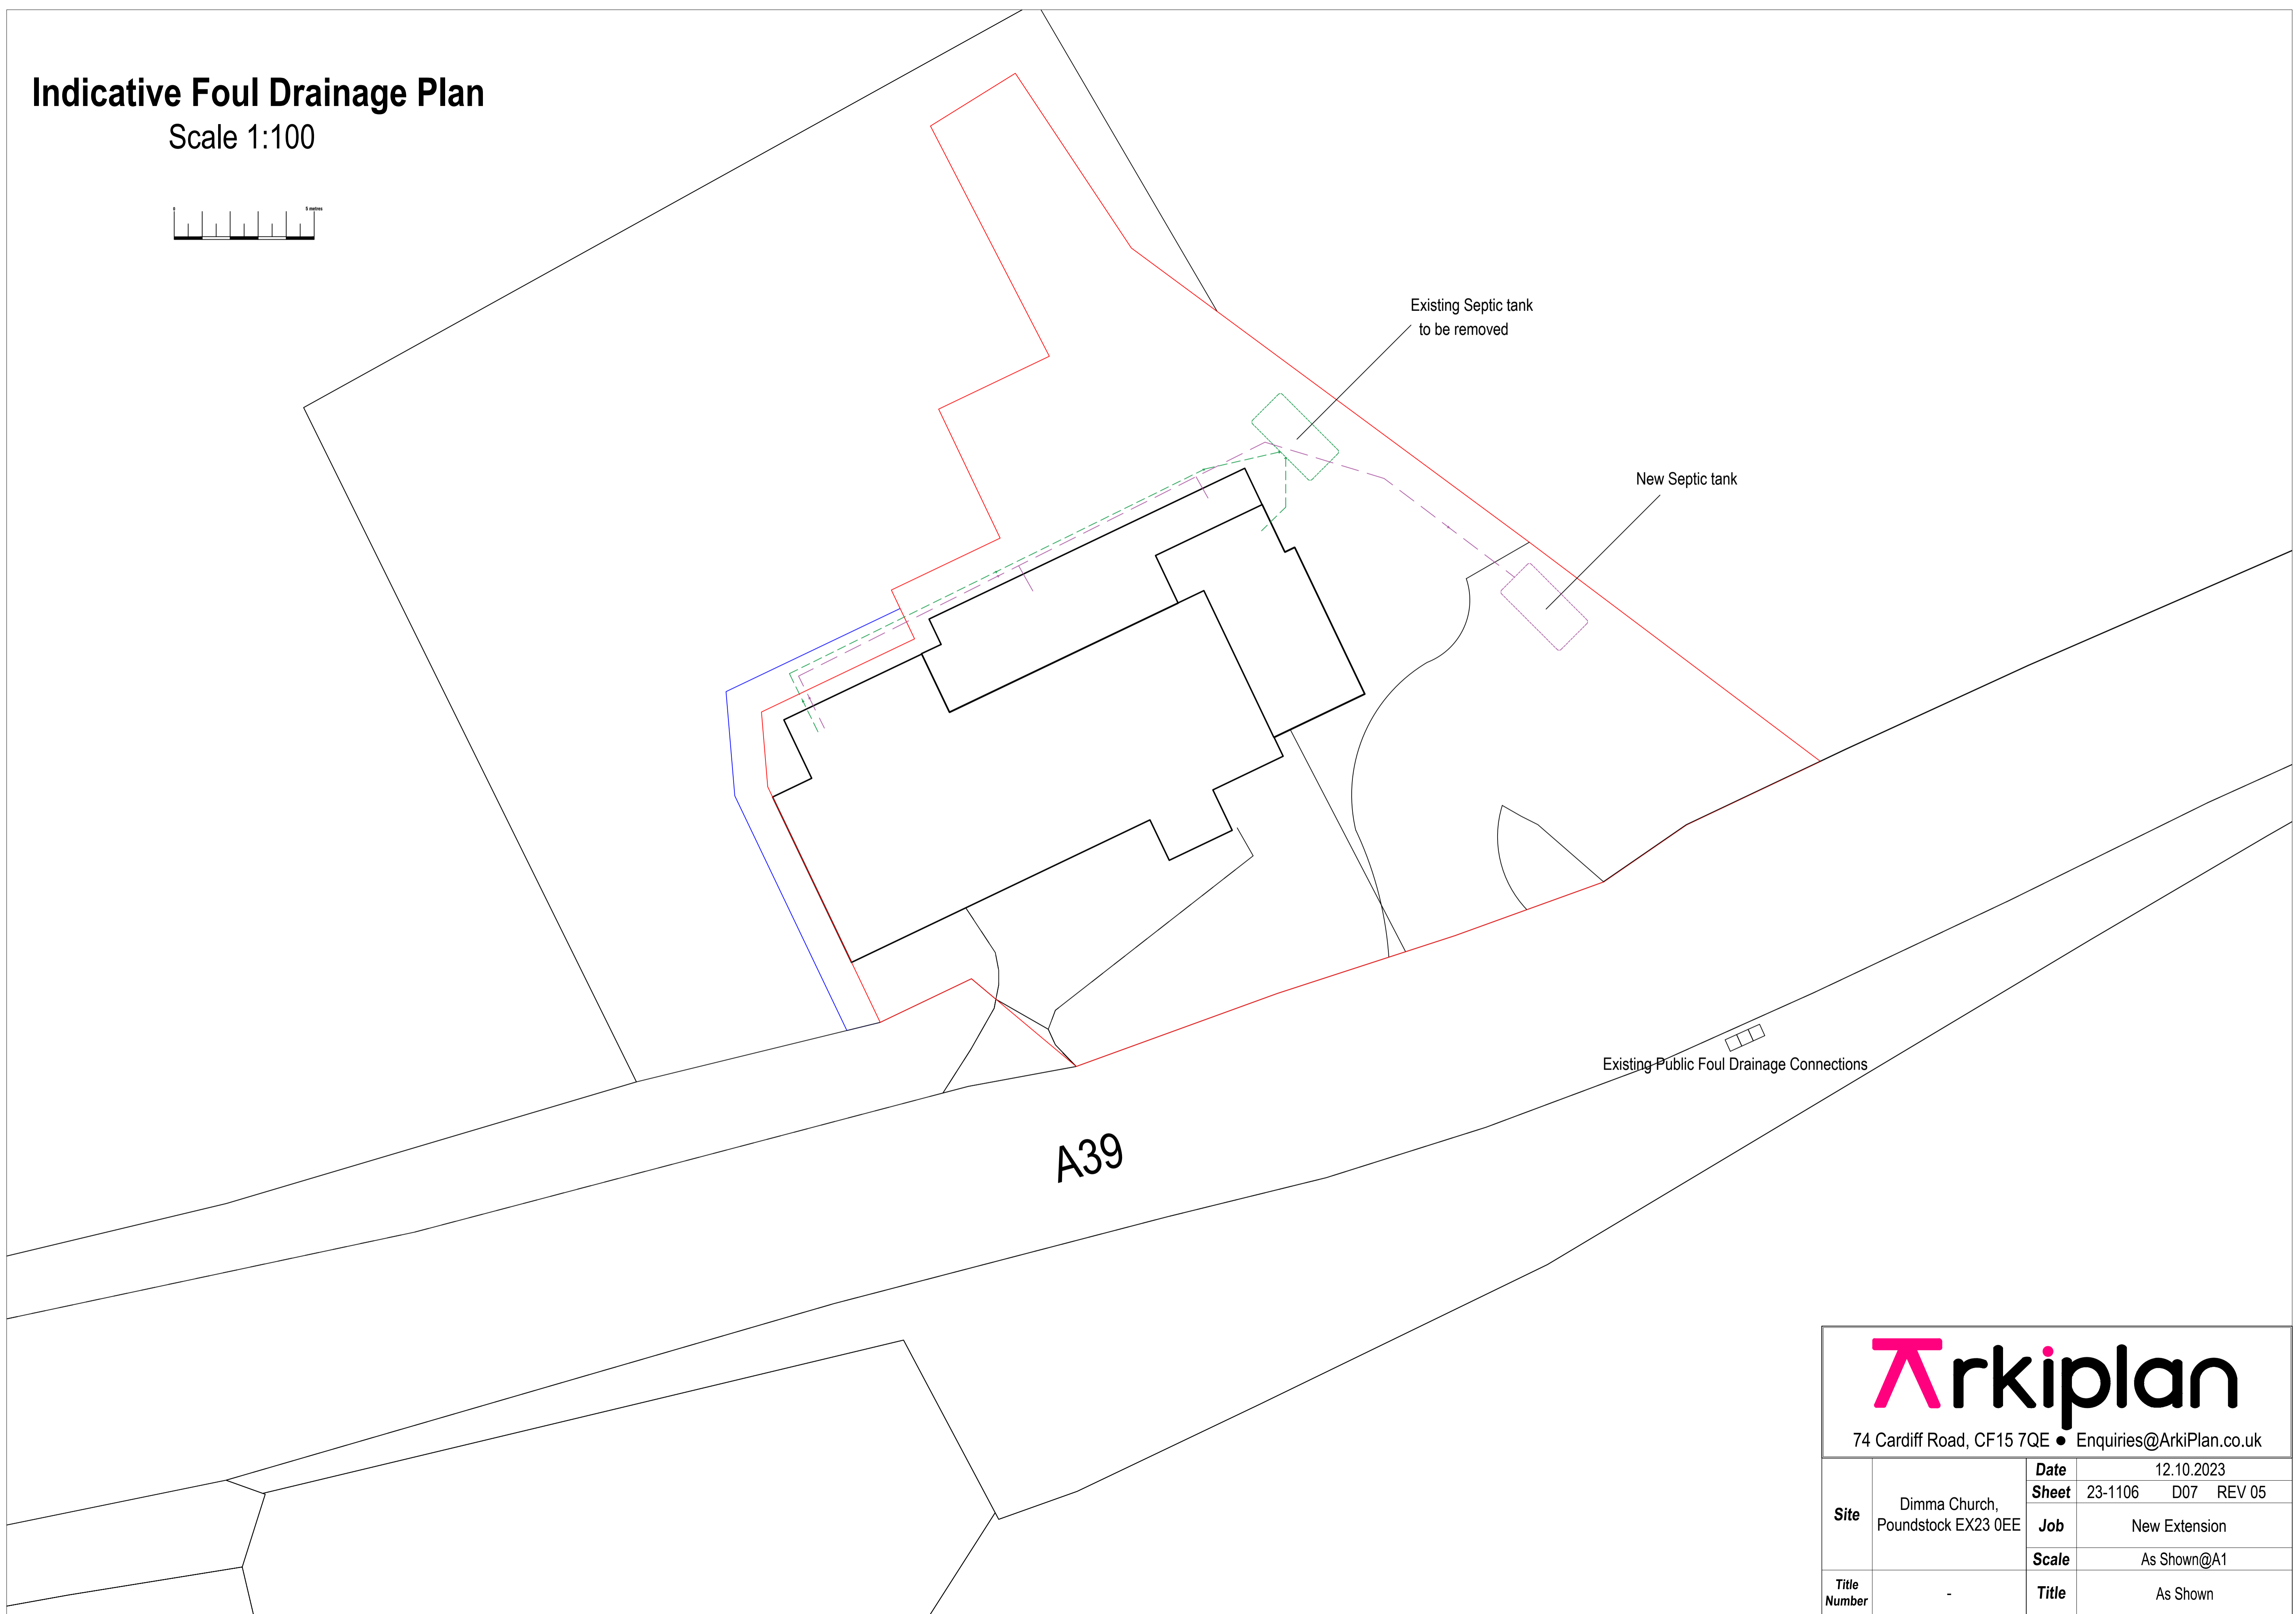


Indicative Foul Drainage Plan

Scale 1:100



Existing Septic tank
to be removed

New Septic tank

Existing Public Foul Drainage Connections

A39



74 Cardiff Road, CF15 7QE • Enquiries@ArkiPlan.co.uk

Site	Dimma Church, Poundstock EX23 0EE	Date	12.10.2023
		Sheet	23-1106 D07 REV 05
		Job	New Extension
		Scale	As Shown@A1
Title Number	-	Title	As Shown