


Existing 3m high security paladin fencing with razor wire above

Existing 3m high security paladin fencing with

Existing 3m high security paladin fencing with razor wire above

Existing 3m high security paladin fencing with razor wire above


Existing 3m high security paladin fencing with razor wire above

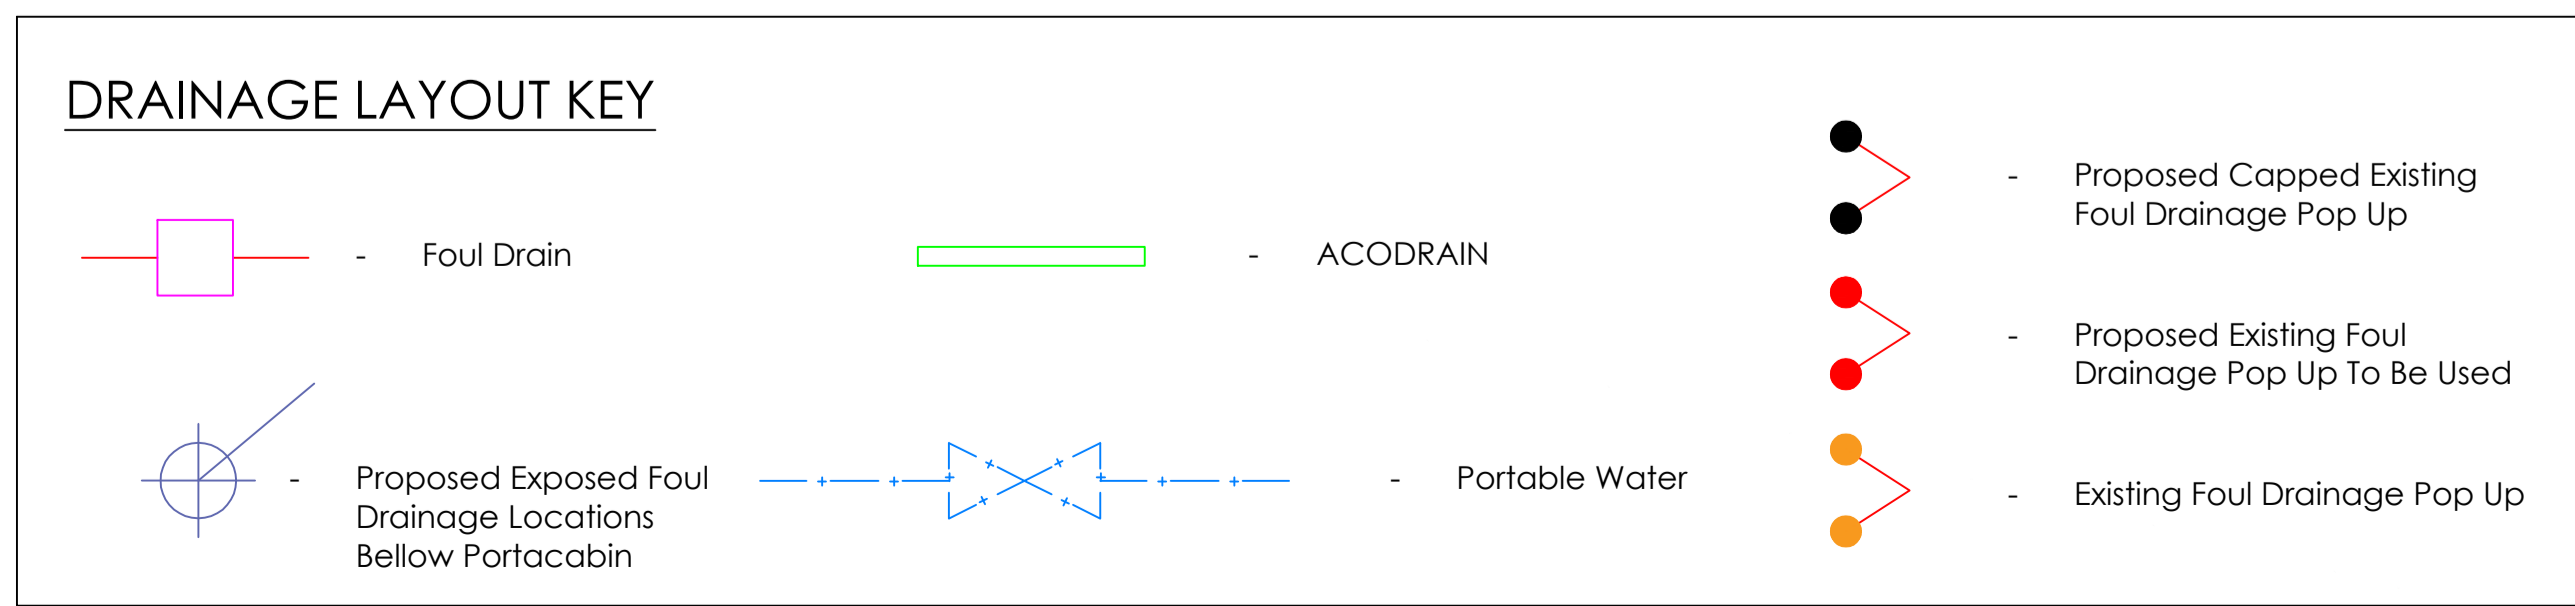

SWG French Drain


2" Polythene Main

GPO Line

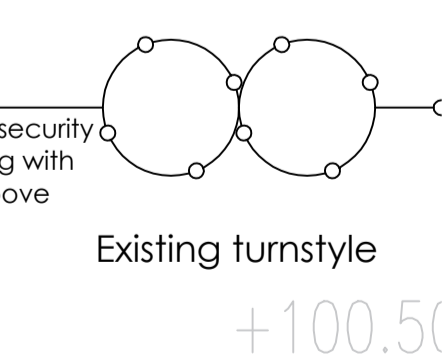

The HARRIS Group Ltd does not accept liability for any deviation to our drawings or specifications. The Drawing is copyright and may not be reproduced in whole or part without written authority. Do not scale off the drawing.

Rev.	Date	Description	Drawn	Checked
A	22/09/23	Fourth arrow and scale bar added to drawing. New roadway and generator added to the plan and new notes added.	AC	THP

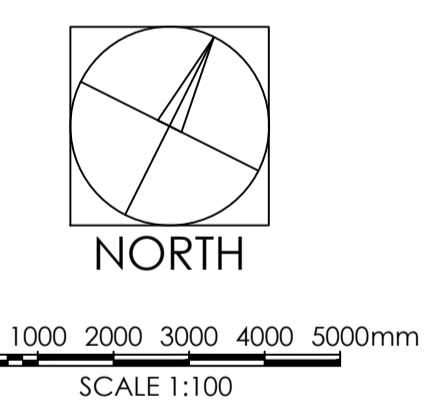

THE HARRIS PARTNERSHIP ARCHITECTS

WAKEFIELD - T. 01924 291800
23-29th Floor, Wakefield City Centre

MANCHESTER - T. 0161 2388555
Carrin Way, 77-79a West, Manchester, M1 2DG

MILTON KEYNES - T. 01908 211 577
The Old Rectory, 79 High Street, Newport Pagnell, MK44 0AA

READING - T. 0118 950 7700
101 London Road, Reading, RG1 1BT

LONDON - T. 020 7459 1215
100 Broad Street, London, W1J 7JF

Client: UK - AEA

Project Title: West Burton Power Station

Nottinghamshire
Refford
DN22 9BN

Drawing Title: Drainage Layout

Drawn	Checked	Scale @A1	BM Status	Date
AC	EG	1:100	S2	09/23

Drawing Status	Rev.	THP Project No.
PLANNING	A	19706

Project No.	Originator	Volume	Level	Type	Rate	Number
19706	THPW	XX	XX	DR	A	107