

VIEWPORT 1

all Pitch




SEE VIEWPORT 2

KEY PLAN

NOTES

Legend	
X 33.850	Proposed spot level
1:60	Proposed gradient and direction of fall
- - - - - 6.0 - - - - -	Proposed major contour
- - - - - 5.9 - - - - -	Proposed minor contour

VIEWPORT 2

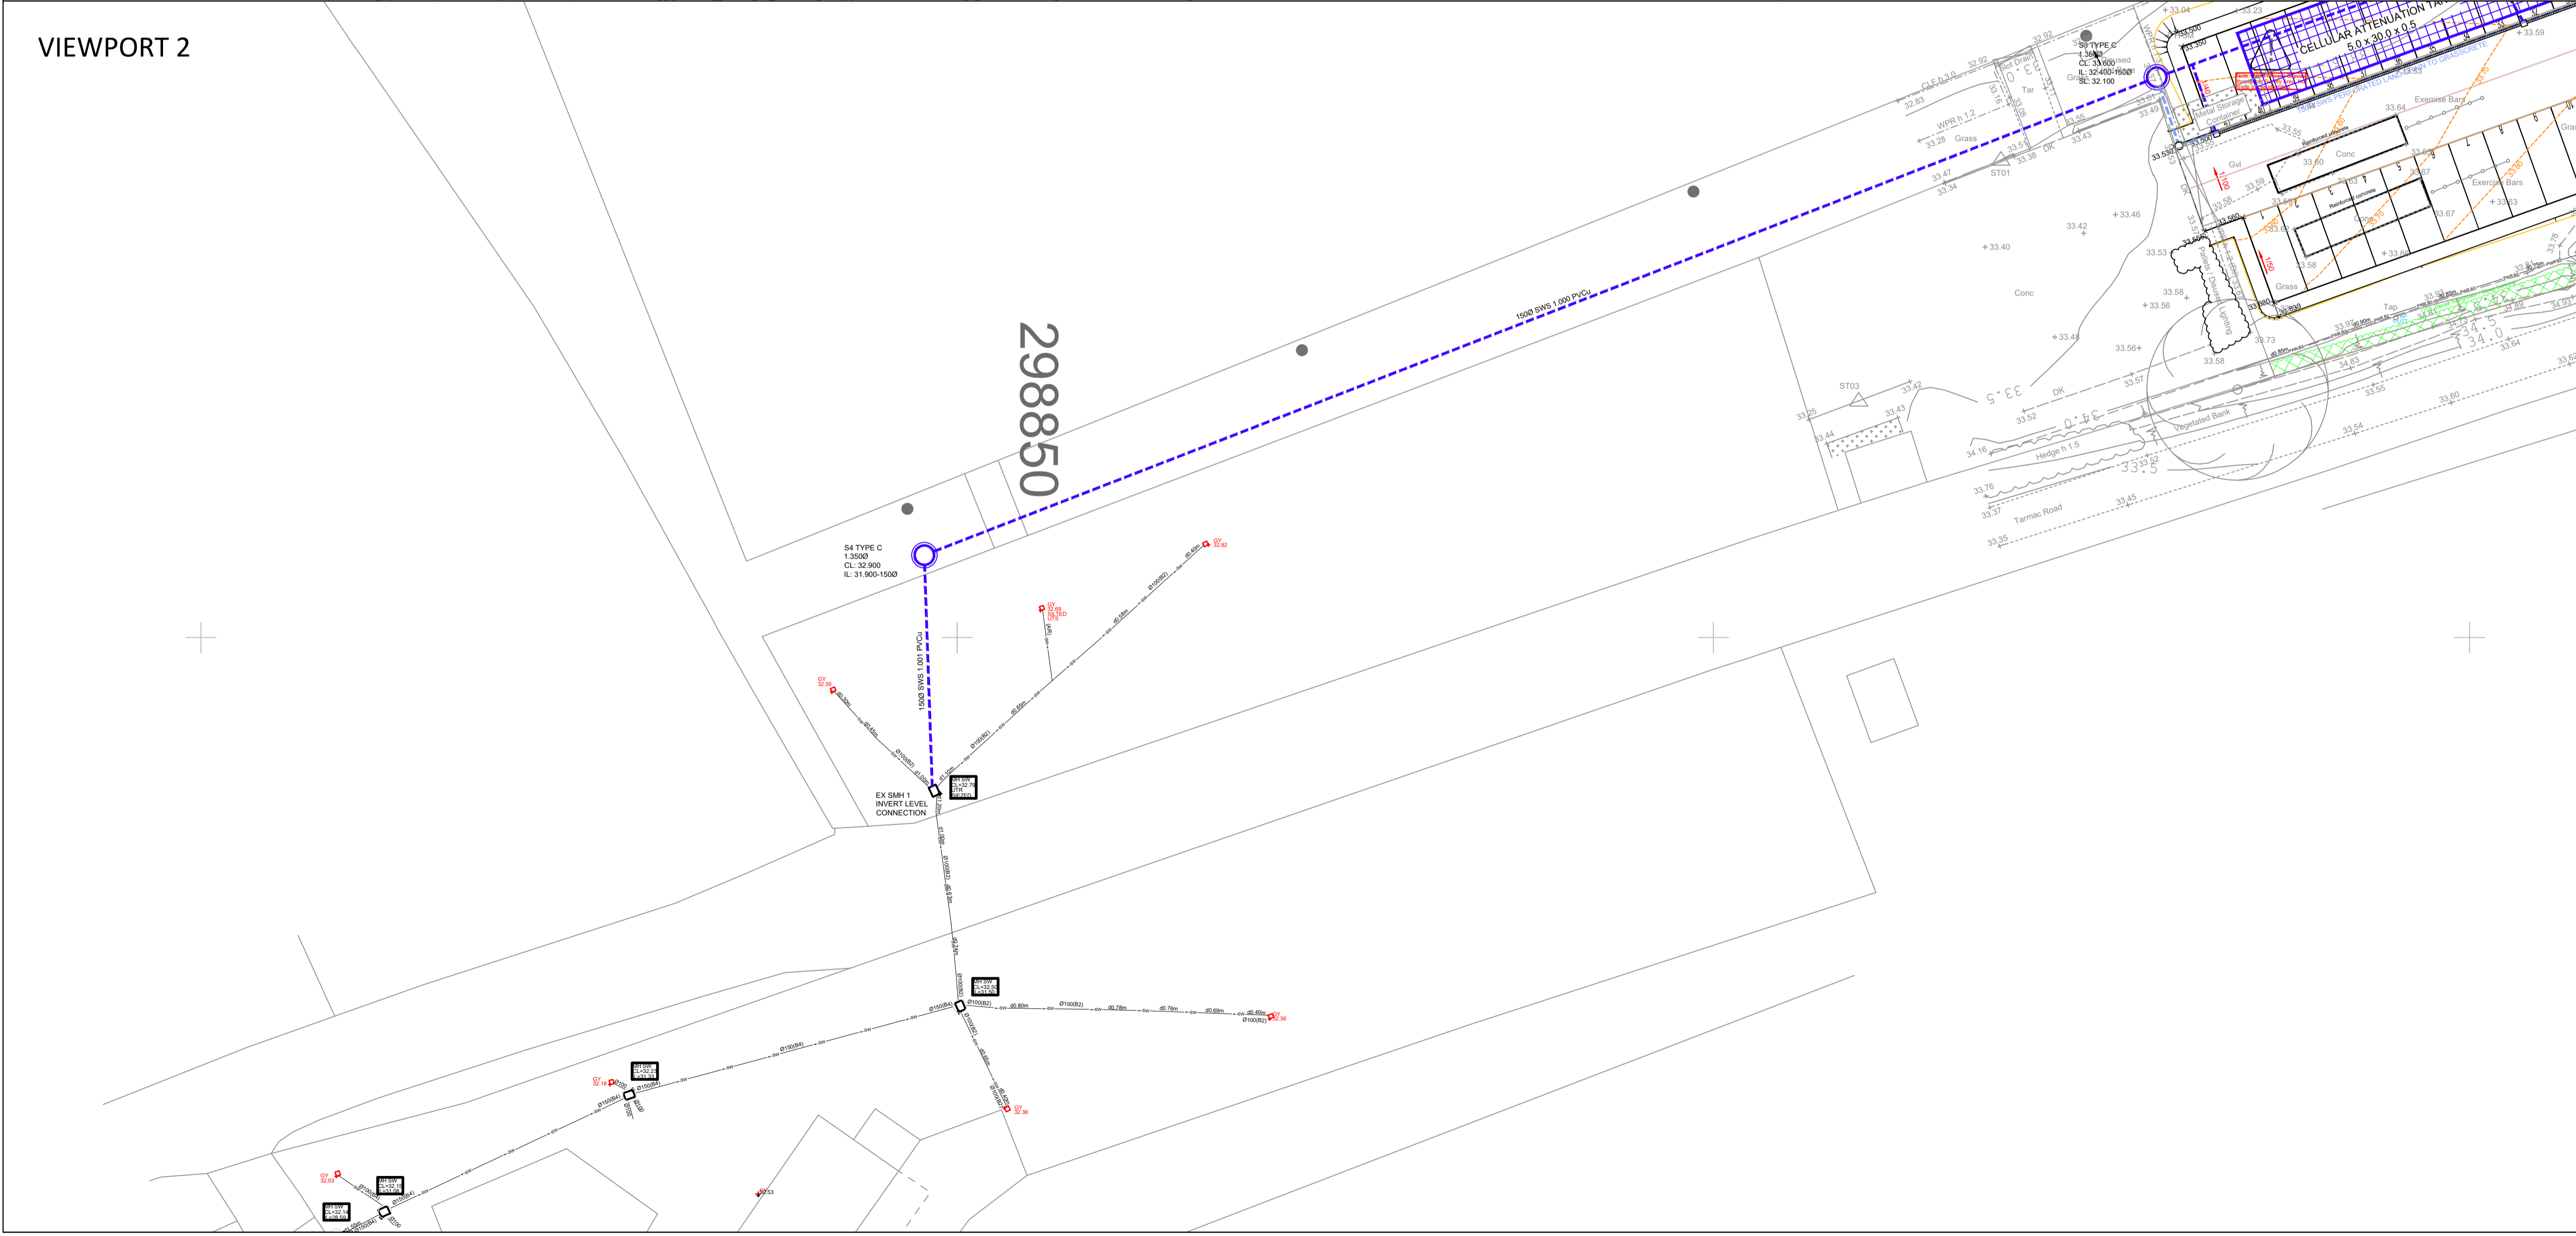

REVISIONS

NO	STAGE	ISSUE	DATE	BY	DATE	BY
P04	STAGE 3	ISSUE	21.07.23	A.THOM	21.07.23	P.START
P03	DRAINAGE UPDATED TO SUIT CALCULATIONS					
	A.THOM		22.03.23	A.THOM	22.03.23	P.START
P02	ISSUE FOR INFORMATION - DRAINAGE ADDED					
	A.THOM		15.03.23	A.THOM	15.03.23	P.START
P01	ISSUE FOR INFORMATION					
	T.BELLINGHAM		14.10.22	P.START	14.10.22	P.START
REV	REVISION NOTES/COMMENTS					
	DRAWN BY	DATE	CHECKED BY	DATE	APPROVED BY	DATE

Hydrock HYDROCK CONSULTANTS LTD
 LOBB SHIPPON
 PLYMOUTH
 PL7 5BP
 T: +44 (0) 1752 347515
 e: plymouth@hydrock.com

CLIENT
 VIVO Defence Services Ltd

PROJECT
 LYMPSTONE CAR PARK

TITLE
 LEVELS AND DRAINAGE LAYOUT

HYDROCK PROJECT NO. C-24227-C	SCALE @ A1 1:250	STATUS S1
STATUS DESCRIPTION SUITABLE FOR CO-ORDINATION		REVISION P04
DRAWING NO. (PROJECT CODE-ORIGINATOR ZONE-LEVEL-TYPE-ROLE-NUMBER) 24227-HYD-XX-XX-DR-C-100		