

Velux Conservation Rooflight.



Velux GGU CK04  
Conservation Rooflight  
(550 x 980mm) c/w  
recessed flashing.

Extract fan ducted to  
in-line slate vent.

TV.

**SOUTH-WEST ELEVATION**

SCALE 1:50 @ A3

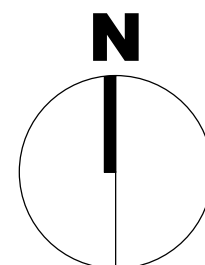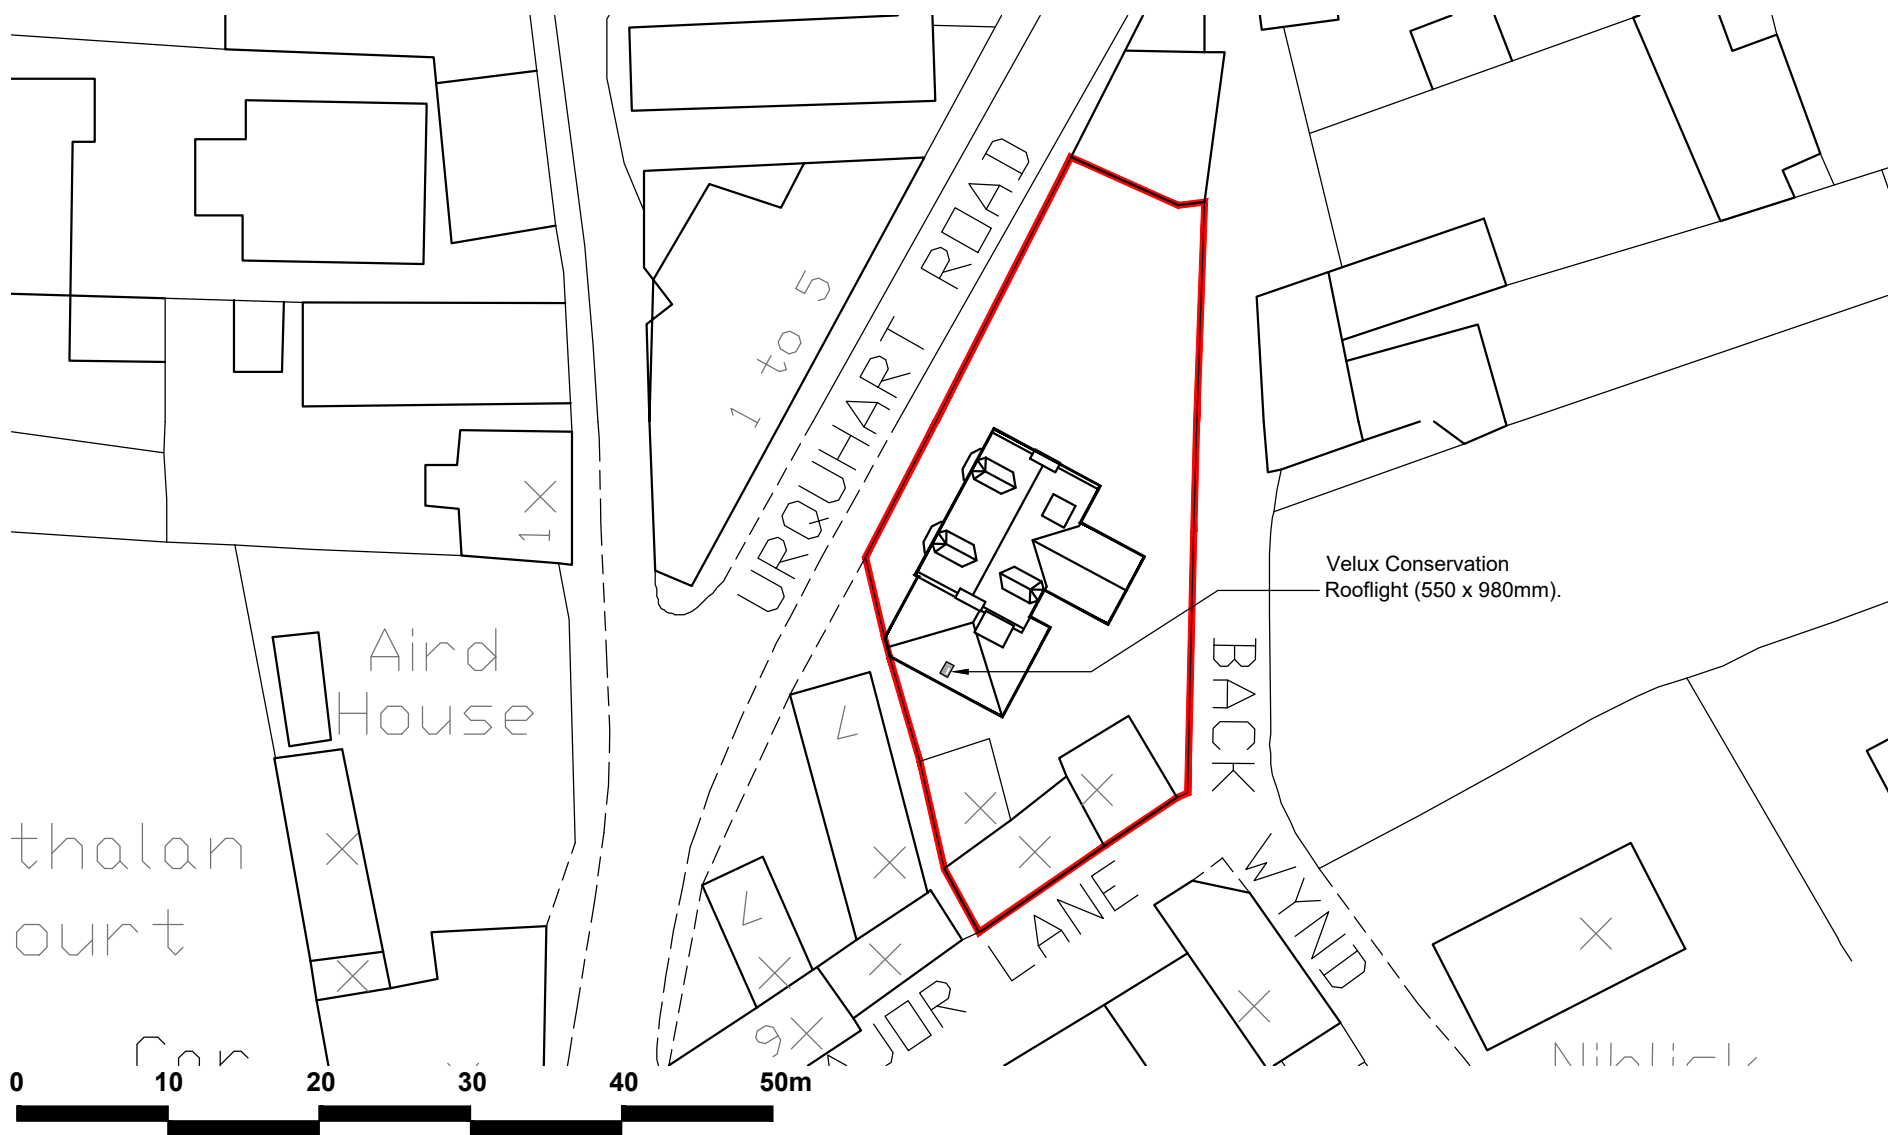

SCALE 1:500

Ordnance Survey (c) Crown Copyright 2023. All rights reserved. Licence number 100022432

PROJECT TITLE:  
ALTERATIONS TO DWELLING HOUSE AT  
UGIE BANK, URQUHART ROAD,  
OLDMELDRUM, AB51 0EX.

DATE:  
OCTOBER 2023

DRAWING DESCRIPTION:  
SITE PLAN / ELEVATION.

DRAWN BY:  
CAD

SCALE:  
VARIES @ A4

DRAWING No:  
**IDA /23040 /W02**

REV:  
**A**

ian duncan **architects**

25 MARKET PLACE - INVERURIE  
ABERDEENSHIRE - AB51 3PU  
tel: 01467 625500  
fax: 01467 623435  
e-mail: info@ianduncanarchitects.co.uk  
web: www.ianduncanarchitects.co.uk