 




THE CONTRACTOR SHALL NOTE THESE DRAWINGS ARE DESIGN DRAWINGS. THE CONTRACTOR IS TO DEVELOP THE DESIGN INTO WORKING DRAWINGS IN COORDINATION WITH ALL ARCHITECTS, STRUCTURAL & SERVICES DRAWINGS AND SPECIFICATIONS. THE CONTRACTORS WORKING DRAWINGS SHALL BE USED AS THE BASE DRAWINGS FOR THE INSTALLATION. THESE DRAWINGS SHALL BE SUBMITTED TO THE ENGINEER & ARCHITECT FOR THEIR COMMENTS/APPROVAL PRIOR TO INSTALLATION. FAILURE TO ADHERE TO THE ABOVE MAY RESULT IN THE CONTRACTOR HAVING TO REMOVE AND REINSTALL THE EQUIPMENT AT THEIR OWN COST.

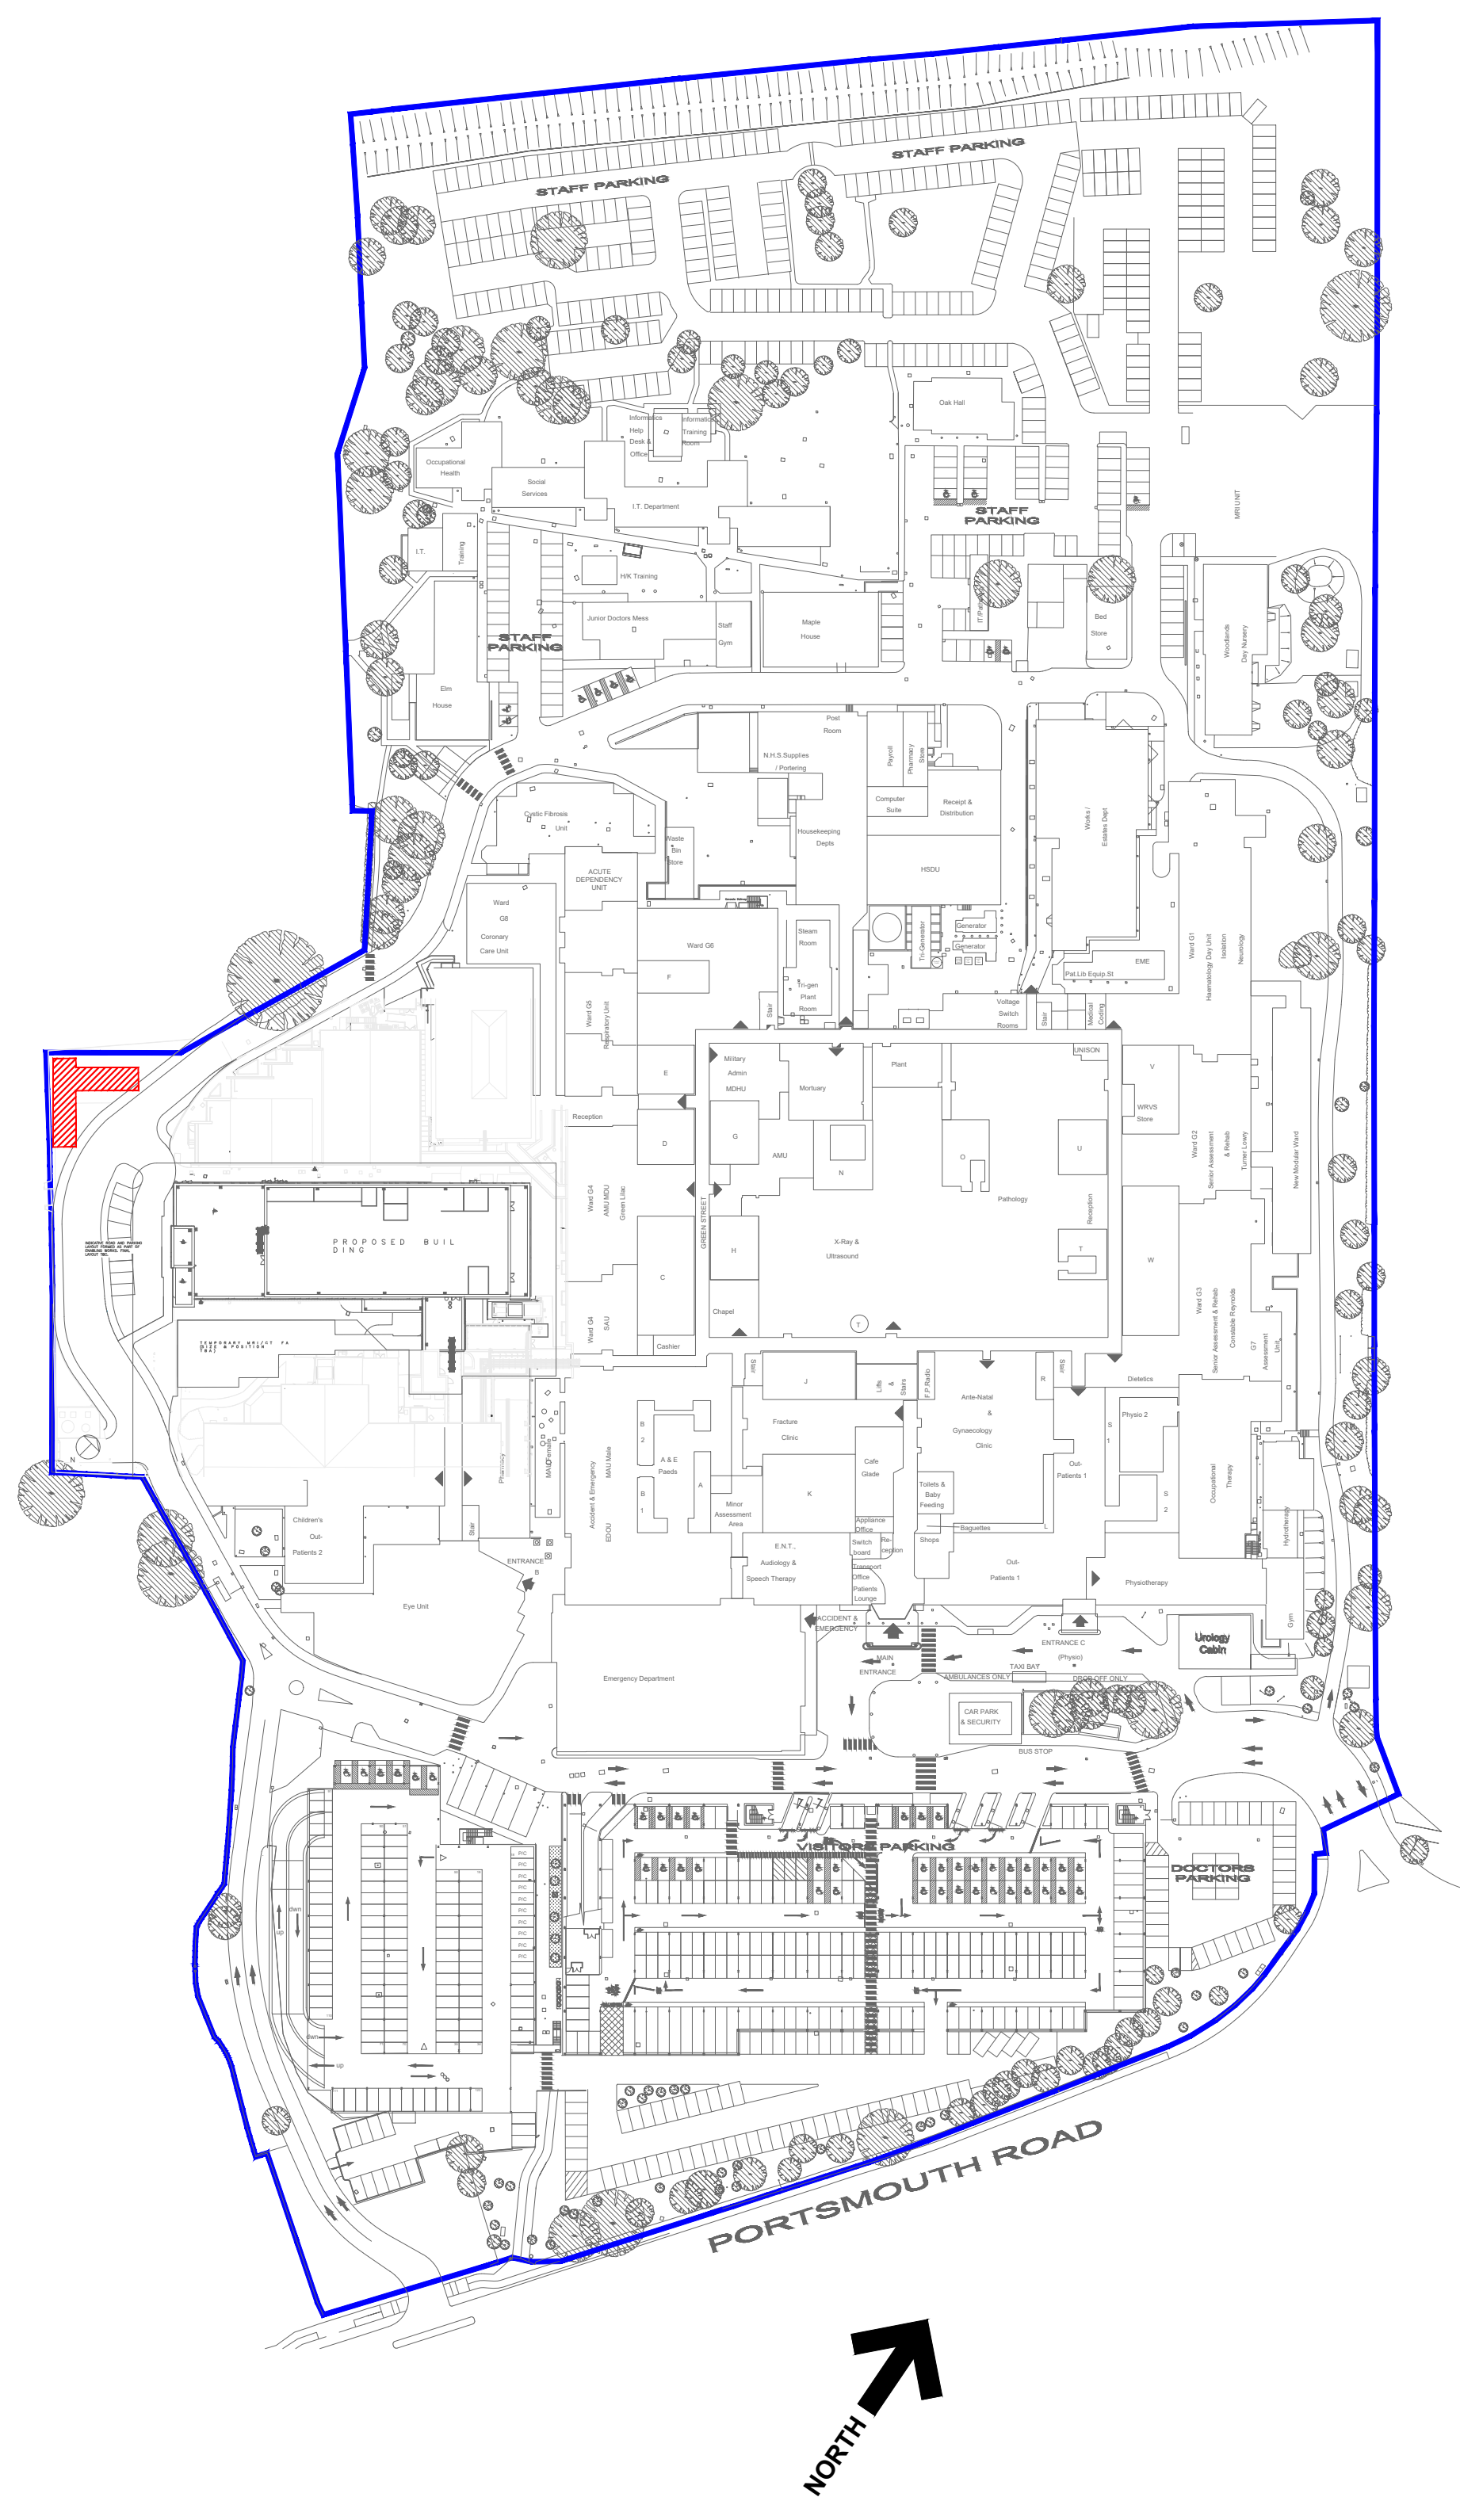

This drawing is copyright & may not be altered, reproduced or used other than for the Contract Works for which it is issued without the written permission of Stuart McCurry & Partners Limited.
 Do not scale this drawing. Verify all dimensions & structural details on site. If in doubt, ask before acting.
 Read this drawing in conjunction with the appropriate Specification(s).
 The purpose of this drawing when issued as a Tender Drawing is to enable tenderers to interpret correctly the design and to submit competitive tenders for the works. A Tender Drawing whether original or amended shall not be used as an installation Drawing except under the terms contained in the conditions of Tender.

edition	date	designed	drawn	checked
P1	03.07.23	SG	MM	
P2	19.07.23	SG	MM	
P1	PRELIMINARY ISSUE			
P2	PRELIMINARY ISSUE			

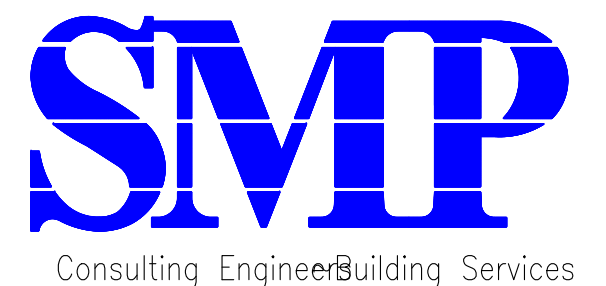

Stuart McCurry & Partners Limited
 11 Chiltern Court
 Asheridge Road
 Chesham
 Buckinghamshire HP5 2PX
 Email: engineers@smpengineering.co.uk
 Web: www.stuart-mccurry-partners.co.uk
 Tel: 01296 696780

job title
**FRIMLEY HEALTH
 M BLOCK SUBSTATION**

drawing title
**Electrical Services
 EXISTING SITE PLAN**

job no.	scale	status
23-025	1:1250@A1	PRELIMINARY
drawing no.	edition	
SK-E-00-123-10	P2	