
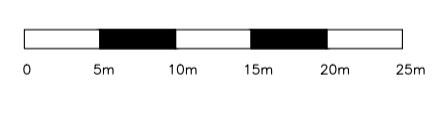



THE CONTRACTOR SHALL NOTE THESE DRAWINGS ARE DESIGN DRAWINGS. THE CONTRACTOR IS TO DEVELOP THE DESIGN INTO WORKING DRAWINGS IN COORDINATION WITH ALL ARCHITECTS, STRUCTURAL & SERVICES DRAWINGS AND SPECIFICATIONS. THE CONTRACTOR'S WORKING DRAWINGS SHALL BE USED AS THE BASE DRAWINGS FOR THE INSTALLATION. THESE DRAWINGS SHALL BE SUBMITTED TO THE ENGINEER & ARCHITECT FOR THEIR COMMENTS/APPROVAL PRIOR TO INSTALLATION. FAILURE TO ADHERE TO THE ABOVE MAY RESULT IN THE CONTRACTOR HAVING TO REMOVE AND REINSTALL THE EQUIPMENT AT THEIR OWN COST.

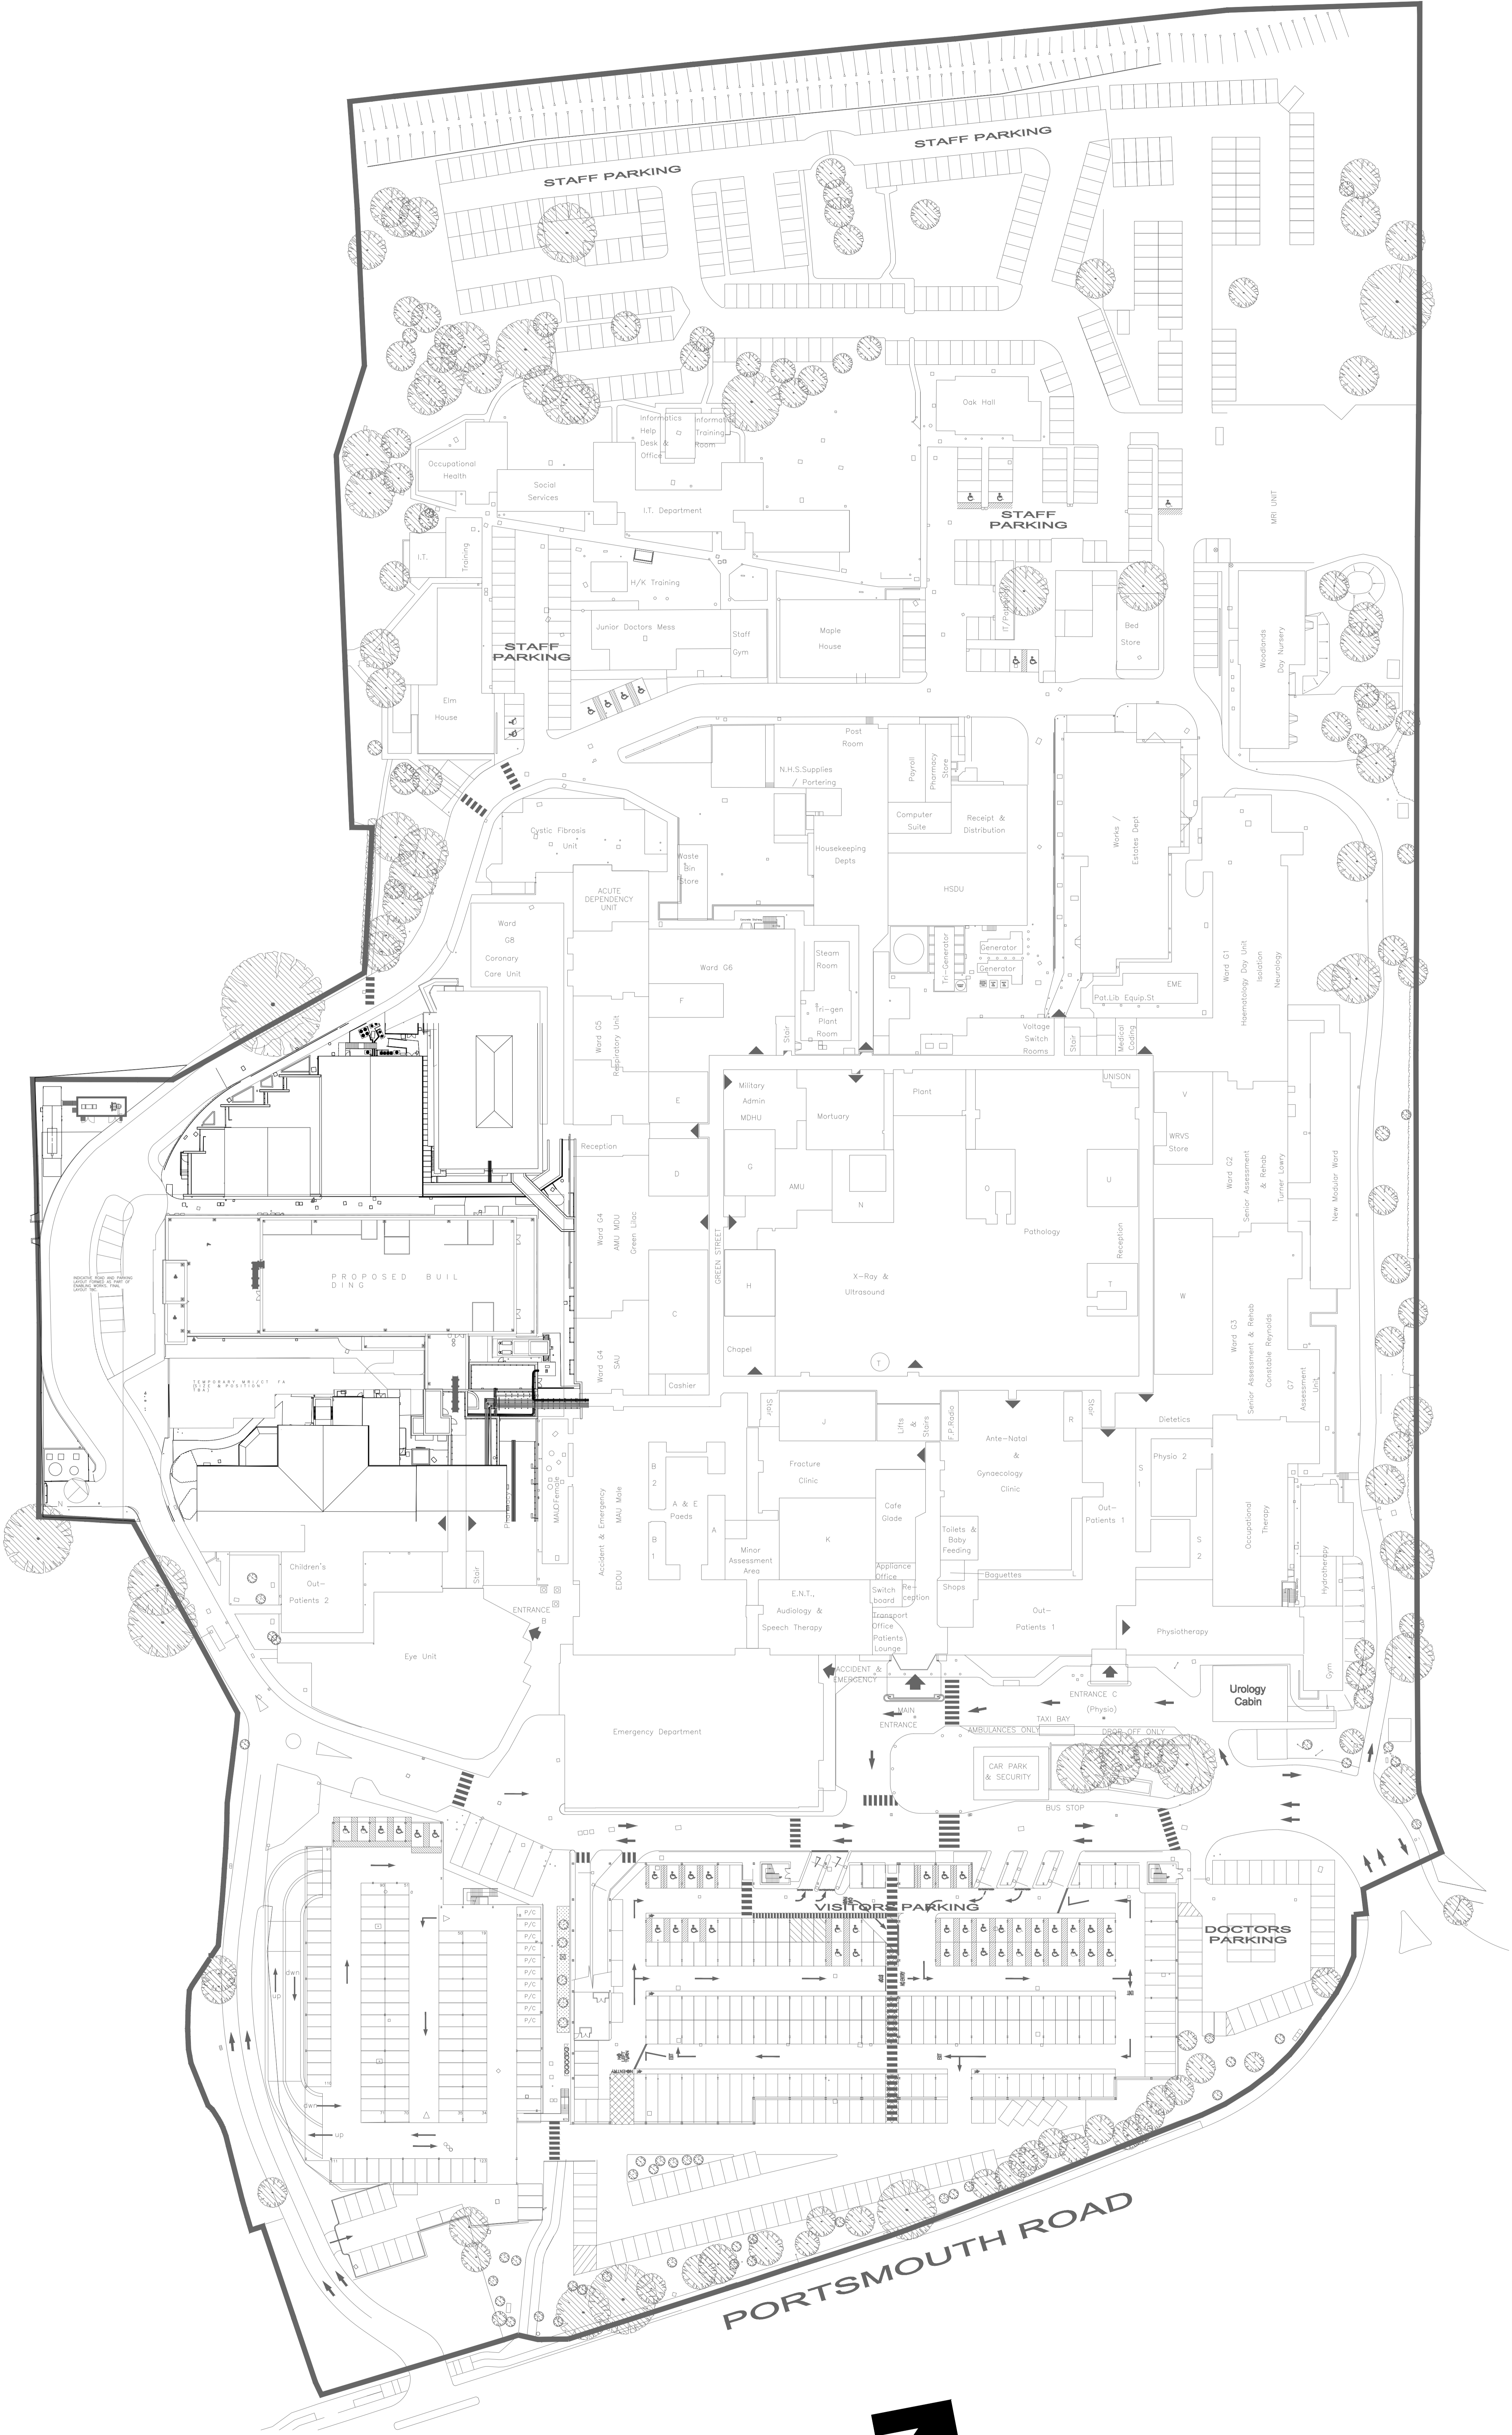

This drawing is copyright & may not be altered, reproduced or used other than for the Contract Works for which it is issued without the written permission of Stuart McCury & Partners Limited. Do not scale this drawing. Verify all dimensions & structural details on site. Fit in situ, with before works.

This drawing is for information only and is not to be used as a tender drawing. The design is preliminary and is subject to change without notice. The design is preliminary and is subject to change without notice. The design is preliminary and is subject to change without notice.

revision	date	prepared	checked	checked
P1	11.07.23	CS	MM	
P2	11.07.23	CS	MM	
P1				
P2				

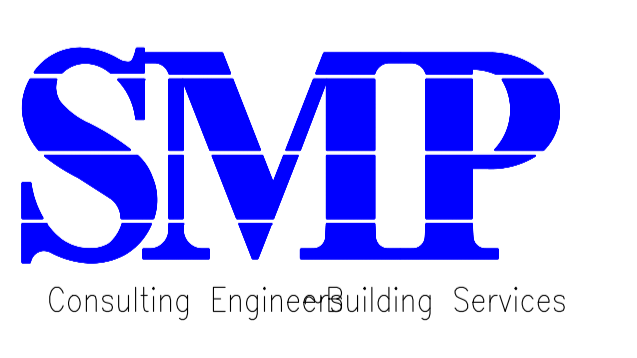

Stuart McCury & Partners Limited
11 Chalfen Court
Aldershot Road
Chesham
Buckinghamshire HP5 2PX
Email: engineers@smpengineering.co.uk
Web: www.stuart-mccury-partners.co.uk
Tel: 01296 696700

job title
**FRIMLEY HEALTH
M BLOCK SUBSTATION**

drawing title
**Electrical Services
PROPOSED SITE PLAN**

job no.	scale	status
23-025	1:500@A0	PRELIMINARY
drawing no.	SK-E-00-123-12	
		P2