



Notes:
 This drawing is based upon HB Surveys Drawing No: 1563/07.
 1. Levels are related to the O.S. National GPS network.

Do not scale off this drawing. All dimensions to be checked onsite

REVISIONS
 A 12-10-2023 AIR SOURCE HEAT EQUIPMENT SHOWN



KEY
 DAIKIN AIR SOURCE HEAT PUMP UNITS.
 UNDERGROUND DUCT LINKING TO BOILER ROOM.


520 N

500 N

400 E

500 E

520 E

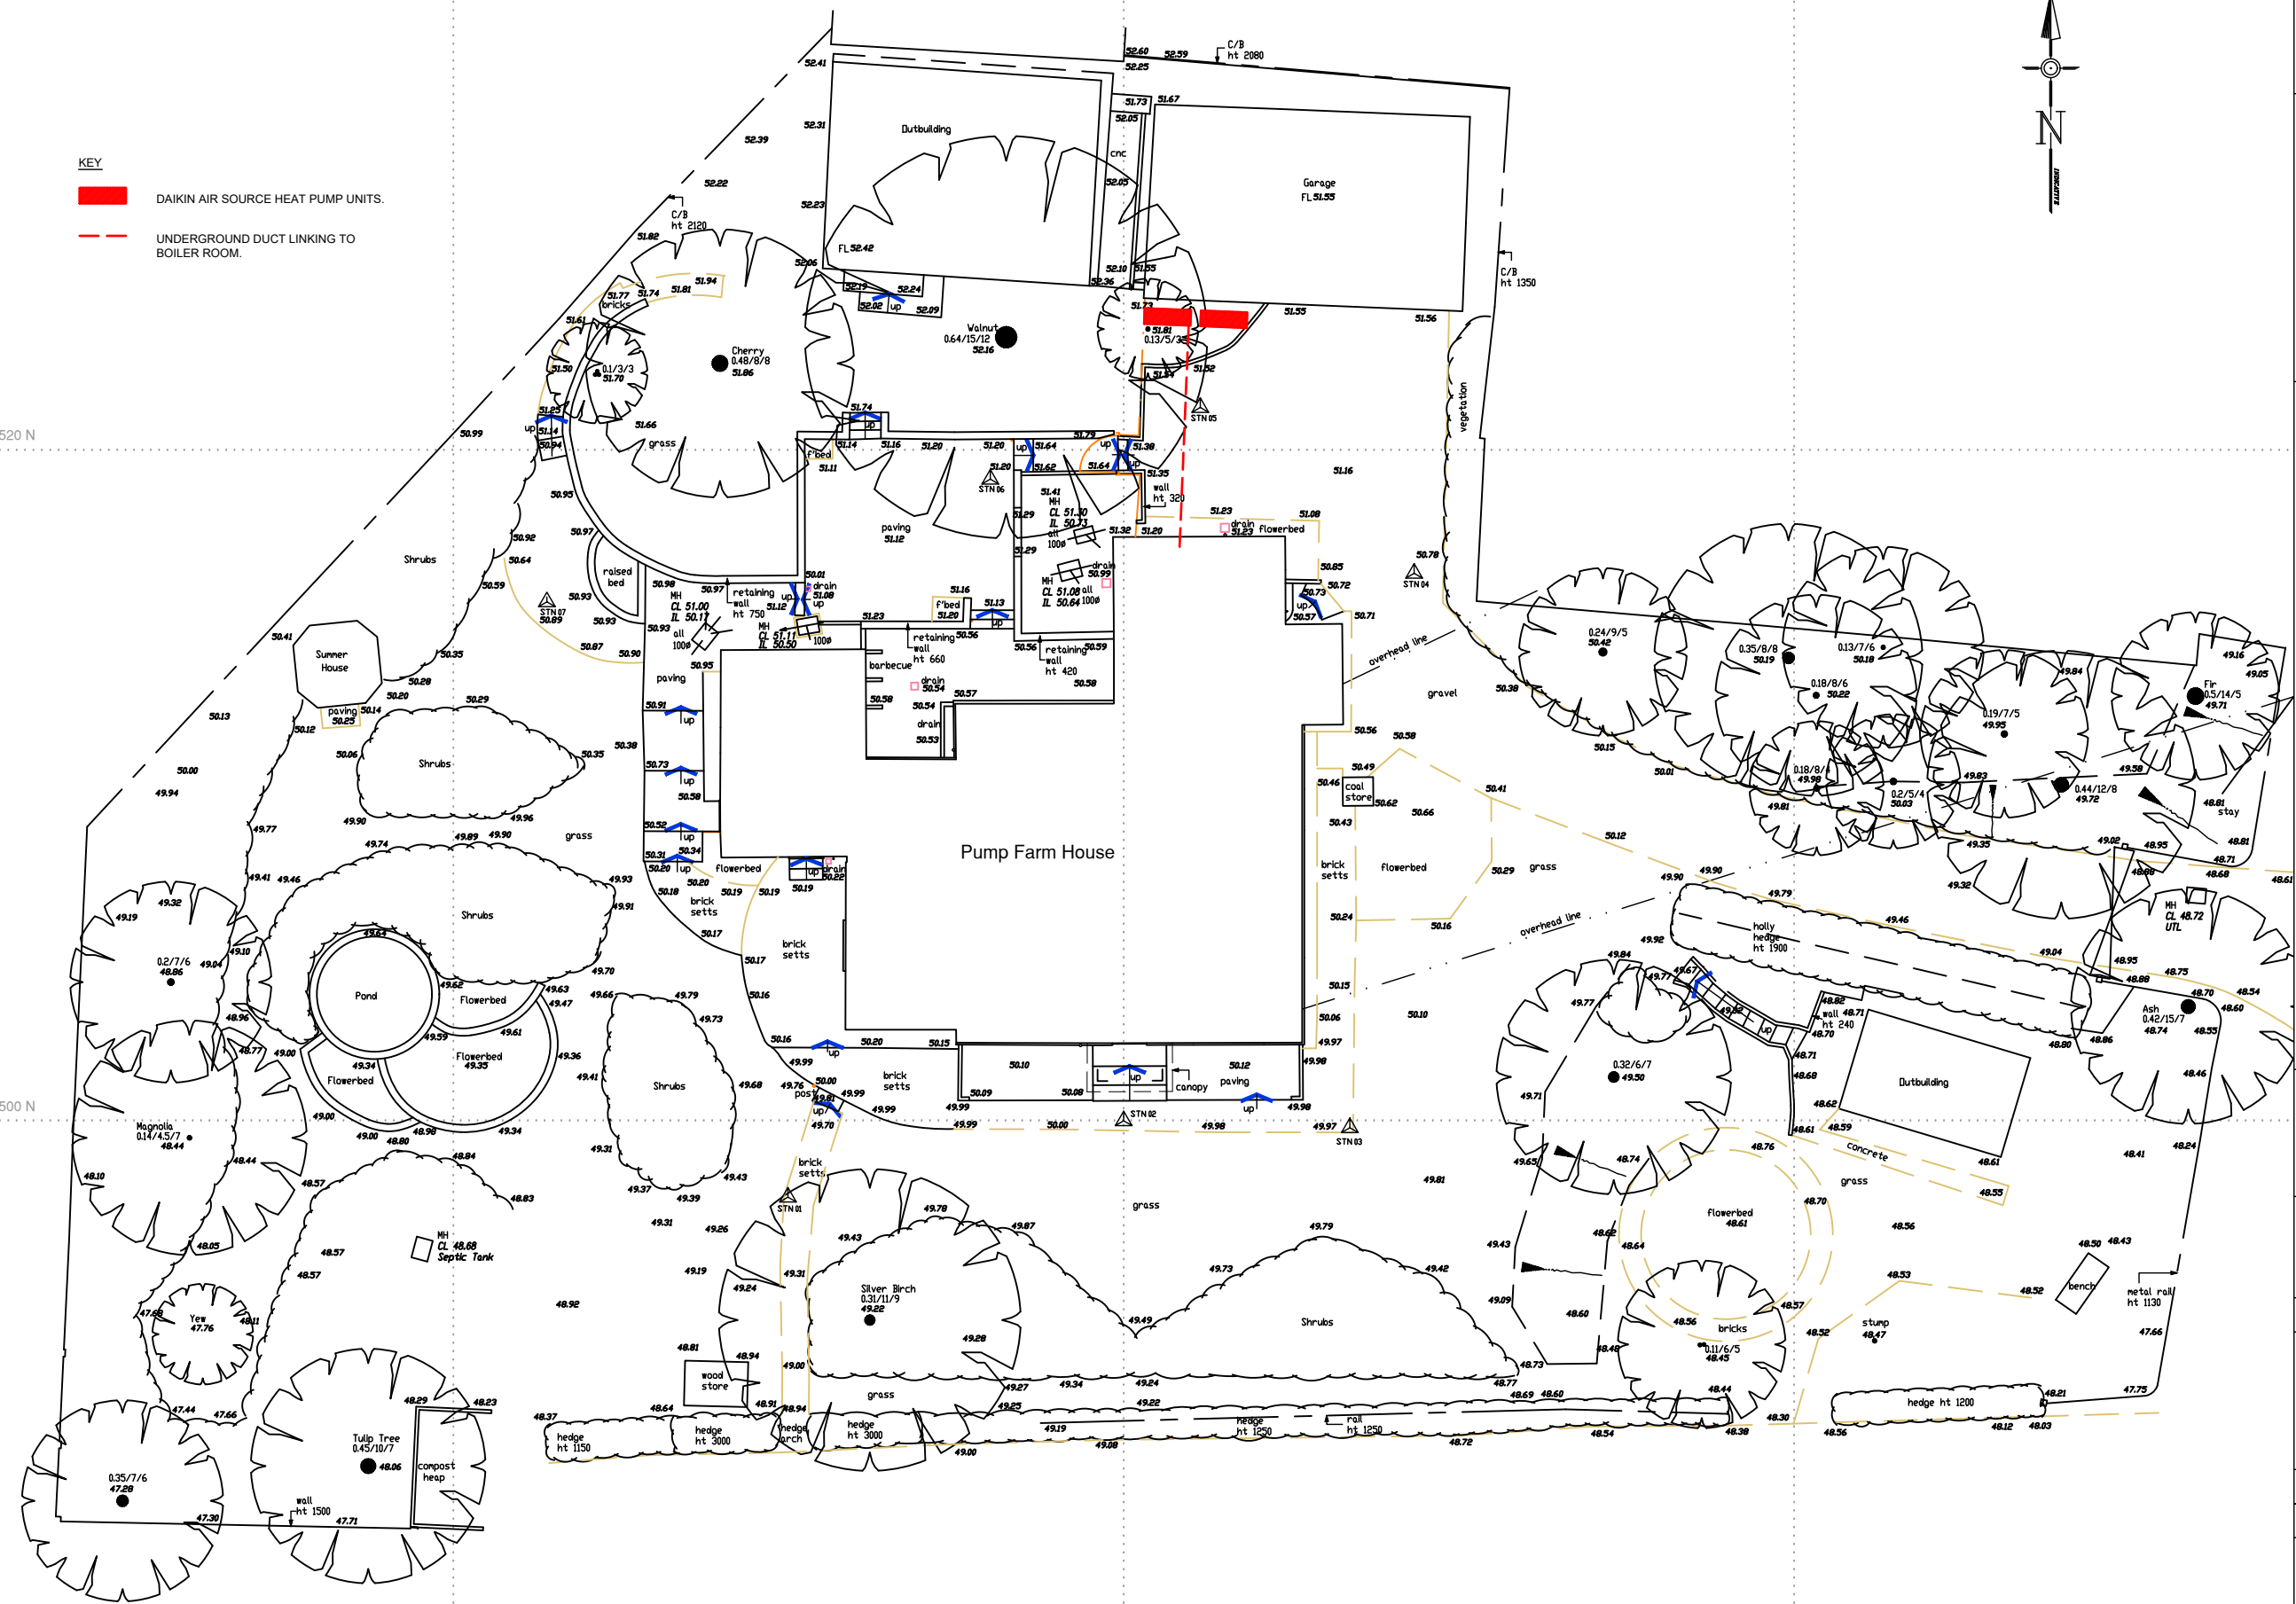

CLIENT	Madelein and Hennie Van De Merwe
PROJECT	Pump Farmhouse, Warley: Proposed Alterations
DRAWING TITLE	Site Plan
SIZE & SCALE	A3 1:200
DATE	March 2023
JOB NUMBER	2022/79
DRAWING NO.	2022/79/01
REVISION	A

CBA cbarchitecture
 The Studio
 47 Colchester Road
 West Bergholt
 CO6 3JQ
 m. 07970 097417
 e. chrisbetts@cbarchitecture.co.uk