




- NOTES**
- DO NOT SCALE THIS DRAWING. WORK TO FIGURED DIMENSIONS ONLY. ALL DIMENSIONS ARE IN MILLIMETRES (mm) UNLESS NOTED OTHERWISE.
  - This drawing is to be read in conjunction with all relevant Architect's, Engineer's and Specialist's drawings and their respective Specifications.
  - All work to comply with the relevant British Standards, Codes of Practice and the Building Regulations.
  - Any discrepancies between all working drawings, specifications and schedules of all disciplines to be immediately notified to CTP for clarification/correction prior to construction of relevant structure.

- KEY**
- Existing SW network - To be confirmed
  - Foul Water Drain
  - Surface Water Drain
  - 1200Ø PCC S.W. Manhole
  - PPIC S.W. Inspection Chamber
  - FG Foul Gully
  - svp Soil & Vent Pipe

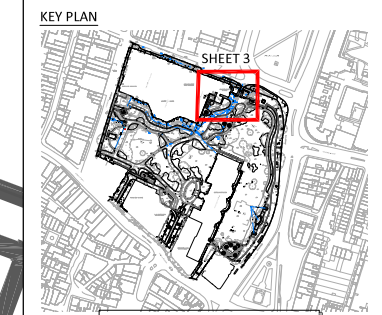

**PRELIMINARY**

P3	Amendments as per comments	05.09.23	SV	SM
P2	Changes in drainage layout	11.08.2023	SV	SM
P1	Preliminary	02.08.23	SF	AK

Revision: Amendments Date Rev'd Child  
SF August 2023 CIVIL

**ctp consulting engineers**

Suffolk House 154 High Street  
Sevenoaks Kent TN13 1XE UK  
UKC +44 (0)1732 740195  
www.ctp-llp.com


Project Title: **Royal Pavilion Gardens**

Drawing Title: **Proposed Drainage Layout Sheet 3 of 5**

Drawing Number: **A8394-1502**

Scale: **1:200 @A1**  
Unless Noted Otherwise

**P3**

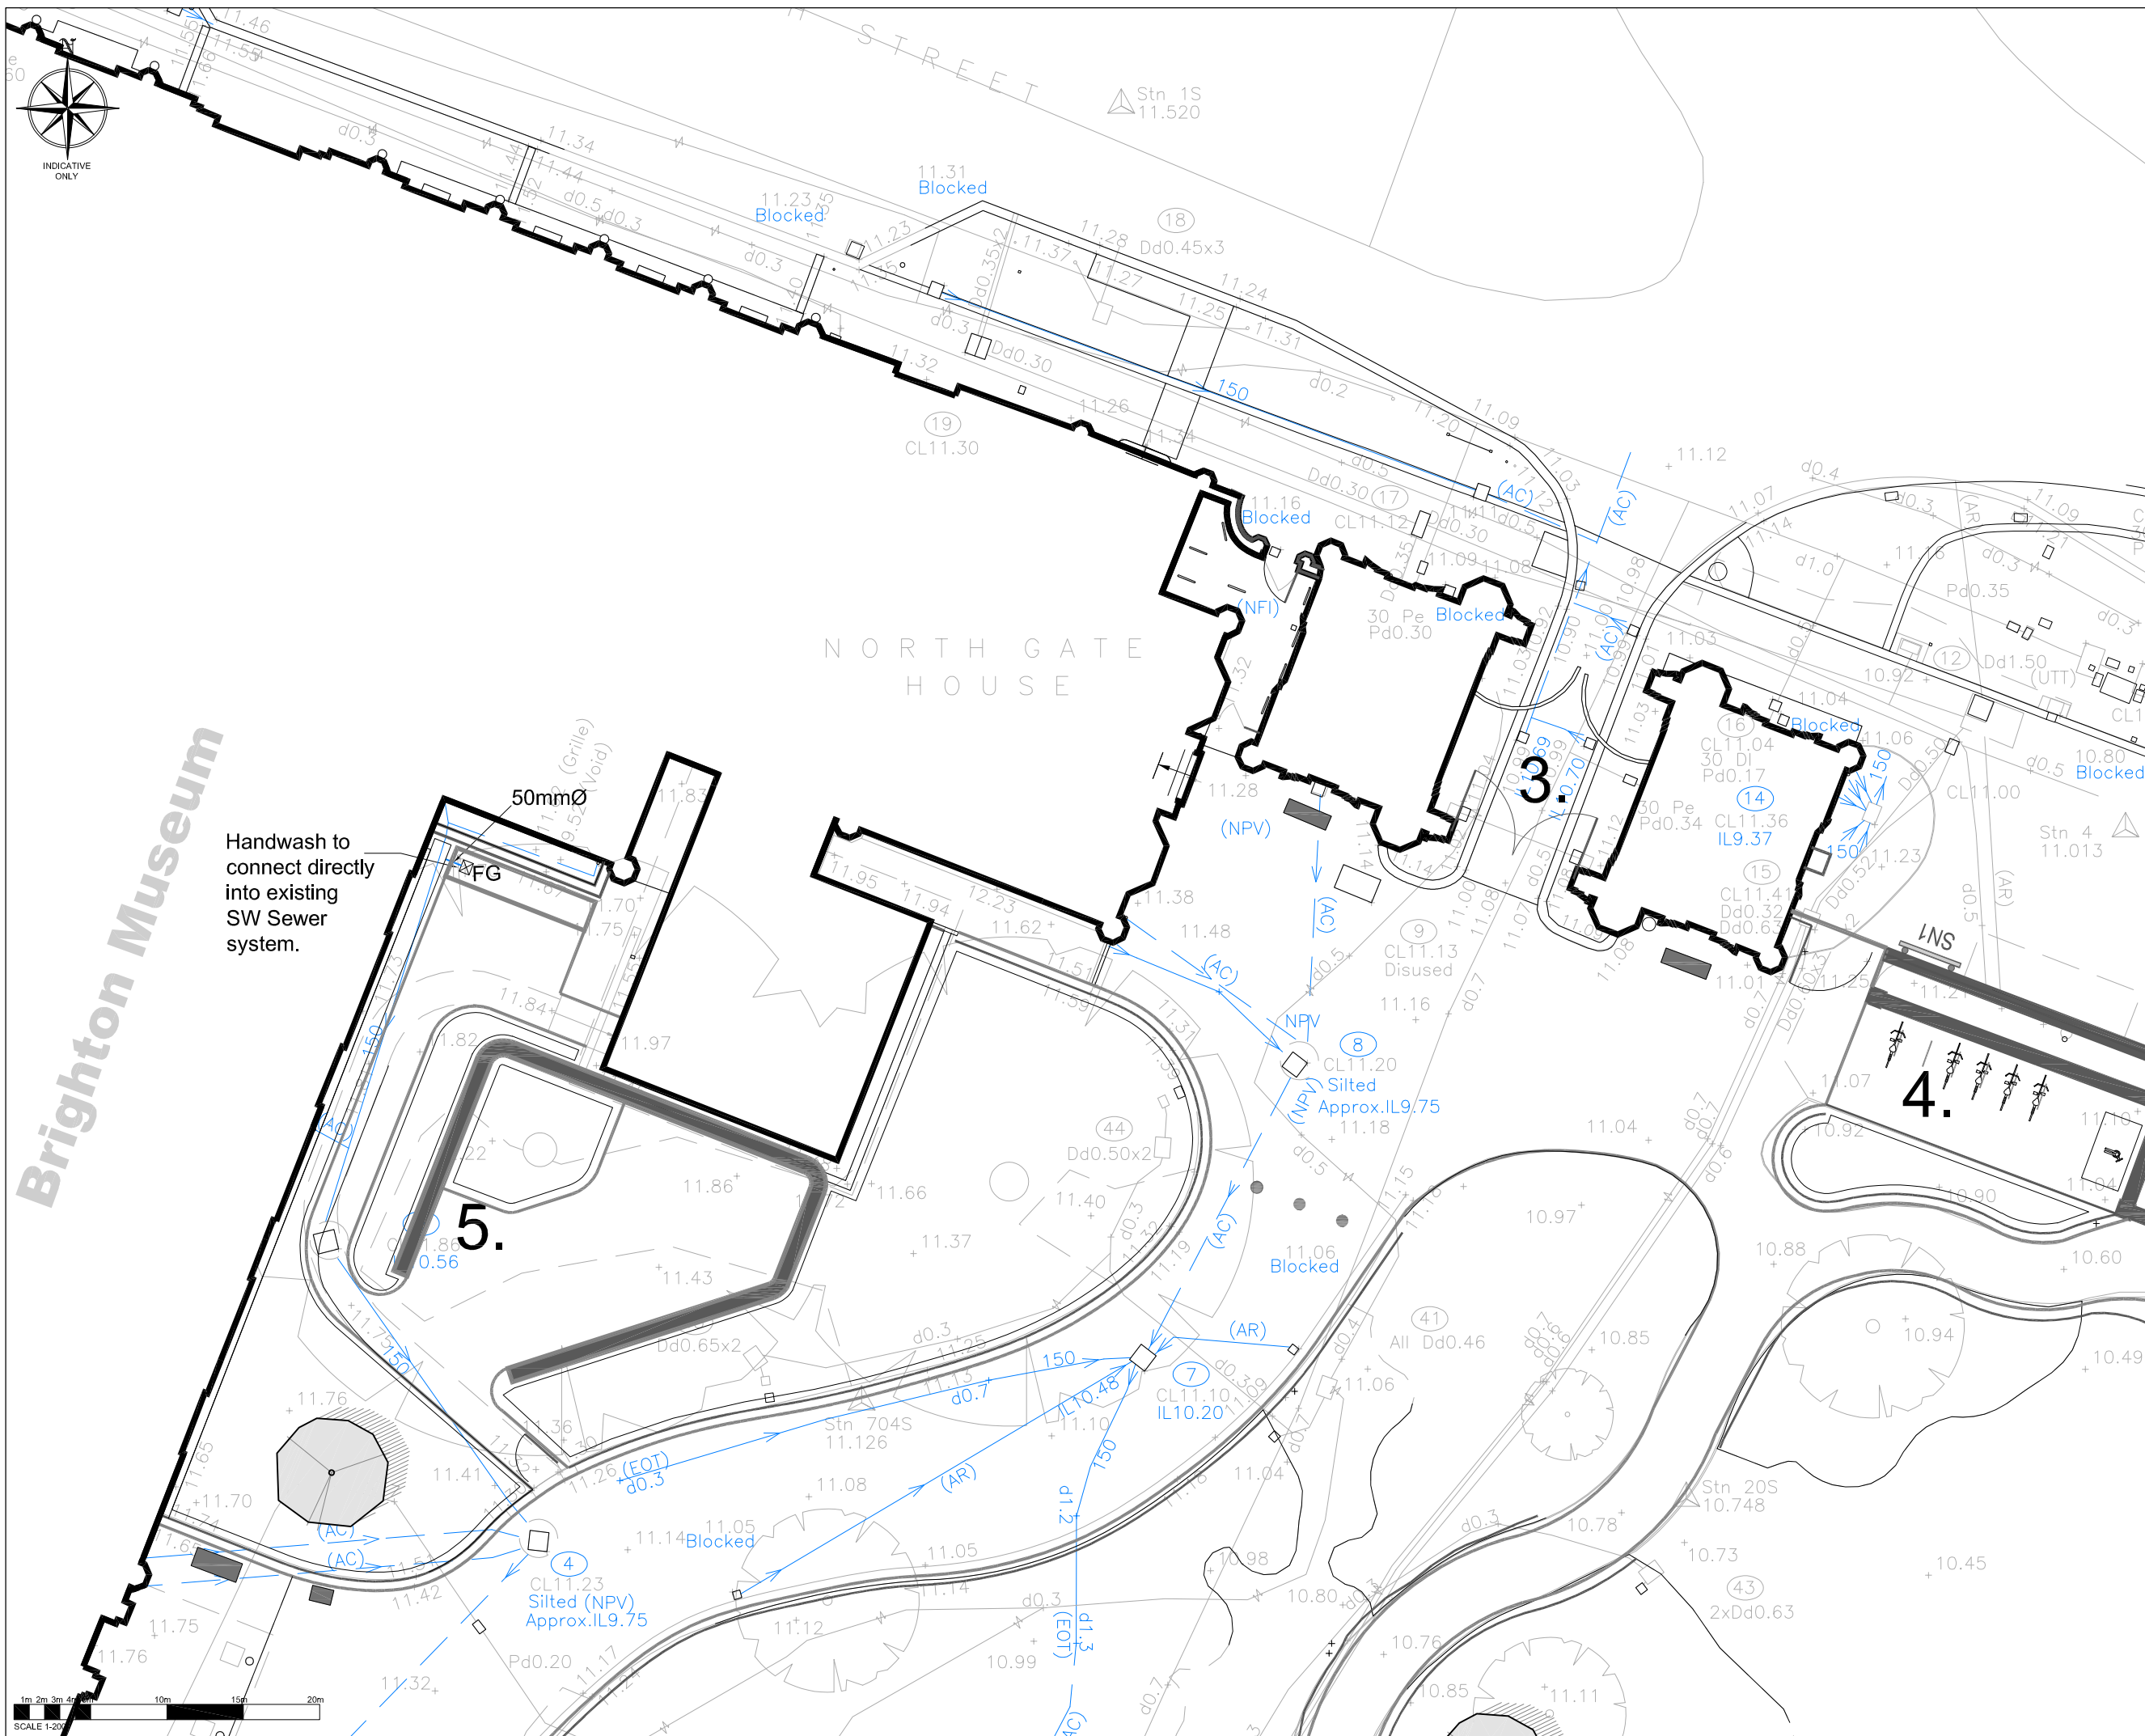

**Brighton Museum**

