


76 mm round upvc rainwater downpipe taken to new soakaway 5000 from any building in garden 1 metre below inver of pipe Crate system wrapped in Geo Tech type material

114 mm dia black upvc half round upvc guttering downpipe white upvc soffit & fascia guttering from rear connected to downpipe

895 x 1050 mm high grey double glazed upvc window

boundary fence to no 82 Keyes Road

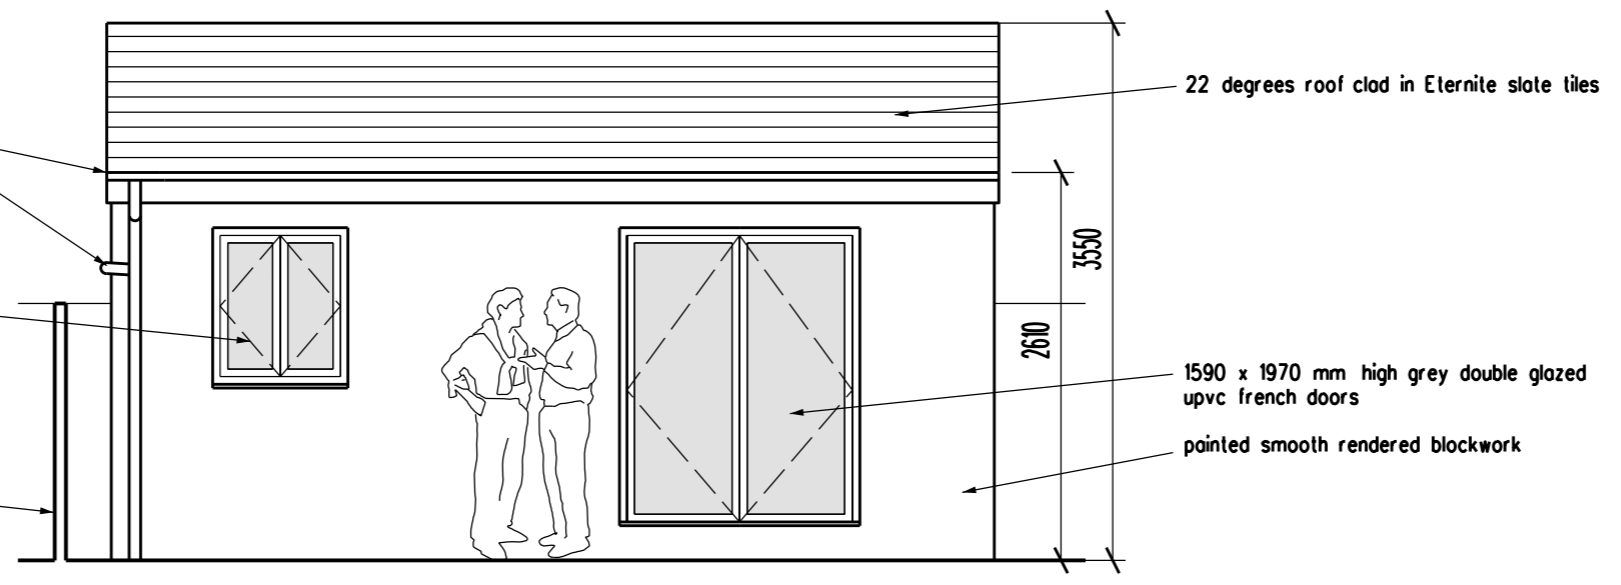

REVISION	DATE
ARCHITECT TA ARCHITECTS 11 JOYDENS WOOD ROAD BEXLEY KENT DA5 2HS Tel 07905 130591 ta140256@googlemail.com	
JOB RETENTION OF OUT BUILDING AT 82 KEYES ROAD DARTFORD KENT DA1 5EN	
DRAWING PROPOSED FLOOR PLAN AND ELEVATIONS	
SCALE 1:50 AT A3	DATE OCT 2023
DRAWING NO. BD/03	

