




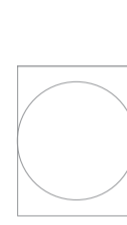


Note :- This drawing must not be scaled.
To be used for Planning Purposes only.



All Ensuite rooms to have MF drop ceilings with access panel for AC Unit maintenance.

KEY

-  DUCTED FAN COIL IN ROOM VOID
-  FLOW SELECTOR BOX IN ROOM VOID
-  DUCTED FAN COIL IN LOFT SPACE
-  FLOW SELECTOR BOX IN LOFT SPACE
-  ROOM CONTROLLER
-  VRF CONDENSING UNIT



First Floor

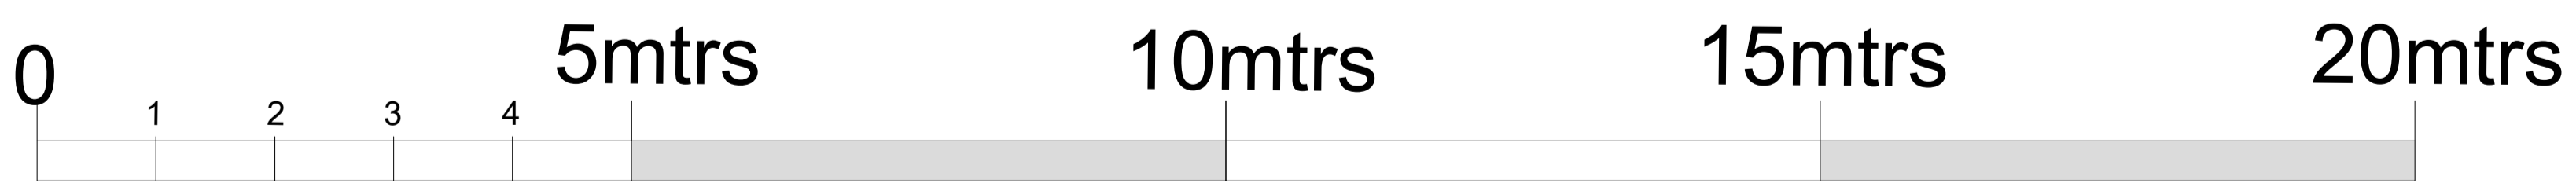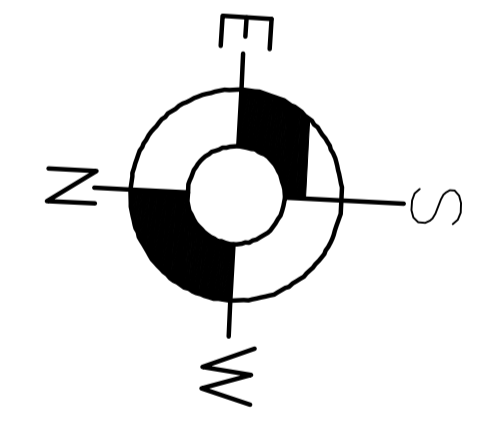

Scale bar .

- C. 23.10.23 - As requested by Planners Paper size added.
- B. 25.09.23 - Scale bar & North point added.
- A. Aug23 . AC Units and pipe runs added

Rev	Date

JACKDAW

Tel: 07919415895 or 07961104958
109 Sandridge Road
St Albans

CLIENT
Fuller Smith & Turner PLC

PROJECT
Planning.
Folly Bridge
Oxford, OX1 4LB

TITLE
Proposed First Floor Plan
Bedroom Plan

ISSUE
Planning.

Scale: 1:50@A1 Date: 2023 Drawn:	1063-05	C.
--	---------	----