 





Reproduced by permission of Ordnance Survey on behalf of the Controller of Her Majesty's Stationery Office All rights reserved. © Crown Copyright licence no. 0100031673

SITE AREA PLAN





SITE PHOTOGRAPH

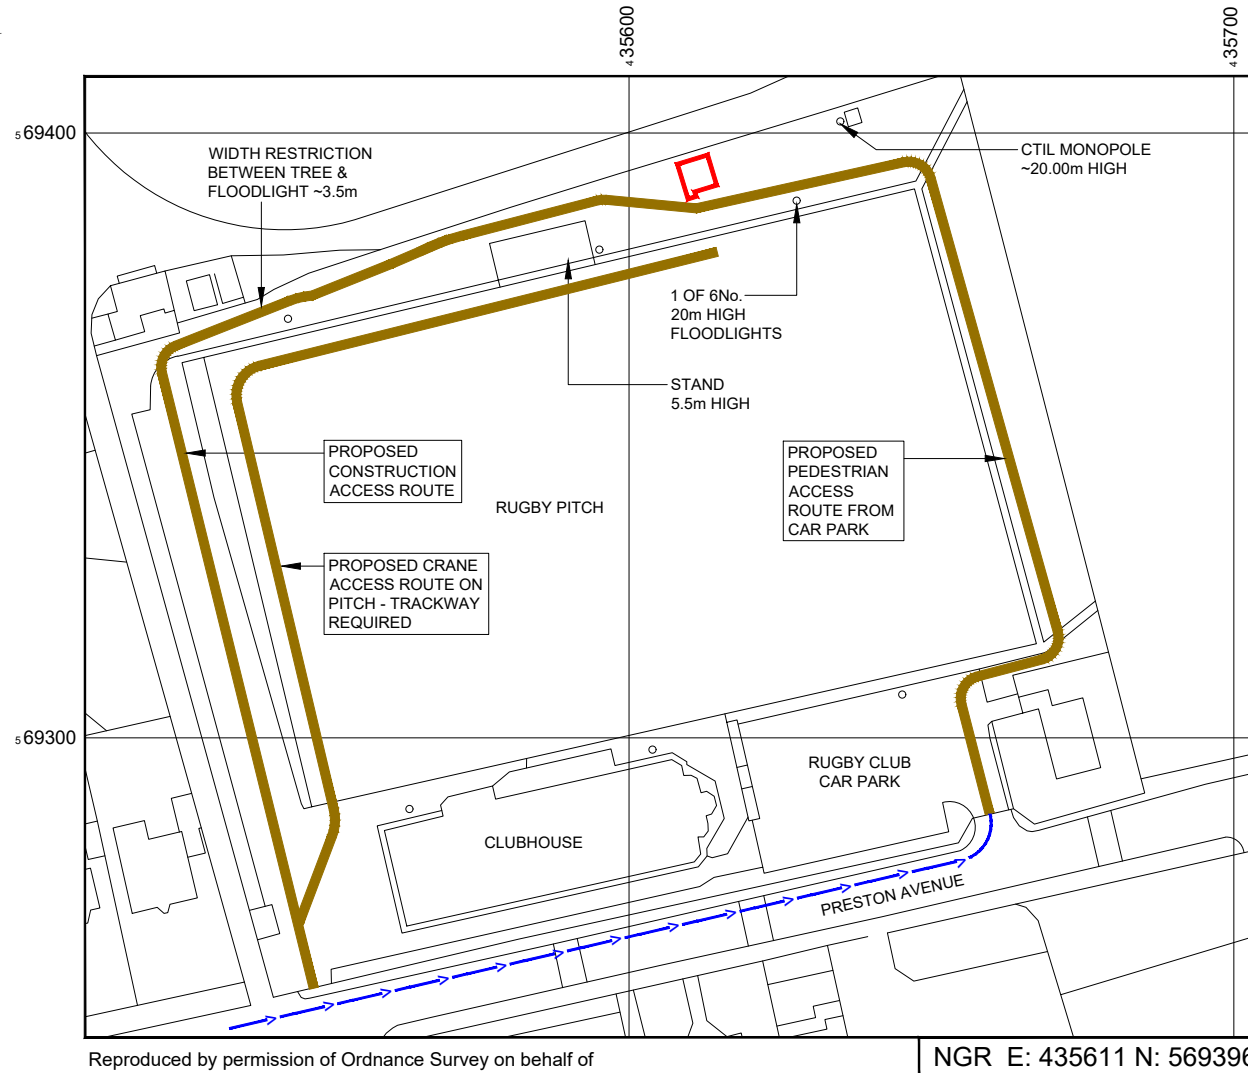

Reproduced by permission of Ordnance Survey on behalf of the Controller of Her Majesty's Stationery Office All rights reserved. © Crown Copyright licence no. 0100031673

NGR E: 435611 N: 569396

 SITE LOCATION PLAN

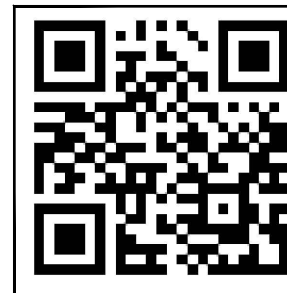

GOOGLE MAPS QR CODE

 
GOOGLE MAP - [Hyperlink to map of the site](#)

GOOGLE STREETVIEW - [Hyperlink to streetview of the site](#)

NOTES:

1. ALL DIMENSIONS IN MM UNLESS OTHERWISE NOTED.

DIRECTIONS TO SITE:



Master: M001	MBNL / EE / H3G	Project: NTQ	Purpose of Issue: Planning	Issue: A
Date: 23/10/2023	Drawn: J. HOWDEN	Revision / Upgrade Description: First Issue		
Checked: C. BARGE	Approved: M. NOEL			

Hutchison 3G UK Limited
Green Park
450 Longwater Avenue,
Reading,
RG30 3UR
Tel: 01628 765 000
H3G Base Station Information line:
0845 6043000
Available from 8pm Monday to Friday

Hatfield Business Park
Hatfield
Hertfordshire
AL10 9BW
Tel: 01707 315000
Fax: 01707 319001

Mobile Broadband Network Limited
Sixth Floor, Thames Tower, Station Road, Reading, RG1 1LX

Design Consultant & Principal Contractor:

Unit 27F-G
Hartlebury Trading Estate
Crown Lane
Hartlebury
Worcestershire
DY10 4JD

Site Name: PERCY PARK RUGBY CLUB

Site ID: 1716744

Address: PERCY PARK RUGBY CLUB,
PRESTON AVENUE,
NORTH SHIELDS,
TYNE AND WEAR,
NE30 2BE

Title: 002 SITE LOCATION PLAN


Project: NTQ

Purpose of Issue: GENERAL ARRANGEMENT

EE Cell ID: 96507	MBNL Cell ID: NTY097	3UK Cell ID: NE1188
-------------------	----------------------	---------------------

Master Drawing No: 1716744_96507_NTY097_NE1188_M001	Issue: A
---	----------

100mm
50mm
10mm

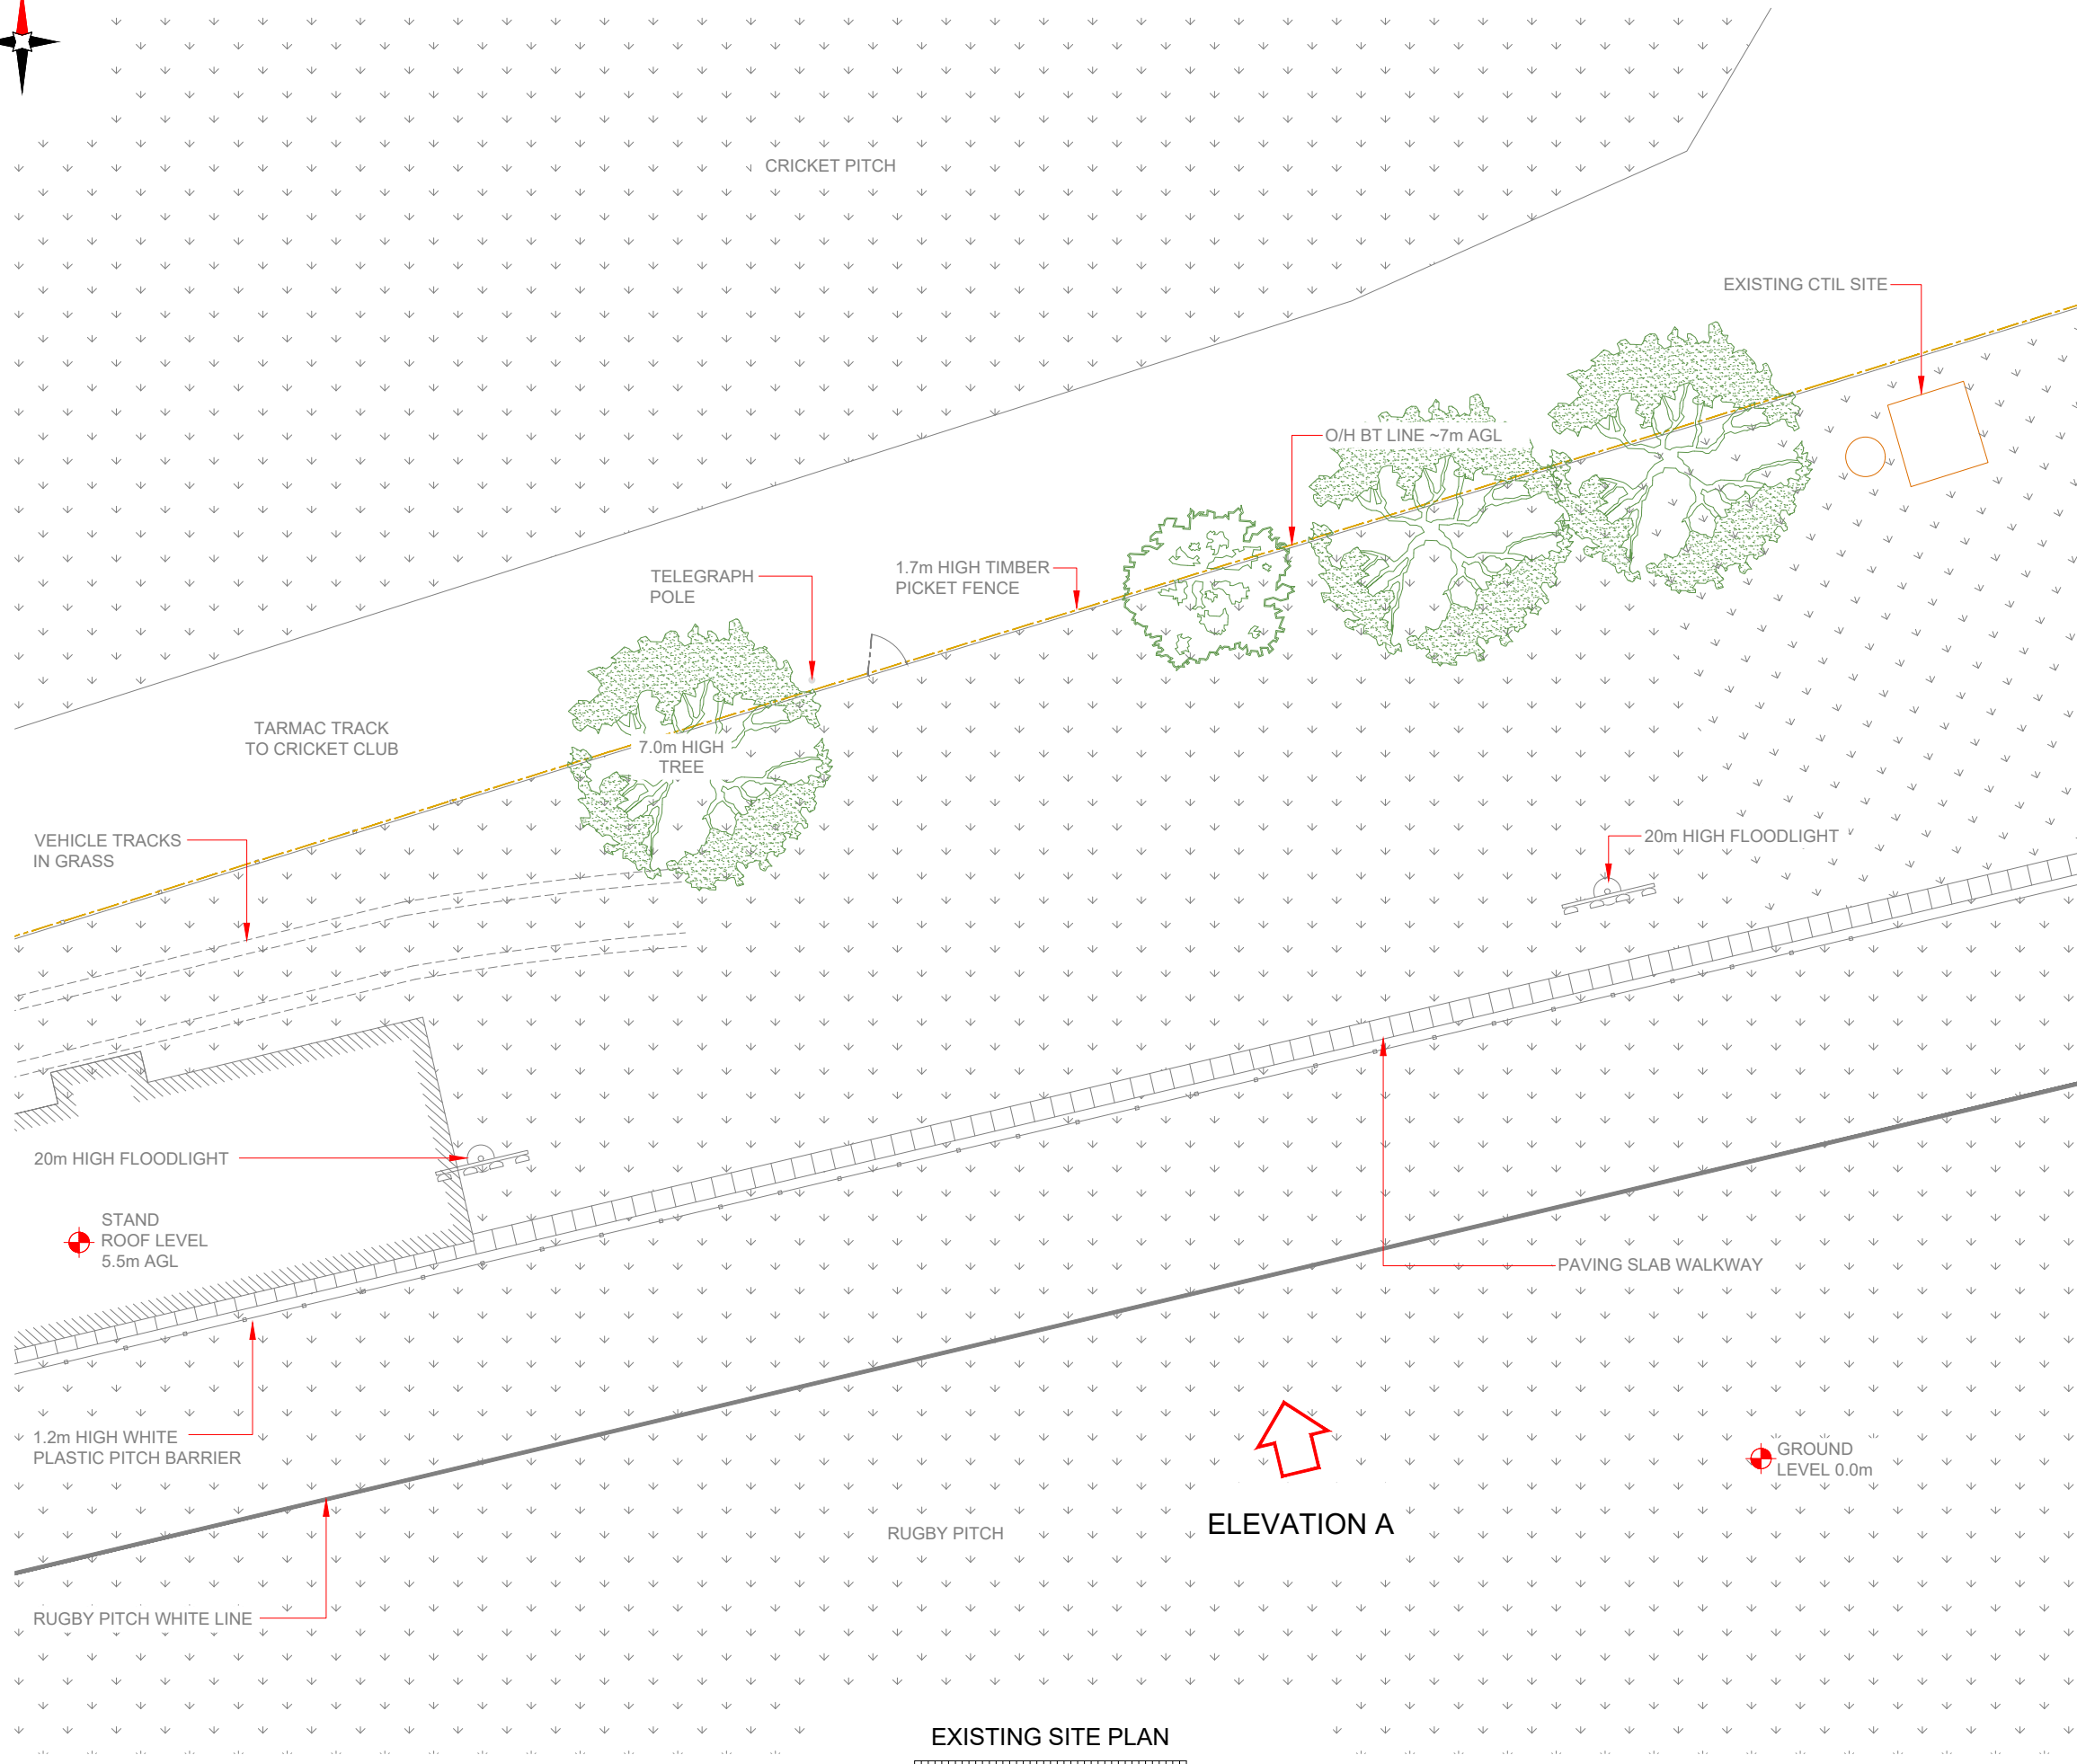

ELEVATION A

EXISTING SITE PLAN



NOTES:

- ALL DIMENSIONS IN MM UNLESS OTHERWISE NOTED.

Master:	MBNL / EE / H3G:	Project:	Purpose of Issue:	Issue:
M001	MBNL	NTQ	Planning	A
Date:	23/10/2023	Revision / Upgrade Description:		
Drawn:	J. HOWDEN	First Issue		
Checked:	C. BARGE			
Approved:	M. NOEL			



Hutchison 3G UK Limited
Green Park
450 Longwater Avenue,
Reading,
RG30 3UR
Tel: 01628 765 000
H3G Base Station Information line:
0845 6043000
Available from 8pm Monday to Friday



Hatfield Business Park
Hatfield
Hertfordshire
AL10 9BW
Tel: 01707 315000
Fax: 01707 319001



Mobile Broadband Network Limited
Sixth Floor, Thames Tower, Station Road, Reading, RG1 1LX

Design Consultant & Principal Contractor:



Unit 27F-G
Hartlebury Trading Estate
Crown Lane
Hartlebury
Worcestershire
DY10 4JD

Site Name:

PERCY PARK RUGBY CLUB

Site ID:

1716744

Address:

PERCY PARK RUGBY CLUB,
PRESTON AVENUE,
NORTH SHIELDS,
TYNE AND WEAR,
NE30 2BE

Title:

100 EXISTING SITE PLAN

Project:

NTQ

Purpose of Issue:

GENERAL ARRANGEMENT

EE Cell ID:
96507

MBNL Cell ID:
NTY097


3UK Cell ID:
NE1188

Master Drawing No:

1716744_96507_NTY097_NE1188_M001

Issue:

A

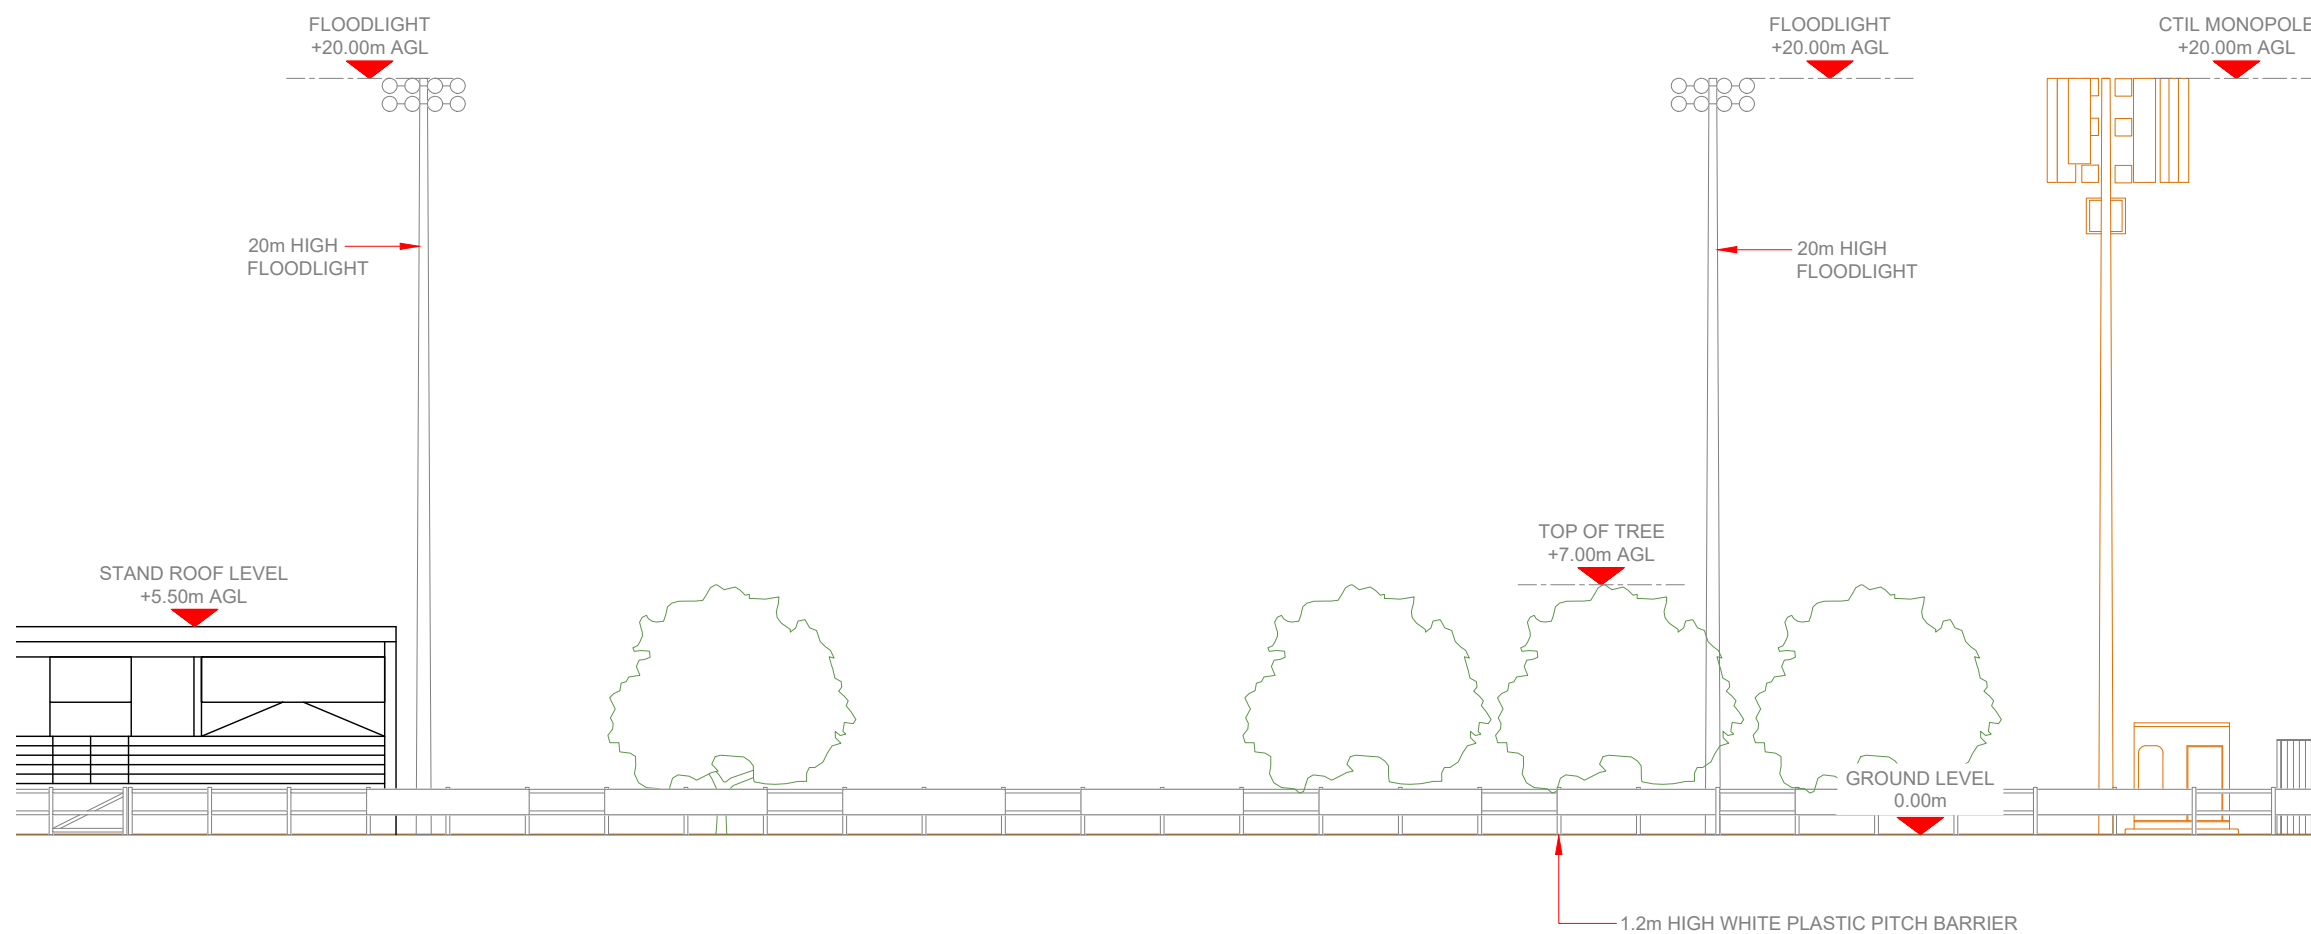

EXISTING ELEVATION A



NOTES:

1. ALL DIMENSIONS IN MM UNLESS OTHERWISE NOTED.

Master:	MBNL / EE / H3G:	Project:	Purpose of Issue:	Issue:
M001	MBNL	NTQ	Planning	A
Date:	23/10/2023	Revision / Upgrade Description:		
Drawn:	J. HOWDEN	First Issue		
Checked:	C. BARGE			
Approved:	M. NOEL			

<p>Hutchison 3G UK Limited Green Park 450 Longwater Avenue, Reading, RG30 3LR Tel: 01628 765 000 H3G Base Station Information line: 0845 6043000 Available 8am-8pm Monday to Friday</p>	<p>Hatfield Business Park Hatfield Hertfordshire AL10 9BW Tel: 01707 315000 Fax: 01707 319001</p>

Design Consultant & Principal Contractor:

Unit 27F-G
Hartlebury Trading Estate
Crown Lane
Hartlebury
Worcestershire
DY10 4JD

Site Name: **PERCY PARK RUGBY CLUB**

Site ID: **1716744**

Address: **PERCY PARK RUGBY CLUB,
PRESTON AVENUE,
NORTH SHIELDS,
TYNE AND WEAR,
NE30 2BE**

Title: **150 EXISTING ELEVATION**

Project: **NTQ**

Purpose of Issue: **GENERAL ARRANGEMENT**

EE Cell ID:	MBNL Cell ID:	3UK Cell ID:
96507	NTY097	NE1188


Master Drawing No: **1716744_96507_NTY097_NE1188_M001** Issue: **A**



NOTE:
VEHICULAR ACCESS ROUTE BEHIND STAND
IS TO BE MAINTAINED FOR EMERGENCY
VEHICLES I.E. AMBULANCE ON MATCH DAYS

Antenna Aperture ID	Proposed 4G/5G Bearing	Operator: Shared/EE/H3G
A1	0°	EE
A2	0°	H3G
B1	120°	EE
B2	120°	H3G
C1	240°	EE
C2	240°	H3G

NOTES:
1. ALL DIMENSIONS IN MM UNLESS OTHERWISE NOTED.

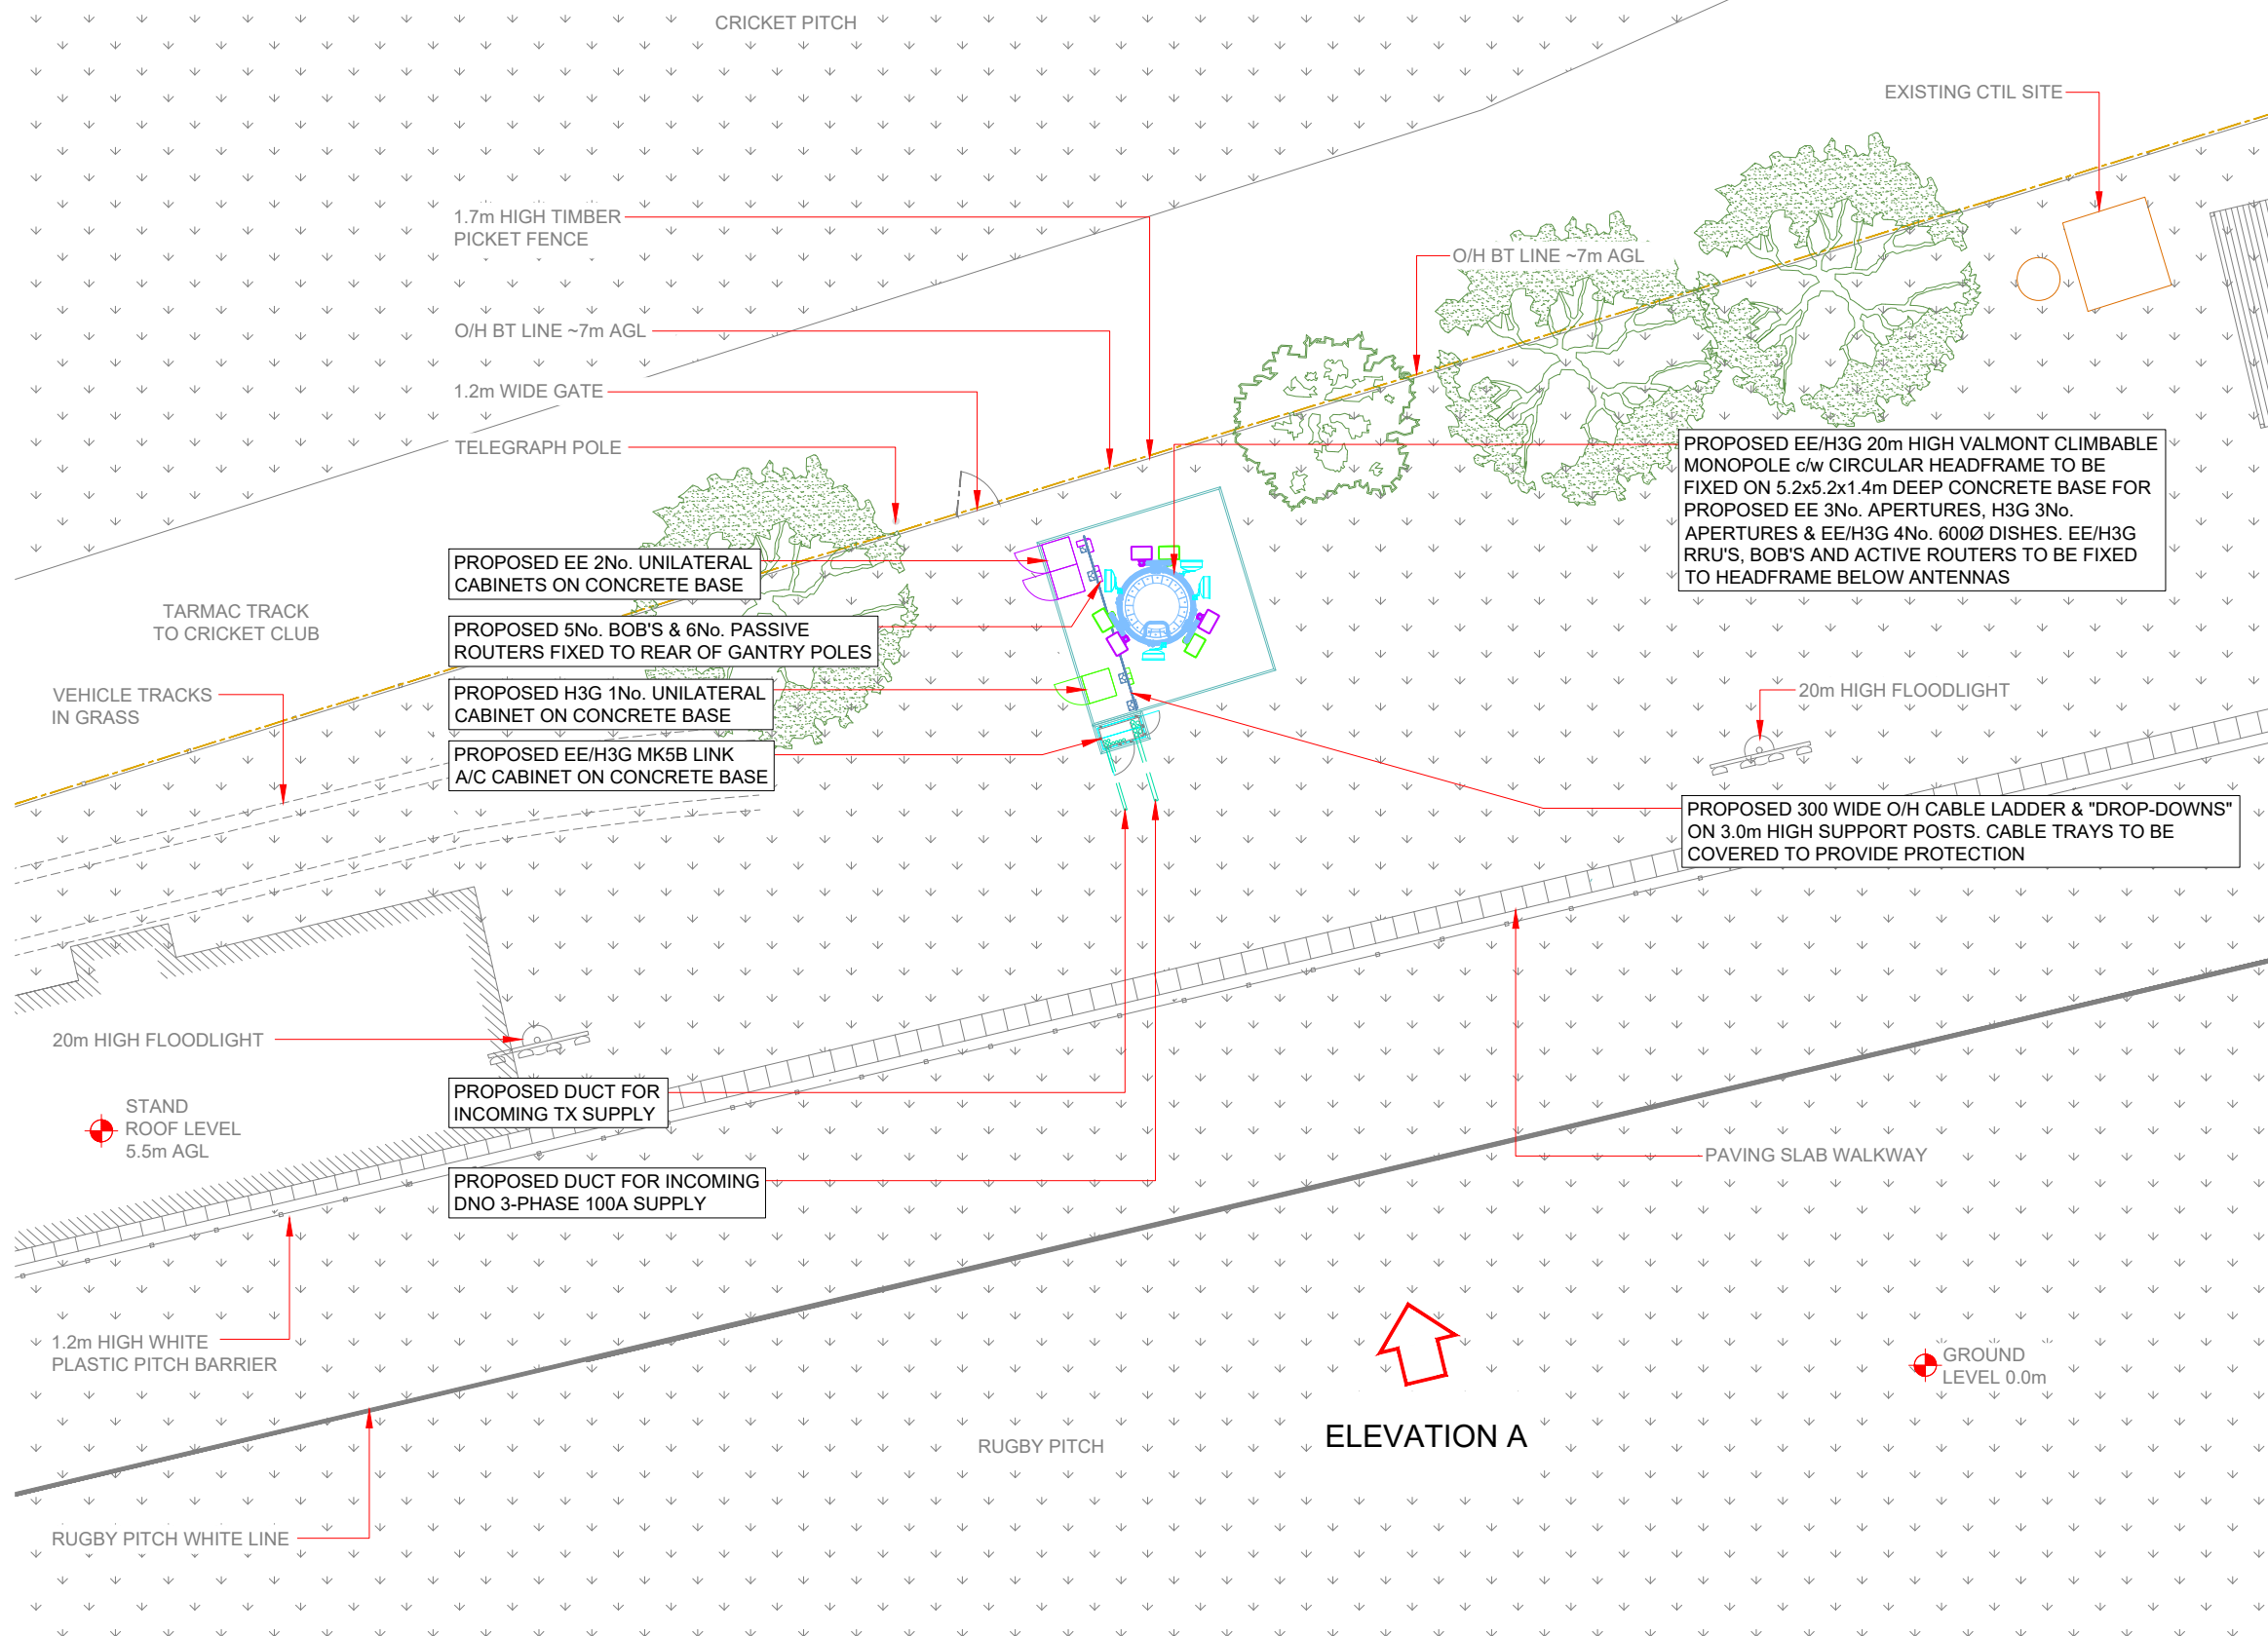

PROPOSED MAX CONFIGURATION SITE PLAN



Master: M001	MBNL / EE / H3G	Project: NTQ	Purpose of Issue: Planning	Issue: A
Date: 23/10/2023	Drawn: J. HOWDEN	Revision / Upgrade Description: First Issue		
Checked: C. BARGE	Approved: M. NOEL			

3 Hutchison 3G UK Limited
Green Park
450 Longwater Avenue,
Reading
RG30 3UR
Tel: 01628 768 000
H3G Base Station Information Line:
0845 6043000
Available from 9pm Monday to Friday

8 Hatfield Business Park
Hatfield
Hertfordshire
AL10 9BW
Tel: 01707 315000
Fax: 01707 319001

MBNL Mobile Broadband Network Limited
Sixth Floor, Thames Tower, Station Road, Reading, RG1 1LX

Design Consultant & Principal Contractor:

circet UK

Unit 27F-G
Hartlebury Trading Estate
Crown Lane
Hartlebury
Worcestershire
DY10 4JD

Site Name: PERCY PARK RUGBY CLUB

Site ID: 1716744

Address: PERCY PARK RUGBY CLUB,
PRESTON AVENUE,
NORTH SHIELDS,
TYNE AND WEAR,
NE30 2BE

Title: 215 MAX CONFIGURATION SITE PLAN

Project: NTQ

Purpose of Issue: GENERAL ARRANGEMENT

EE Cell ID: 96507	MBNL Cell ID: NTY097	3UK Cell ID: NE1188
-----------------------------	--------------------------------	-------------------------------

Master Drawing No: 1716744_96507_NTY097_NE1188_M001 Issue: A

Antenna Aperture ID	Proposed 4G/5G Bearing	Operator: Shared/ EE/H3G
A1	0°	EE
A2	0°	H3G
B1	120°	EE
B2	120°	H3G
C1	240°	EE
C2	240°	H3G

NOTES:
1. ALL DIMENSIONS IN MM UNLESS OTHERWISE NOTED.

Master: M001	MBNL / EE / H3G:	Project: NTQ	Purpose of Issue: Planning	Issue: A
Date: 23/10/2023	Drawn: J. HOWDEN	Revision / Upgrade Description: First Issue		
Checked: C. BARGE	Approved: M. NOEL			

 <p>Hutchison 3G UK Limited Green Park 450 Longwater Avenue, Reading, RG30 3LR Tel: 01628 765 000 H3G Base Station Information line: 0845 6043000 Available 8am-8pm Monday to Friday</p>	 <p>Hatfield Business Park Hatfield Hertfordshire AL10 9BW Tel: 01707 315000 Fax: 01707 319001</p>
---	---

MBNL Mobile Broadband Network Limited
Sixth Floor, Thames Tower, Station Road, Reading, RG1 1LX

Design Consultant & Principal Contractor:



Unit 27F-G
Hartlebury Trading Estate
Crown Lane
Hartlebury
Worcestershire
DY10 4JD

Site Name: **PERCY PARK RUGBY CLUB**

Site ID: **1716744**

Address: **PERCY PARK RUGBY CLUB,
PRESTON AVENUE,
NORTH SHIELDS,
TYNE AND WEAR,
NE30 2BE**


Title: **265 MAX CONFIGURATION ELEVATION**

Project: **NTQ**

Purpose of Issue: **GENERAL ARRANGEMENT**

EE Cell ID: 96507	MBNL Cell ID: NTY097	3UK Cell ID: NE1188
-----------------------------	--------------------------------	-------------------------------

Master Drawing No: **1716744_96507_NTY097_NE1188_M001** Issue: **A**

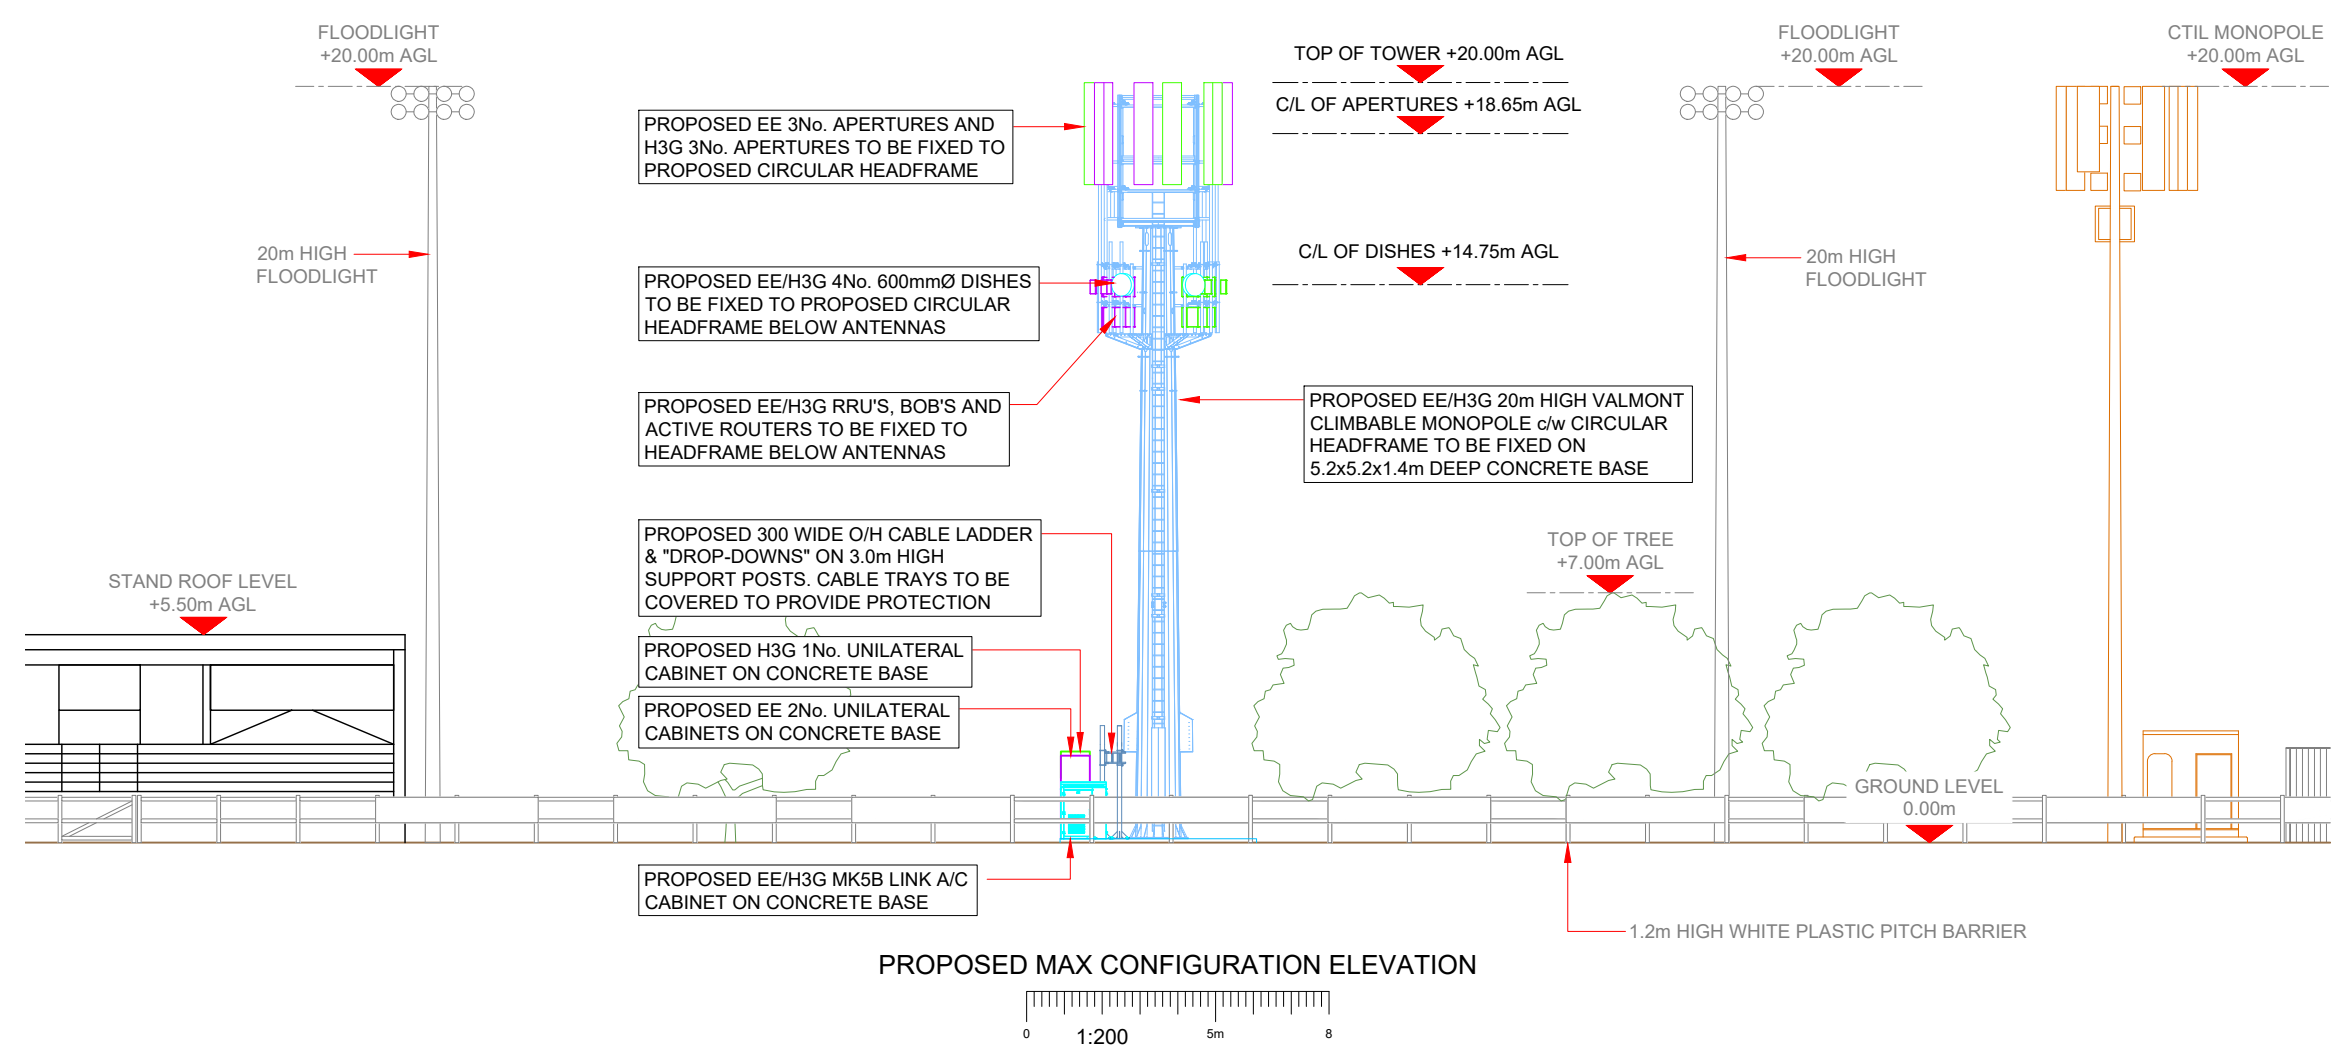

100mm
50mm
10mm