



All drawings are to be read in conjunction with specification and all other drawings that relate to this house type.
 All notes refer to all drawings of this house type.
 Electrical layout is schematic - Completed installation to comply with I.E.E regs & all relevant codes of practices.
 Electrical components fit to comply with approved part M.
 Do not scale from this drawing. Brightline Design to be notified of any discrepancies
 Verify relevant dimensions on site before commencing work or preparation shop drawings. This Drawing is copyright.

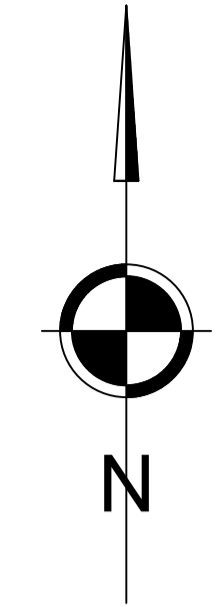

 Area of Planted Trees

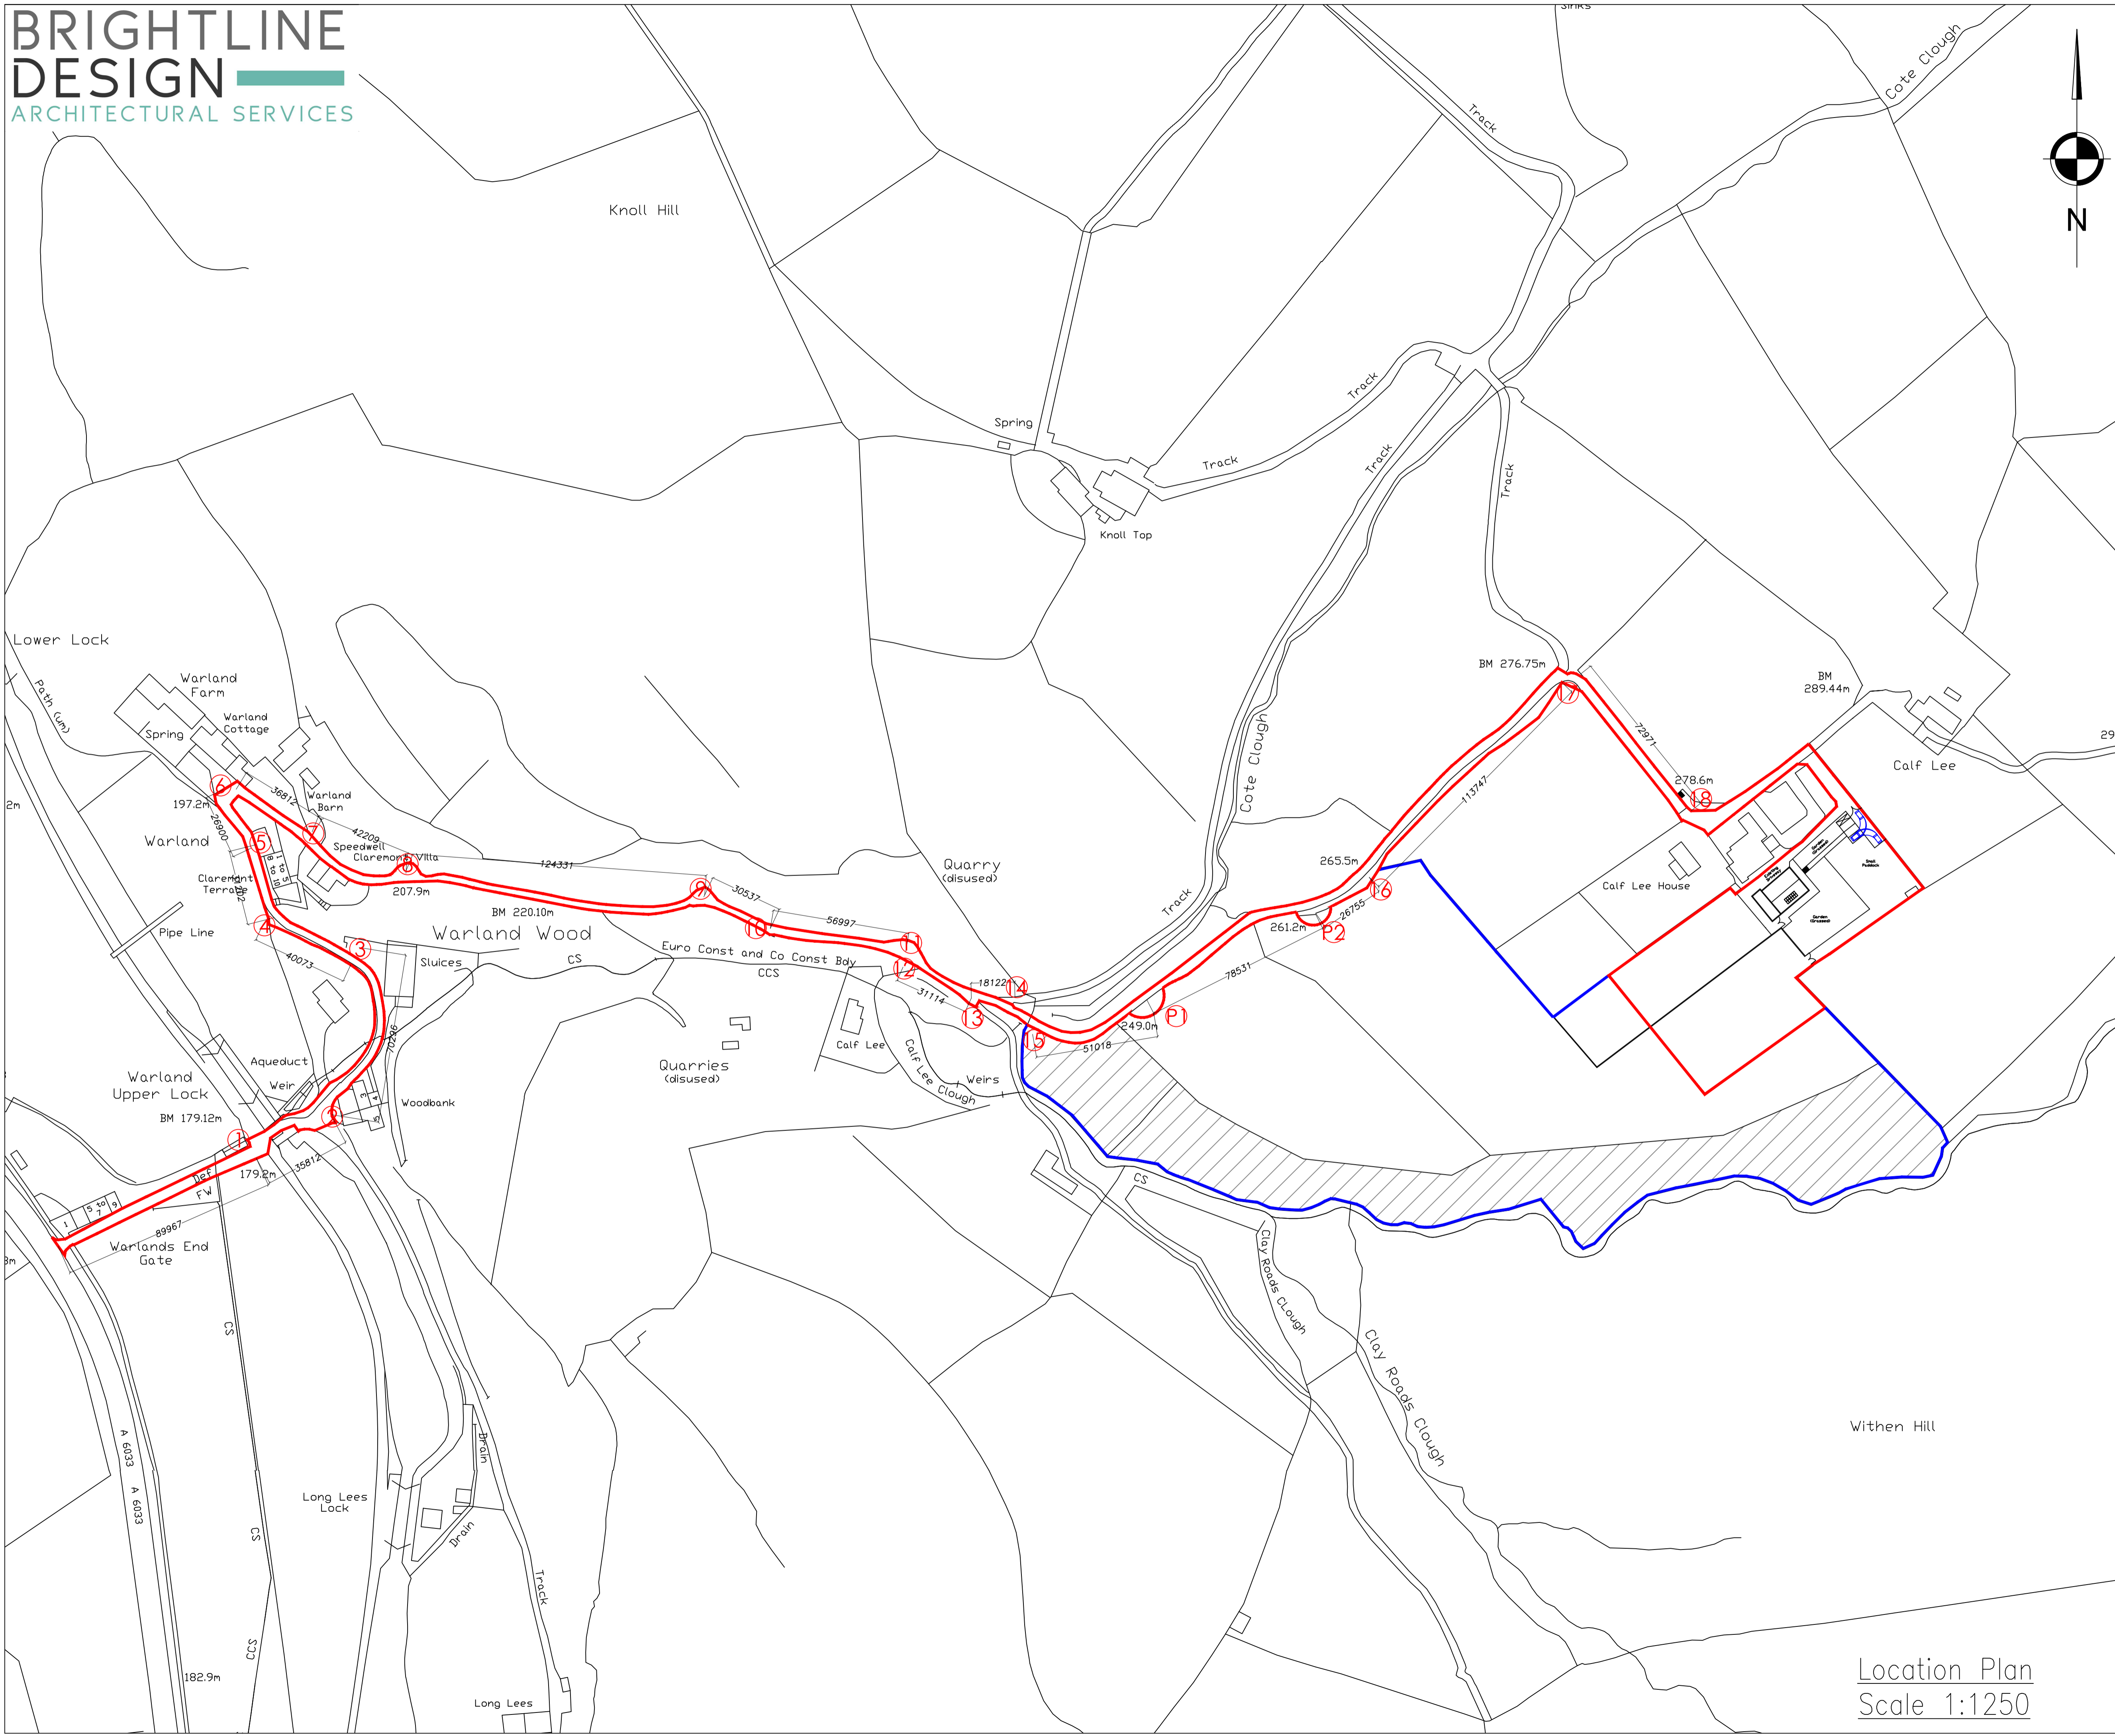

5 Sunnybank Road, Greetland, Halifax
 HX4 8JP
 Telephone - 07590 677 717/
 Email - info@brightlinedesign.co.uk
 Web: www.brightlinedesign.co.uk

Client
Mr P Frain

Project
Calf Lee Barn

Drawing
Overall Site Plan

Scale 1:1250@A1	Date JUN23	Drawn R.FOSTER
Drawing No. 23-023-08	Checked by J.WHIPPS	Revision -



Barn Conversion • Loft Conversion • Basement Conversion
 New Build • Extension
 Refurbishments • Domestic Work

Location Plan
 Scale 1:1250