
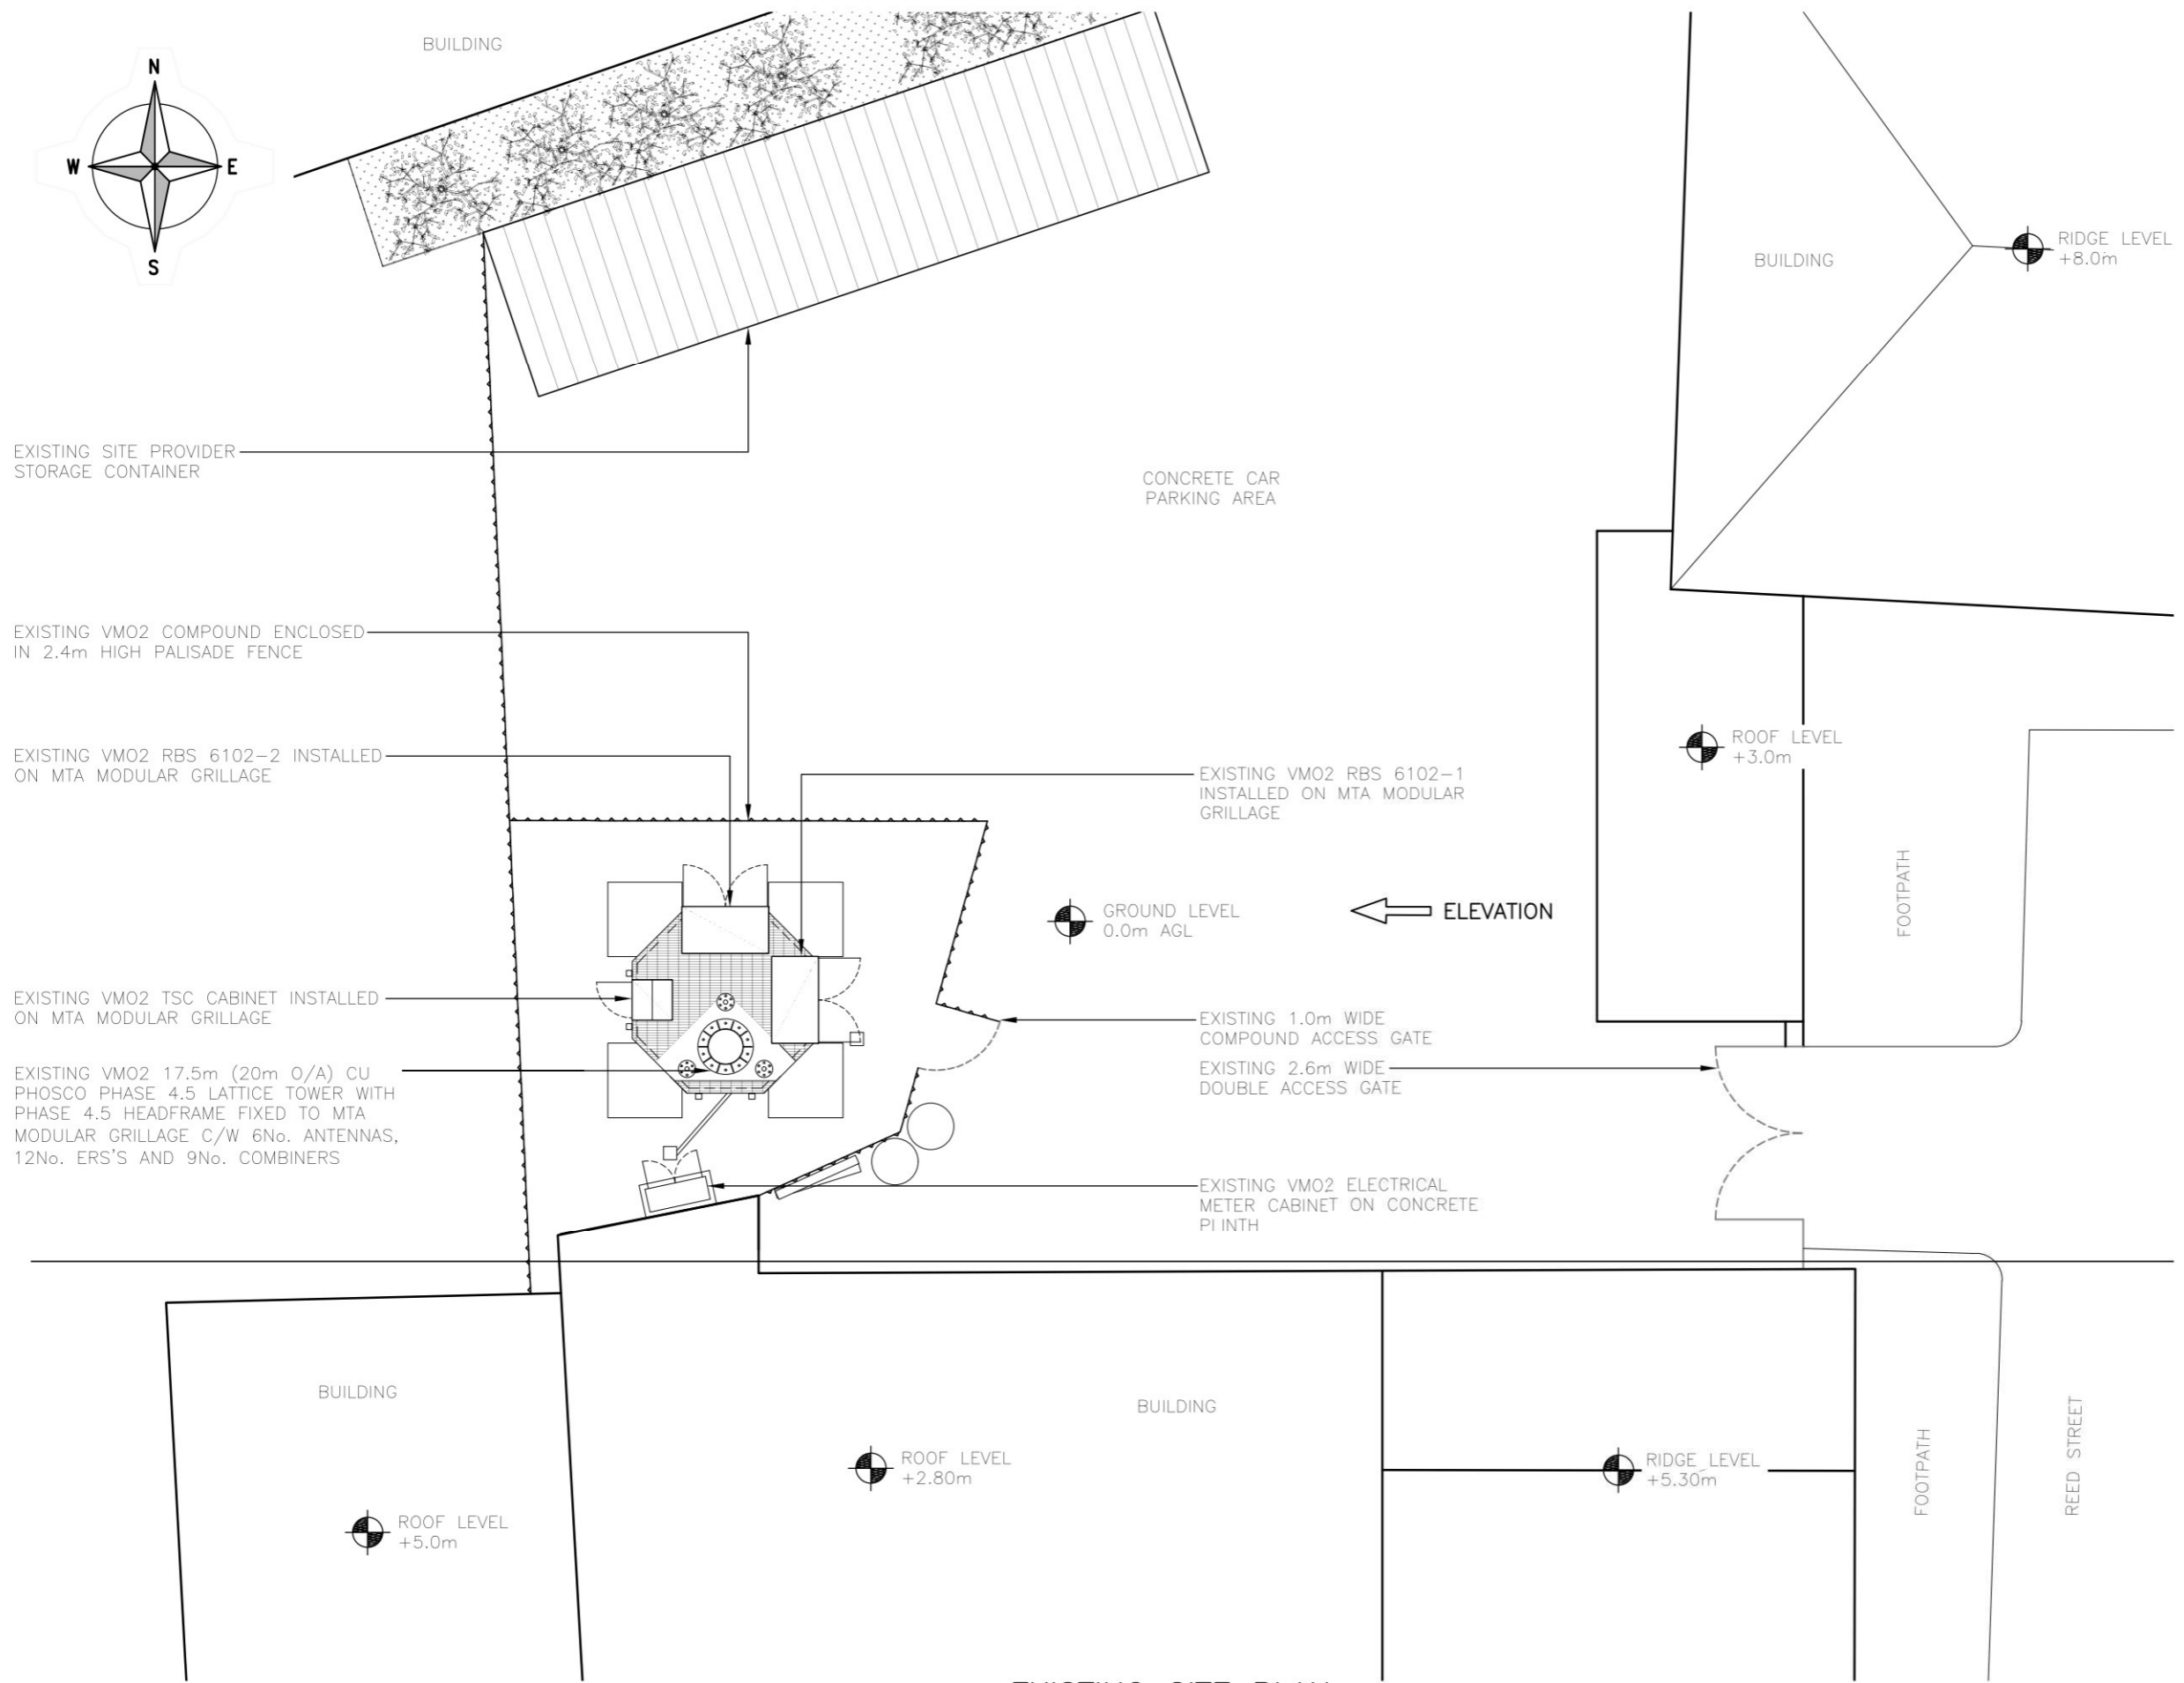


ALL DIMENSIONS ARE IN mm UNLESS NOTED OTHERWISE


N.G.R | E: 445394 N: 518312

NOTES:

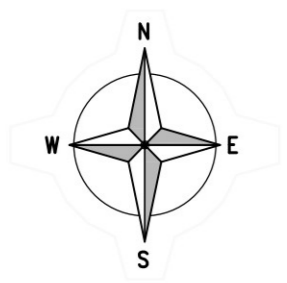

EXISTING SITE PLAN

 (1:100)



ORIGINAL SCALE AT A3 - 1:100

ALL DIMENSIONS IN MILLIMETRES

REV	MODIFICATION	BY	CH	DATE
A	Issued for Approval	JL	RB	15.07.21

CLARKE telecom
 Unit E, Madison Place, Northampton Road,
 Manchester, M40 5AG
 Tel: 0161 785 2000
 Fax: 0161 785 2001
 Web: www.clarke-telecom.com

O₂
 CORNERSTONE - BEACON 3

Cell Name	YARD OF TEKNIC	Opt.	A
Cell ID No	CORNERSTONE VMO2 VF		
	11737424	070704	N/A

Site Address / Contact Details
 YARD OF TEKNIC
 BON LEA TRADING ESTATE
 THORNABY
 CLEVELAND
 TS17 7AH

Drawing Title: EXISTING SITE PLAN			
Purpose of issue: PLANNING			Dwg Rev: A
Drawing Number: 200			A
Surveyed By: PW	Original Sheet Size: A3	Pack Issue:	
Drawn: JL	Date: 15.07.21	Checked: RB	Date: 15.07.21
			D