
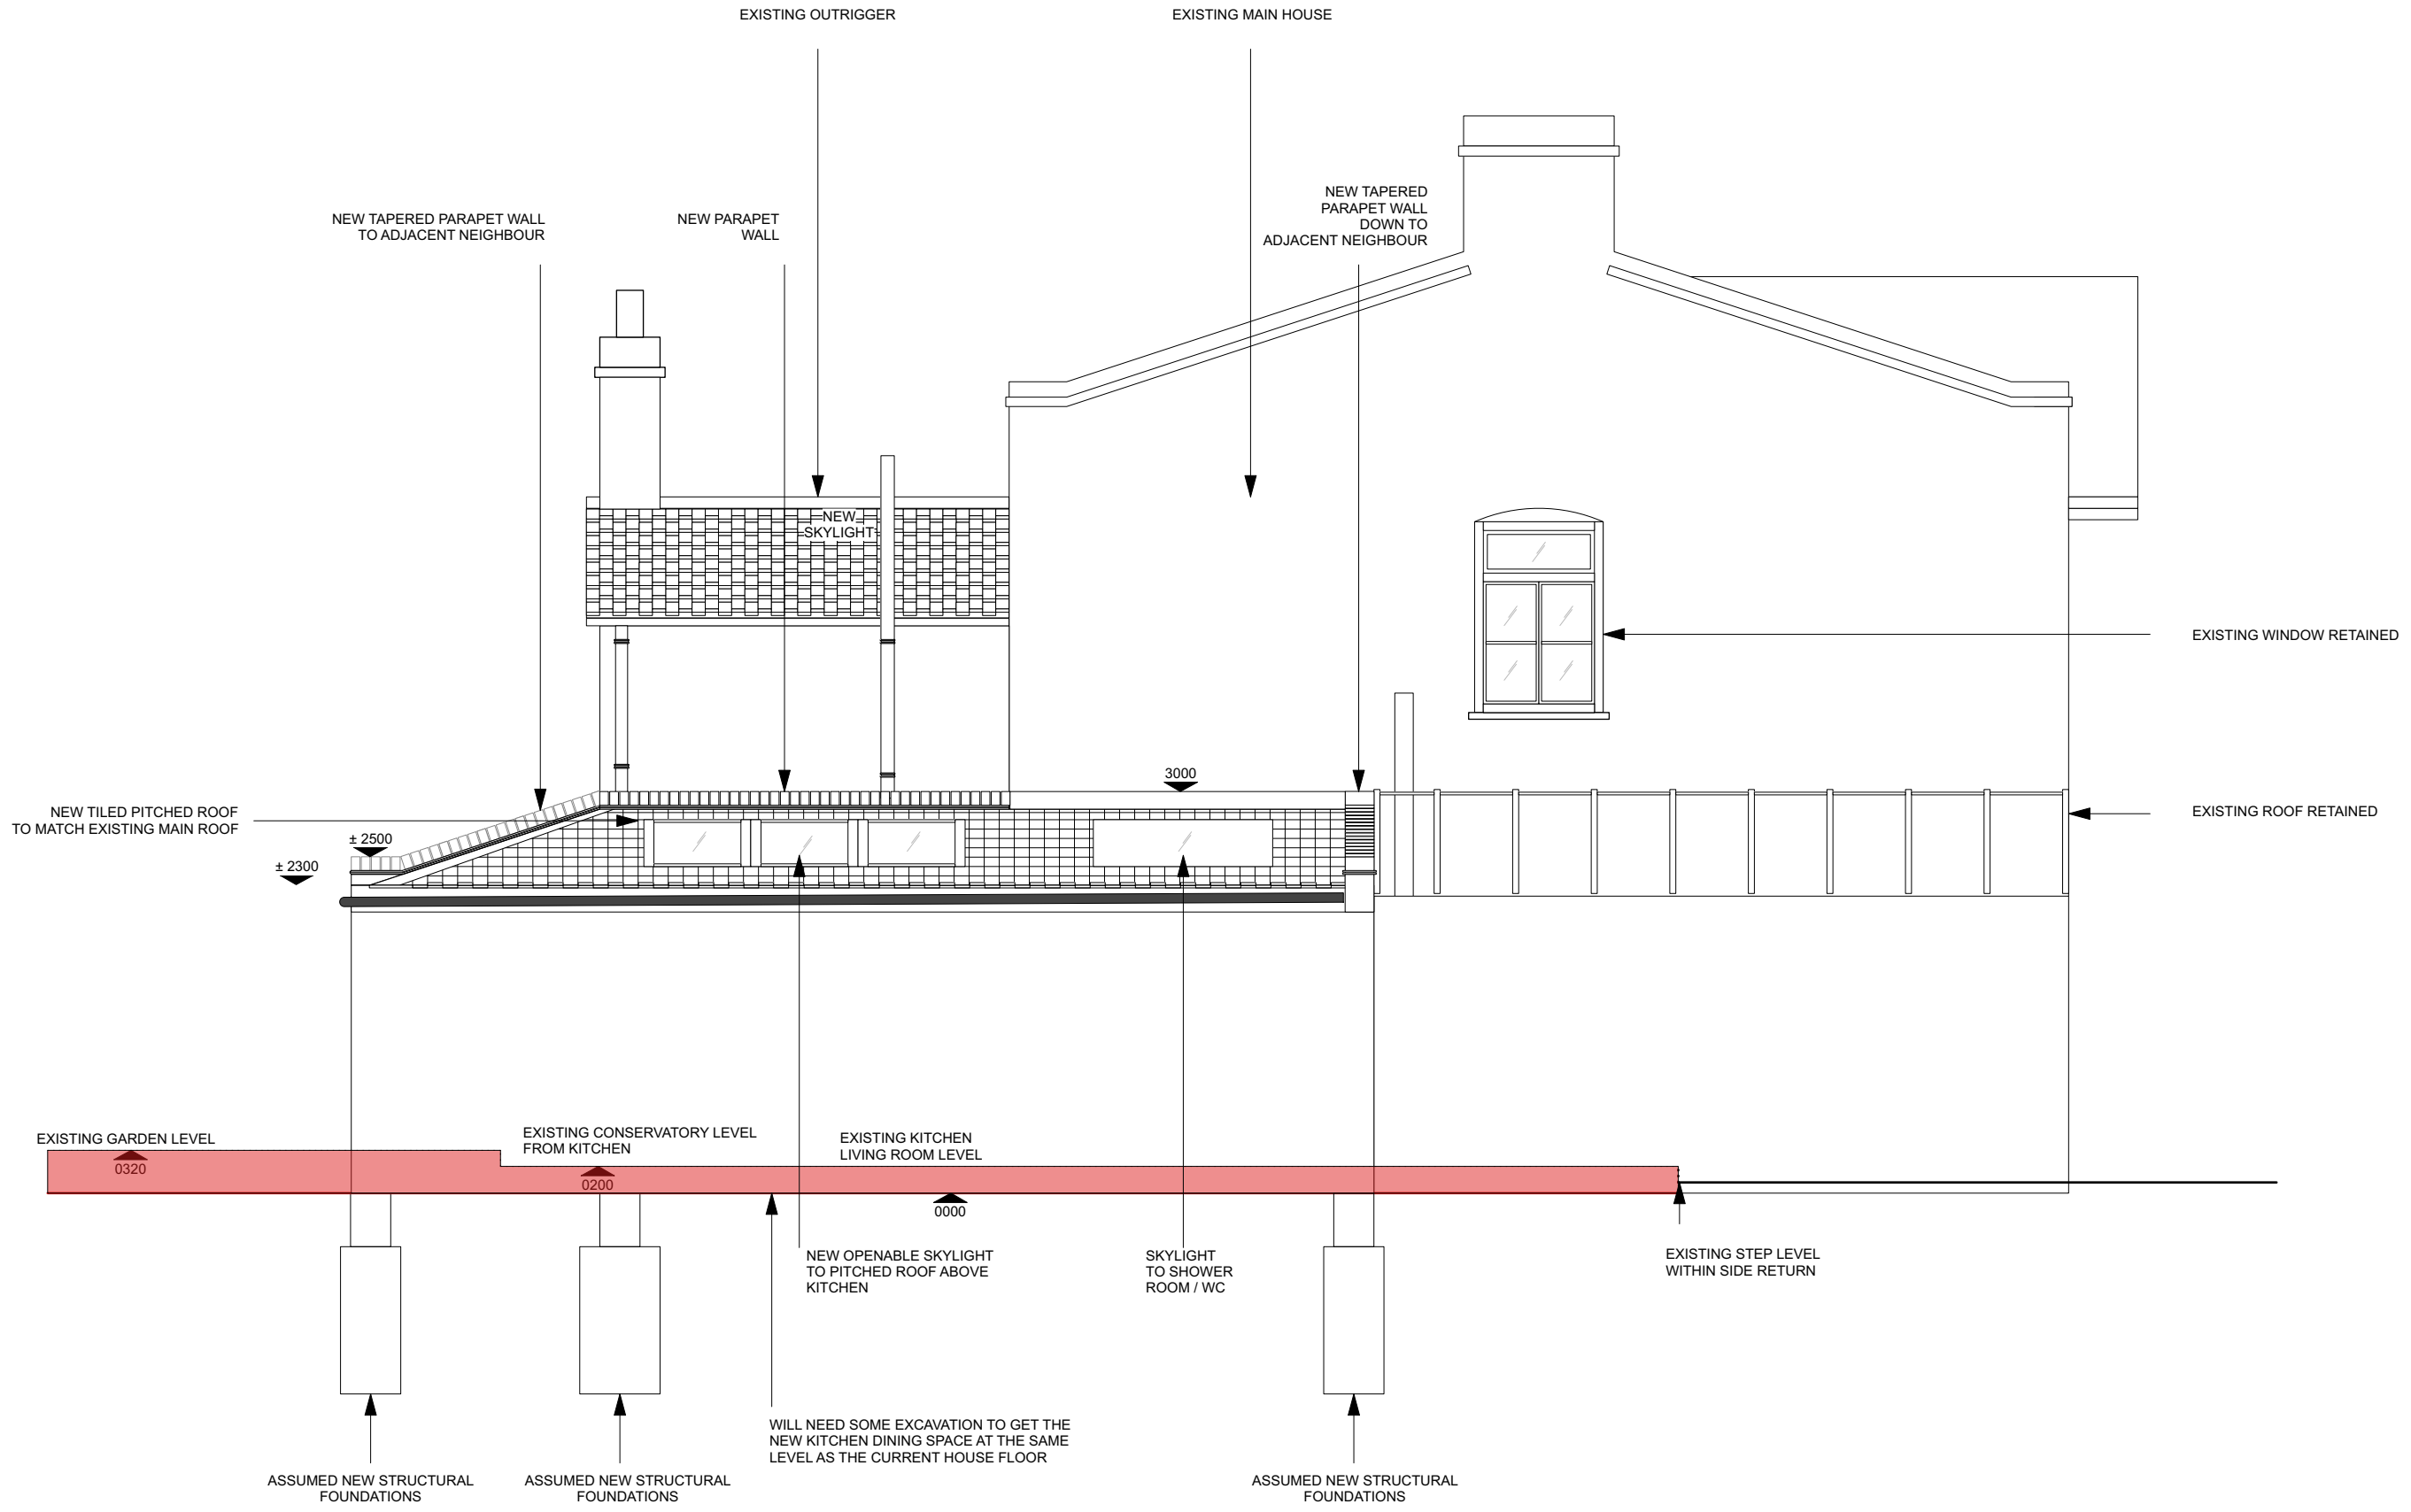


**Notes**

General notes: - design intent

- 01. Drawings indicate design intent only. The execut architect/contractor & relevant consultants & /or sub-contractors ensure all current building regulations, standards, & oth statutory requirements, codes of practice and landio requirements are implemented with design development construction.
- 02. All dimensions to be checked on site. The execut architect/contractor is to produce full set out drawings prior construction for RRS approval.
- 03. Read in conjunction with RRS Finishes Joinery, Fixtures ar Prototype Schedules which supersedes any notes contain within this drawing. Any discrepancies to be reported immediate prior to finishes being applied.
- 04. Contractor to supply control samples of all finishes prior procurement/construction for RRS approval.
- 05. Executive architect/Contractor to ensure all materials are for purpose and comply to regulation, and ensure all finish achieve any requirements in terms of fire regulations and surfar spread of flame.
- 06. Refer to Lighting Designers info for all lighting layouts specifications.
- 07. Refer to Mechanical & Electrical (M&E) consultant's info f fire safety and M&E layouts & specifications.
- 08. The executive architect/contractor is to satisfy themself with regards to the structural stability of all design inte information.
- 09. Executive architect/contractor to confirm that a installation/construction is suitable for existing floor and w loadings prior to construction.
- 10. The executive architect/contractor is to agree any variatio with the architect/client prior to construction or procurement of ar materials/manufacture.
- 11. All glazing specifications and structure to be to special contractor's details. Shop drawings to be produced for RR approval.

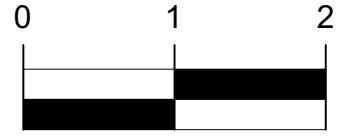

- B 02.11.23 Design of GF roof extensions design adjusted to slope down to neighbours boundary
- A 12.09.23 Reduced extension height to 3M in line with PD allowance

**Revision**    **Date**    **Description**

© Rich Ryan Studio

Do not scale from this drawing. All dimensions to be checked on site. Rich Ryan Studio to be notified of any discrepancies between the drawing and site conditions.

To be read in conjunction with all relevant specifications, schedules and drawings.

**Project**  
37 Cheltenham Rd

**Drawing Title**  
Proposed  
Side Elevation

**Date**  
06/11/2023

**Status**  
Client Info

**Scale**  
1:50 at A3

**Drawn**  
RR

**Checked**  
XX

**Project number**  
0032

**Drawing number**  
2002 B

**Revision**

**Rich Ryan Studio**

Eves, Pett Rd, Pett  
East Sussex TN35 4HG  
+ 44 (0) 7771 395252  
rich@richryan.co.uk