


PROPOSED SKYWAY ROOF PLAN (LEVEL F)

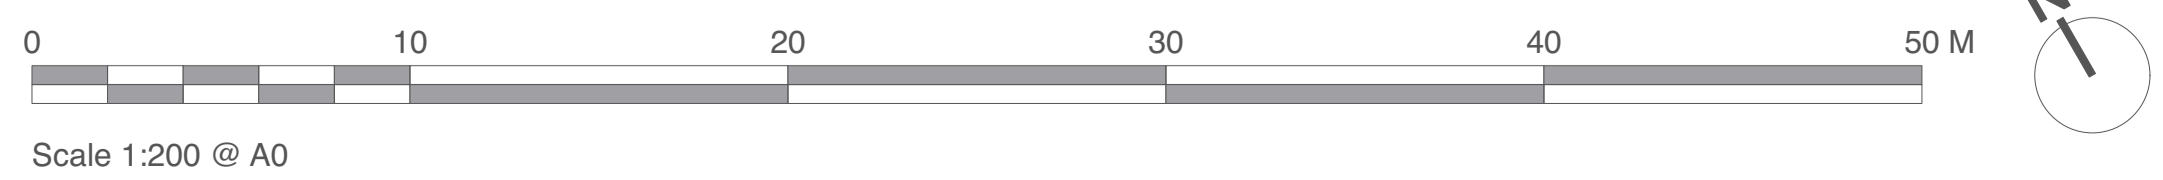

Scale 1:200 @ A0

PLANNING



Chartered Architects
Chartered Building Surveyors
Interior Designers
CDM Services

3 GP Centre, Yeoman Road,
Ringwood, Hampshire, BH24 3FF
+44 (0)425 472 833
www.kendallkingscott.co.uk

Project	Proposed Vertical Extension Oncology
Client	University Hospital Southampton
Scale	1:200
Paper Size	ISO A0
Filename	201254.vwx
© Copyright	Do not scale this drawing

P03	18/10/2023	TC	CS	Layout amended as design has developed.
P02	11/02/2022	TC	CS	Rooflights added to Skyway.
P01	27/01/2022	TC	CS	First issue.
Rev	Date	By	Ap	Note

Drawing Title	Proposed Skyway Plan (Level F)
Project Number	201254-VEO-KKL-00-ZZ-DR-A-1406
Revision	P03
Date	05/01/2022
Drawn	TC
Checked	CS
Purpose/Status	PLANNING
Check all dimensions and levels on site	

Only to be used on the site for which designed. The electronic transmission of design information contained in this drawing is carried out entirely at the user's risk and Kendall Kingscott Ltd. will have no liability for any errors or inaccuracies arising therefrom. The production of amended or updated information from the last design information by the user is entirely the responsibility of the user and Kendall Kingscott Ltd. shall have no responsibility to report thereof.