


PROPOSED SKYWAY ROOF PLAN (LEVEL D)

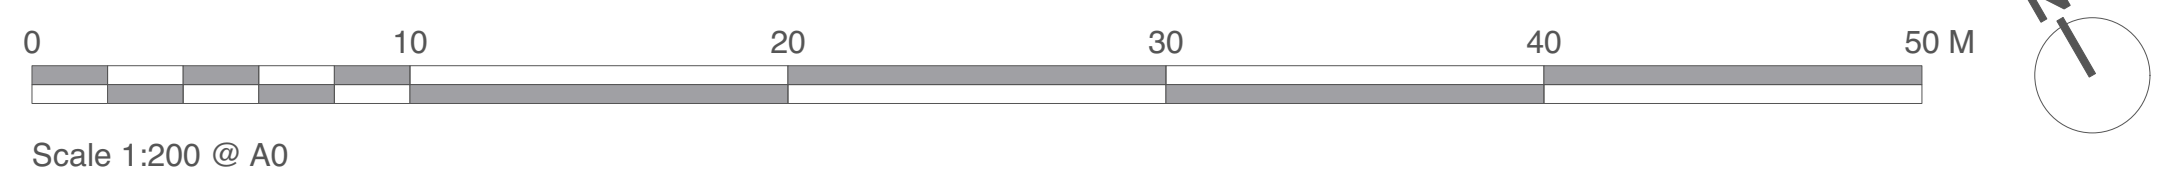

Scale 1:200 @ A0

PLANNING



Chartered Architects
Chartered Building Surveyors
Interior Designers
CDM Services

3 GP Centre, Yeoman Road,
Ringwood, Hampshire, BH24 3FF
+44 (0)425 472 833
www.kendallkingscott.co.uk

| | | |
|----------------|--------------------------------------|---|
| Project | 18/10/2023 TC CS | Layout amended as design has developed. |
| Client | 27/01/2022 TC CS | First issue. |
| Scale | 1:200 | |
| Paper Size | ISO A0 | 201254.vwx |
| File Name | 201254.vwx | |
| Date | 05/01/2022 | TC CS |
| Drawn | TC | CS |
| Checked | TC | CS |
| Purpose/Status | PLANNING | |
| Project Title | Proposed Vertical Extension Oncology | Proposed Skyway Plan (Level E) |
| Client | University Hospital Southampton | |
| Project Number | 201254-VEO-KKL-00-ZZ-DR-A-1404 | P02 |

Only to be used on the site for which designed. The electronic transmission of design information contained in this drawing is carried out entirely at the user's risk and Kendall Kingscott Ltd. will have no liability for any errors or inaccuracies arising therefrom. The production of amended or updated information from the last design information by the user is entirely the responsibility of the user and Kendall Kingscott Ltd. shall have no responsibility to report thereof.