


PROPOSED SKYWAY ROOF PLAN (LEVEL E)

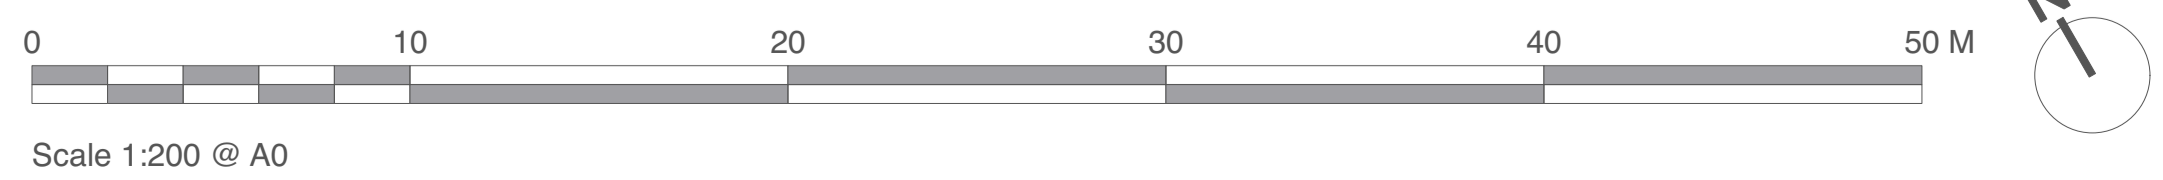

Scale 1:200 @ A0

PLANNING



Chartered Architects
Chartered Building Surveyors
Interior Designers
CDM Services

3 GP Centre, Yeoman Road,
Ringwood, Hampshire, BH24 3FF
+44 (0)425 472 833
www.kendallkingscott.co.uk

Project: **Proposed Vertical Extension Oncology**
Client: **University Hospital Southampton**
Scale: **1:200**
Paper Size: **ISO A0**
Filename: **201254.vwx**
© Copyright

P03 18/10/2023 TC CS Layout amended as design developed.
P02 11/02/2022 MC CS Rooflights added to Skyway.
P01 27/01/2022 TC CS First issue.
Rev Date By Ap Note

Drawing Title: **Proposed Skyway Plan (Level E)**
Project Number: **201254-VEO-KKL-00-ZZ-DR-A-1405**
Revision: **P03**
Date: **05/01/2022**
Drawn: **TC**
Checked: **CS**
Purpose/Status: **PLANNING**
Check all dimensions and levels on site

Only to be used on the site for which designed. The electronic transmission of design information contained in this drawing is carried out entirely at the user's risk and Kendall Kingscott Ltd. will have no liability for any errors or inaccuracies arising therefrom. The production of amended or updated information from the last design information by the user is entirely the responsibility of the user and Kendall Kingscott Ltd. shall have no responsibility to report thereof.