


Notes & Revisions

Figured dimensions only are to be used. Contractor must verify all dimensions on site before commencing work. Any discrepancies must be brought to the attention of the client.

Structural Work
All indications as to structure are for graphic purposes only and must not be relied upon for accuracy in terms of size, detail or position. All structure and temporary propping to be confirmed by a suitably qualified engineer before beginning works.

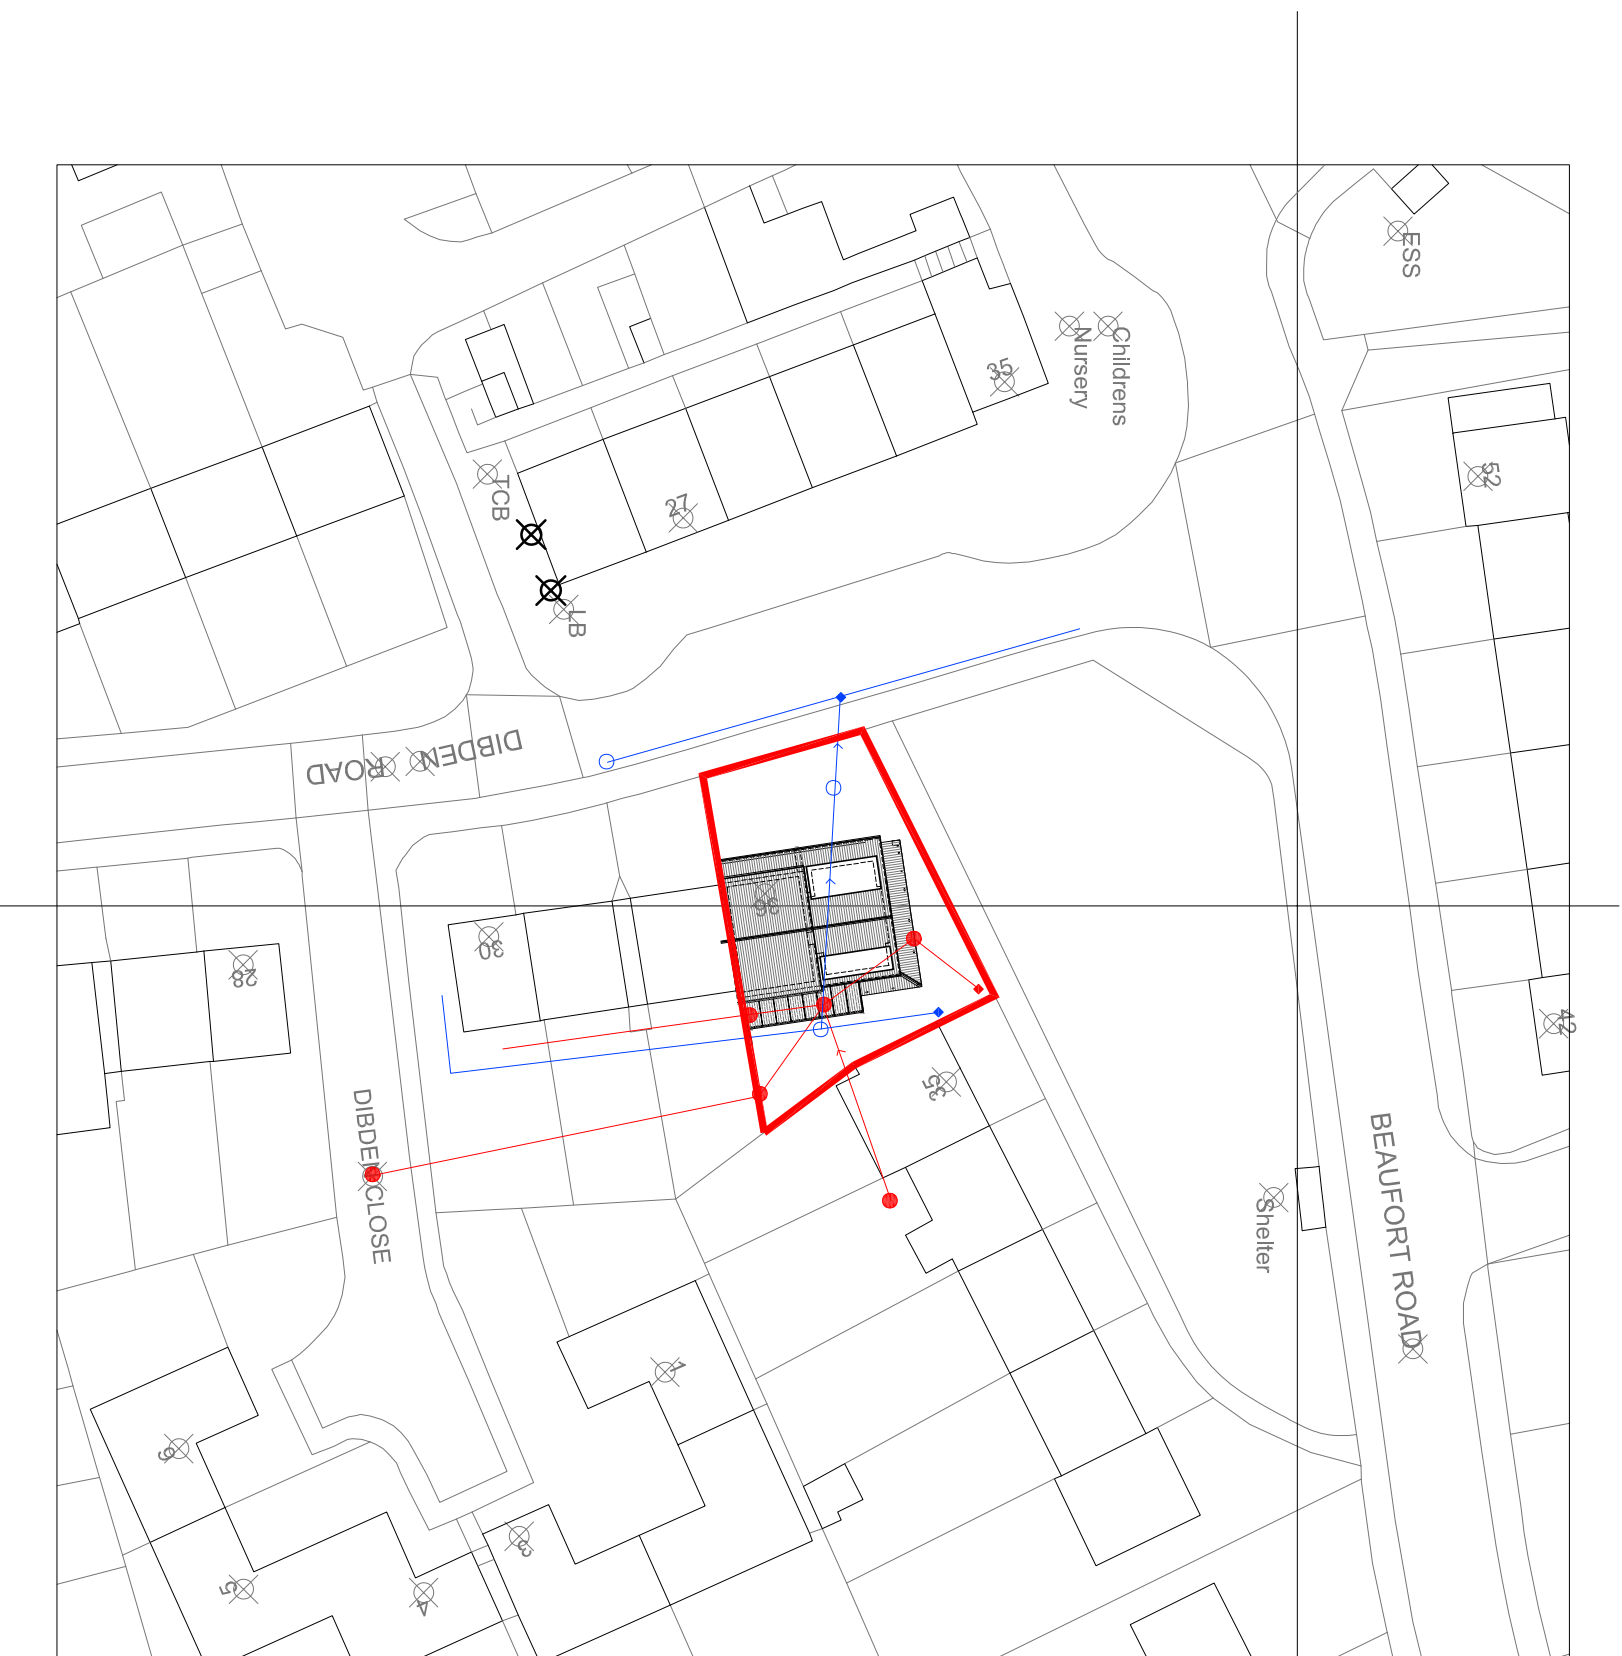

Drainage Layout

- Manhole- Surface Water
- Manhole- Foul
- ◆ Birucation- Surface Water
- ◆ Birucation- Foul

Refer to Wastewater Network Map for routes beyond application site

36 Dibden Road, Downtend

Drawing: Existing Block Plan
Scale: 1:500@A3, 1:250@A1
Status: Planning
Ref: 4100-002

Drawn: MW
Date: Sept 2023
Revision: -

EXISTING

Clear Future : Architecture

Mobile: +44 (0)7973264343
E-Mail: markw.arch@gmail.com