


NOTES

- ELECTRICAL LEGEND:**
- ⏏ Double switch socket
 - ⏏ Switch with remote spur
 - ⊗ Light Fixture ceiling... pendant
 - ⊗ Light switch
 - ⊗ Bulkhead Light Fixture ... PIR
 - ⊗ Ceiling Mounted Exhaust Fan
 - ⊗ Wall Mounted Exhaust Fan
 - ⊗ Tv Outlet
 - ⊗ Telephone Outlet
 - ⊗ Smoke Detector ... hard wired
 - ⊗ Heat Detector ... hard wired
 - ⊗ Carbon monoxide Detector/hard wired
 - ⊗ Under floor heating manifold.
 - ⊗ Door bell...electric
 - ⊗ Door bell push
 - ⊗ Cooker control unit
 - ⊗ Shaver socket outlet
 - ⊗ Consumer unit
 - ⊗ Double switch + Broadband socket

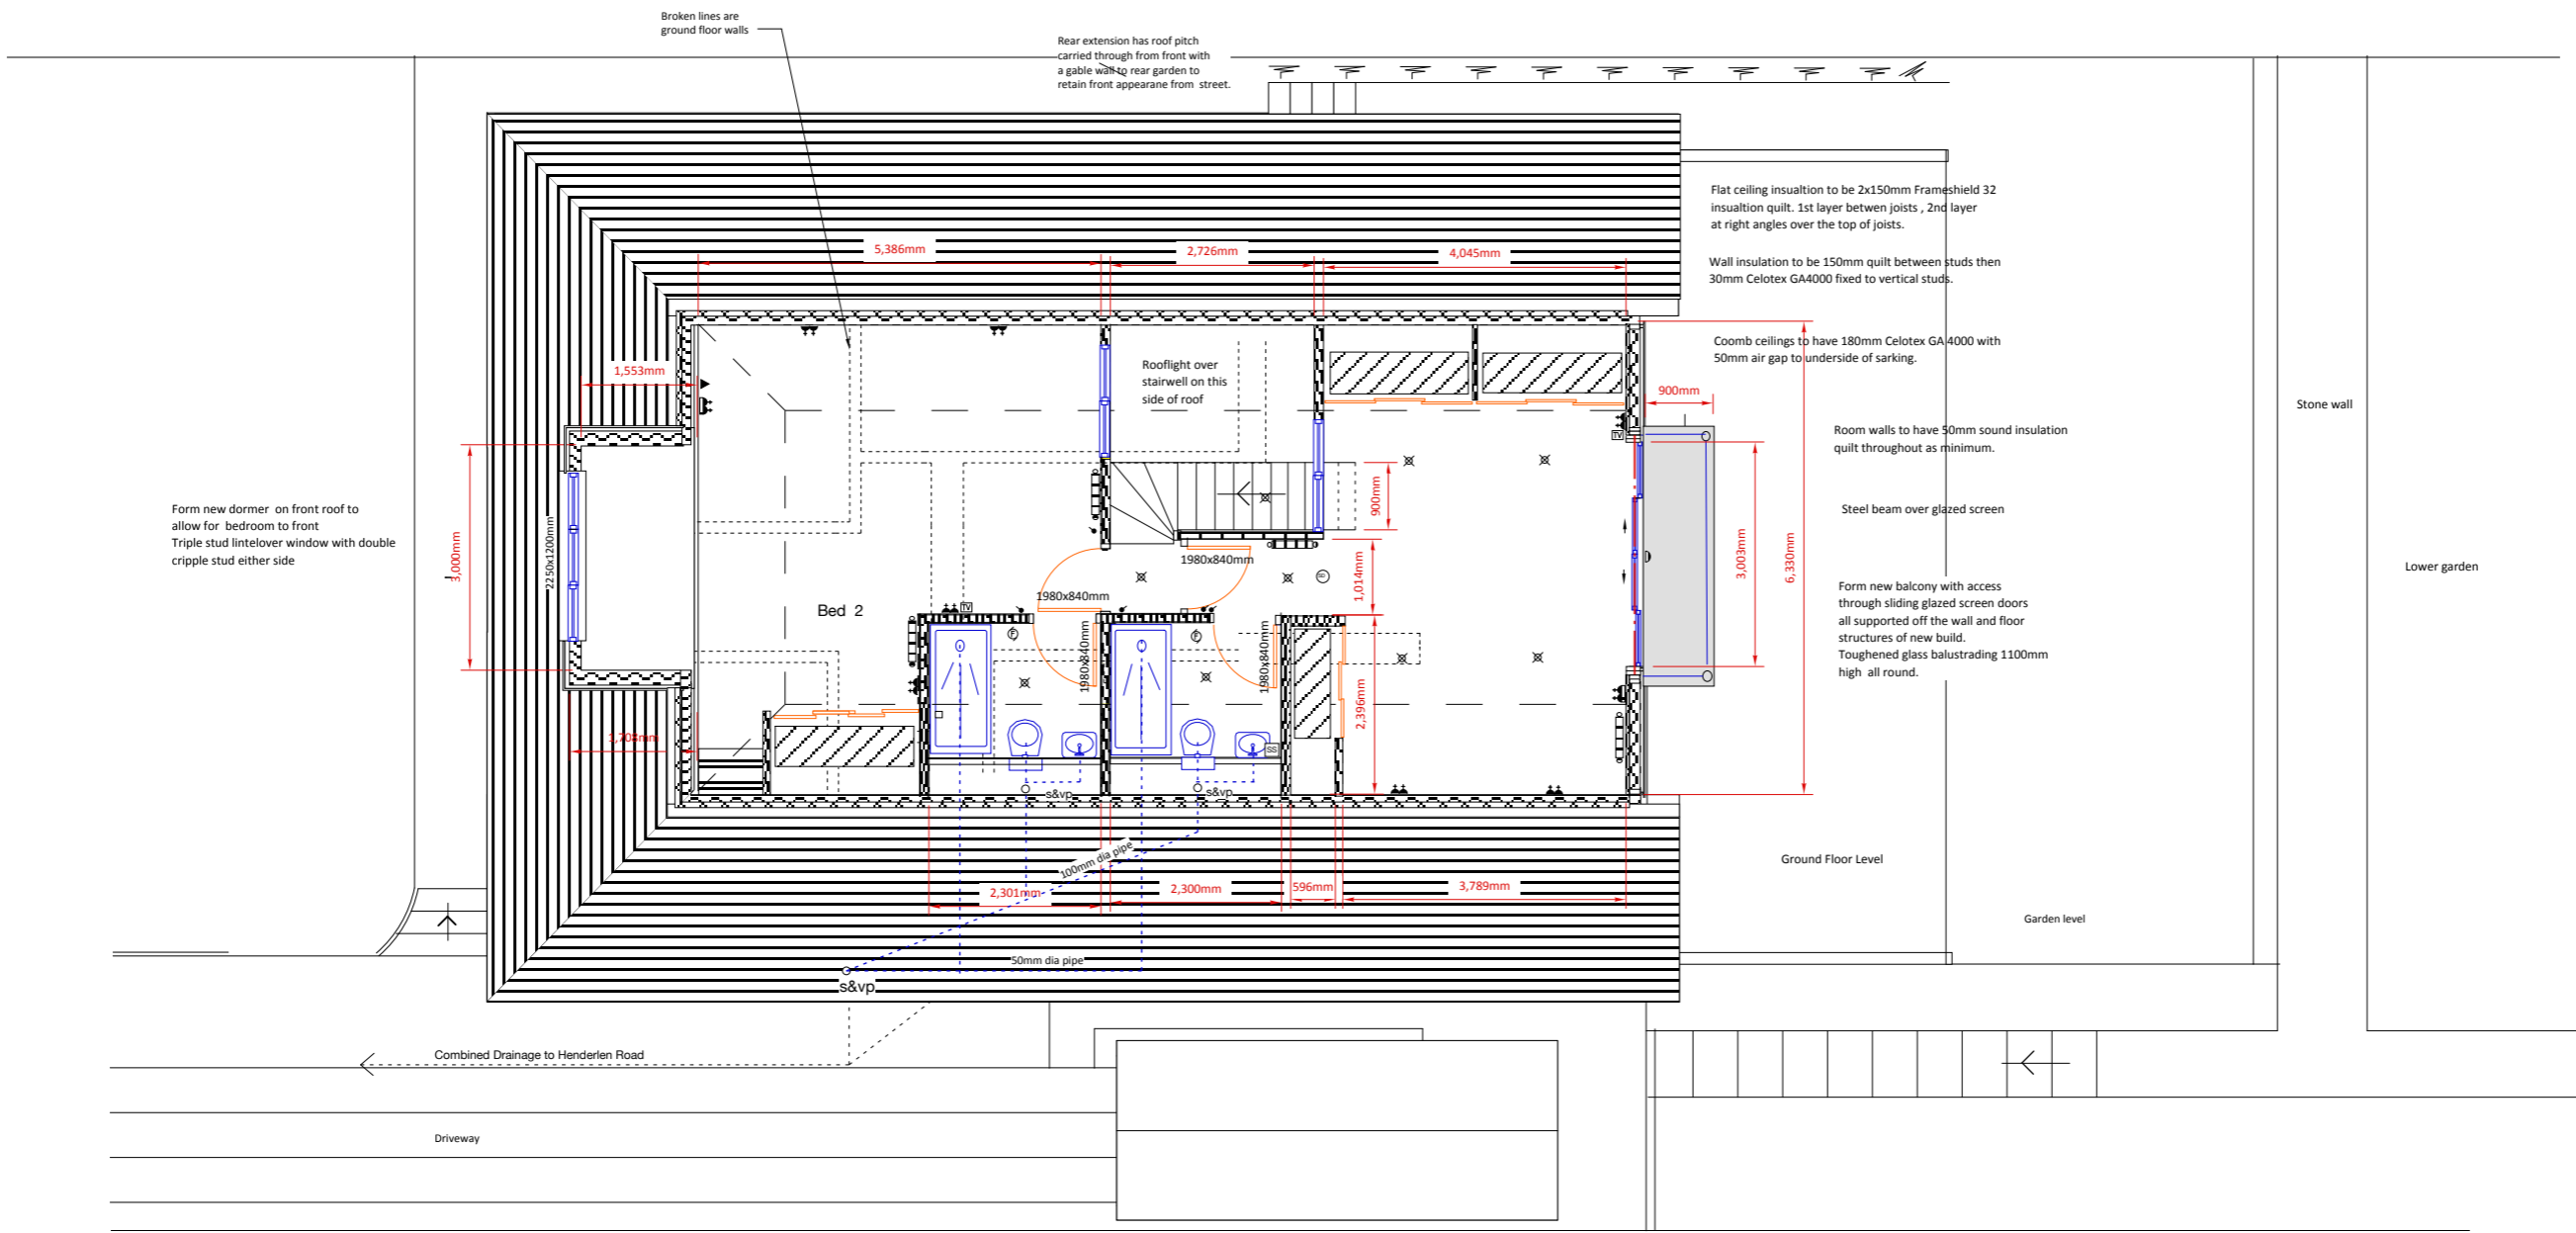

FIRST FLOOR PLAN... 83.24 Sq m



IF IN DOUBT ASK
DO NOT SCALE FROM THIS DRAWING

REV	DATE	REMARKS

CLIENT:
Mr Tariq Purvaze

SITE ADDRESS:
71 Henderland Road, Glasgow G61 1JF

PROJECT:
House extension

DWG TITLE:
First Floor Plan .. proposed

SCALE: 1:50 @ A1
1:100 @ A3

DATE: 24.10.23

DWG No: A1568.23.09

KEITH EDWARDS ARCHITECT

2 CALEDON STREET, GLASGOW ... G12 9GX
tel: 0141 341 0694 mob: 07577359147
email: k.edwards1701@gmail.com
website: @keith.edwards.com