


NOTES

- ELECTRICAL LEGEND:**
- ⏻ Double switch socket
 - ⏻ Switch with remote spur
 - ⊗ Light Fixture ceiling... pendant
 - ⊗ Light switch
 - ⊗ Bulkhead Light Fixture ... PIR
 - ⊗ Ceiling Mounted Exhaust Fan
 - ⊗ Wall Mounted Exhaust Fan
 - ⊗ Tv Outlet
 - ⊗ Telephone Outlet
 - ⊗ Smoke Detector ... hard wired
 - ⊗ Heat Detector ... hard wired
 - ⊗ Carbon monoxide Detector/hard wired
 - ⊗ Under floor heating manifold.
 - ⊗ Door bell...electric
 - ⊗ Door bell push
 - ⊗ Cooker control unit
 - ⊗ Shaver socket outlet
 - ⊗ Consumer unit
 - ⊗ Double switch + Broadband socket

Cavity wall construction with external block faced with 20mm thick roughcast and finished with galvanised beads set 150mm above ground level.
 Inner leaf to be structural timber frame with full depth insulation and 9mm OSB faced with Tyvek reflex on cavity side and plasterboard on inner leaf over 30mm Celotex GA4000

Boundary fence along fulllength front to rear

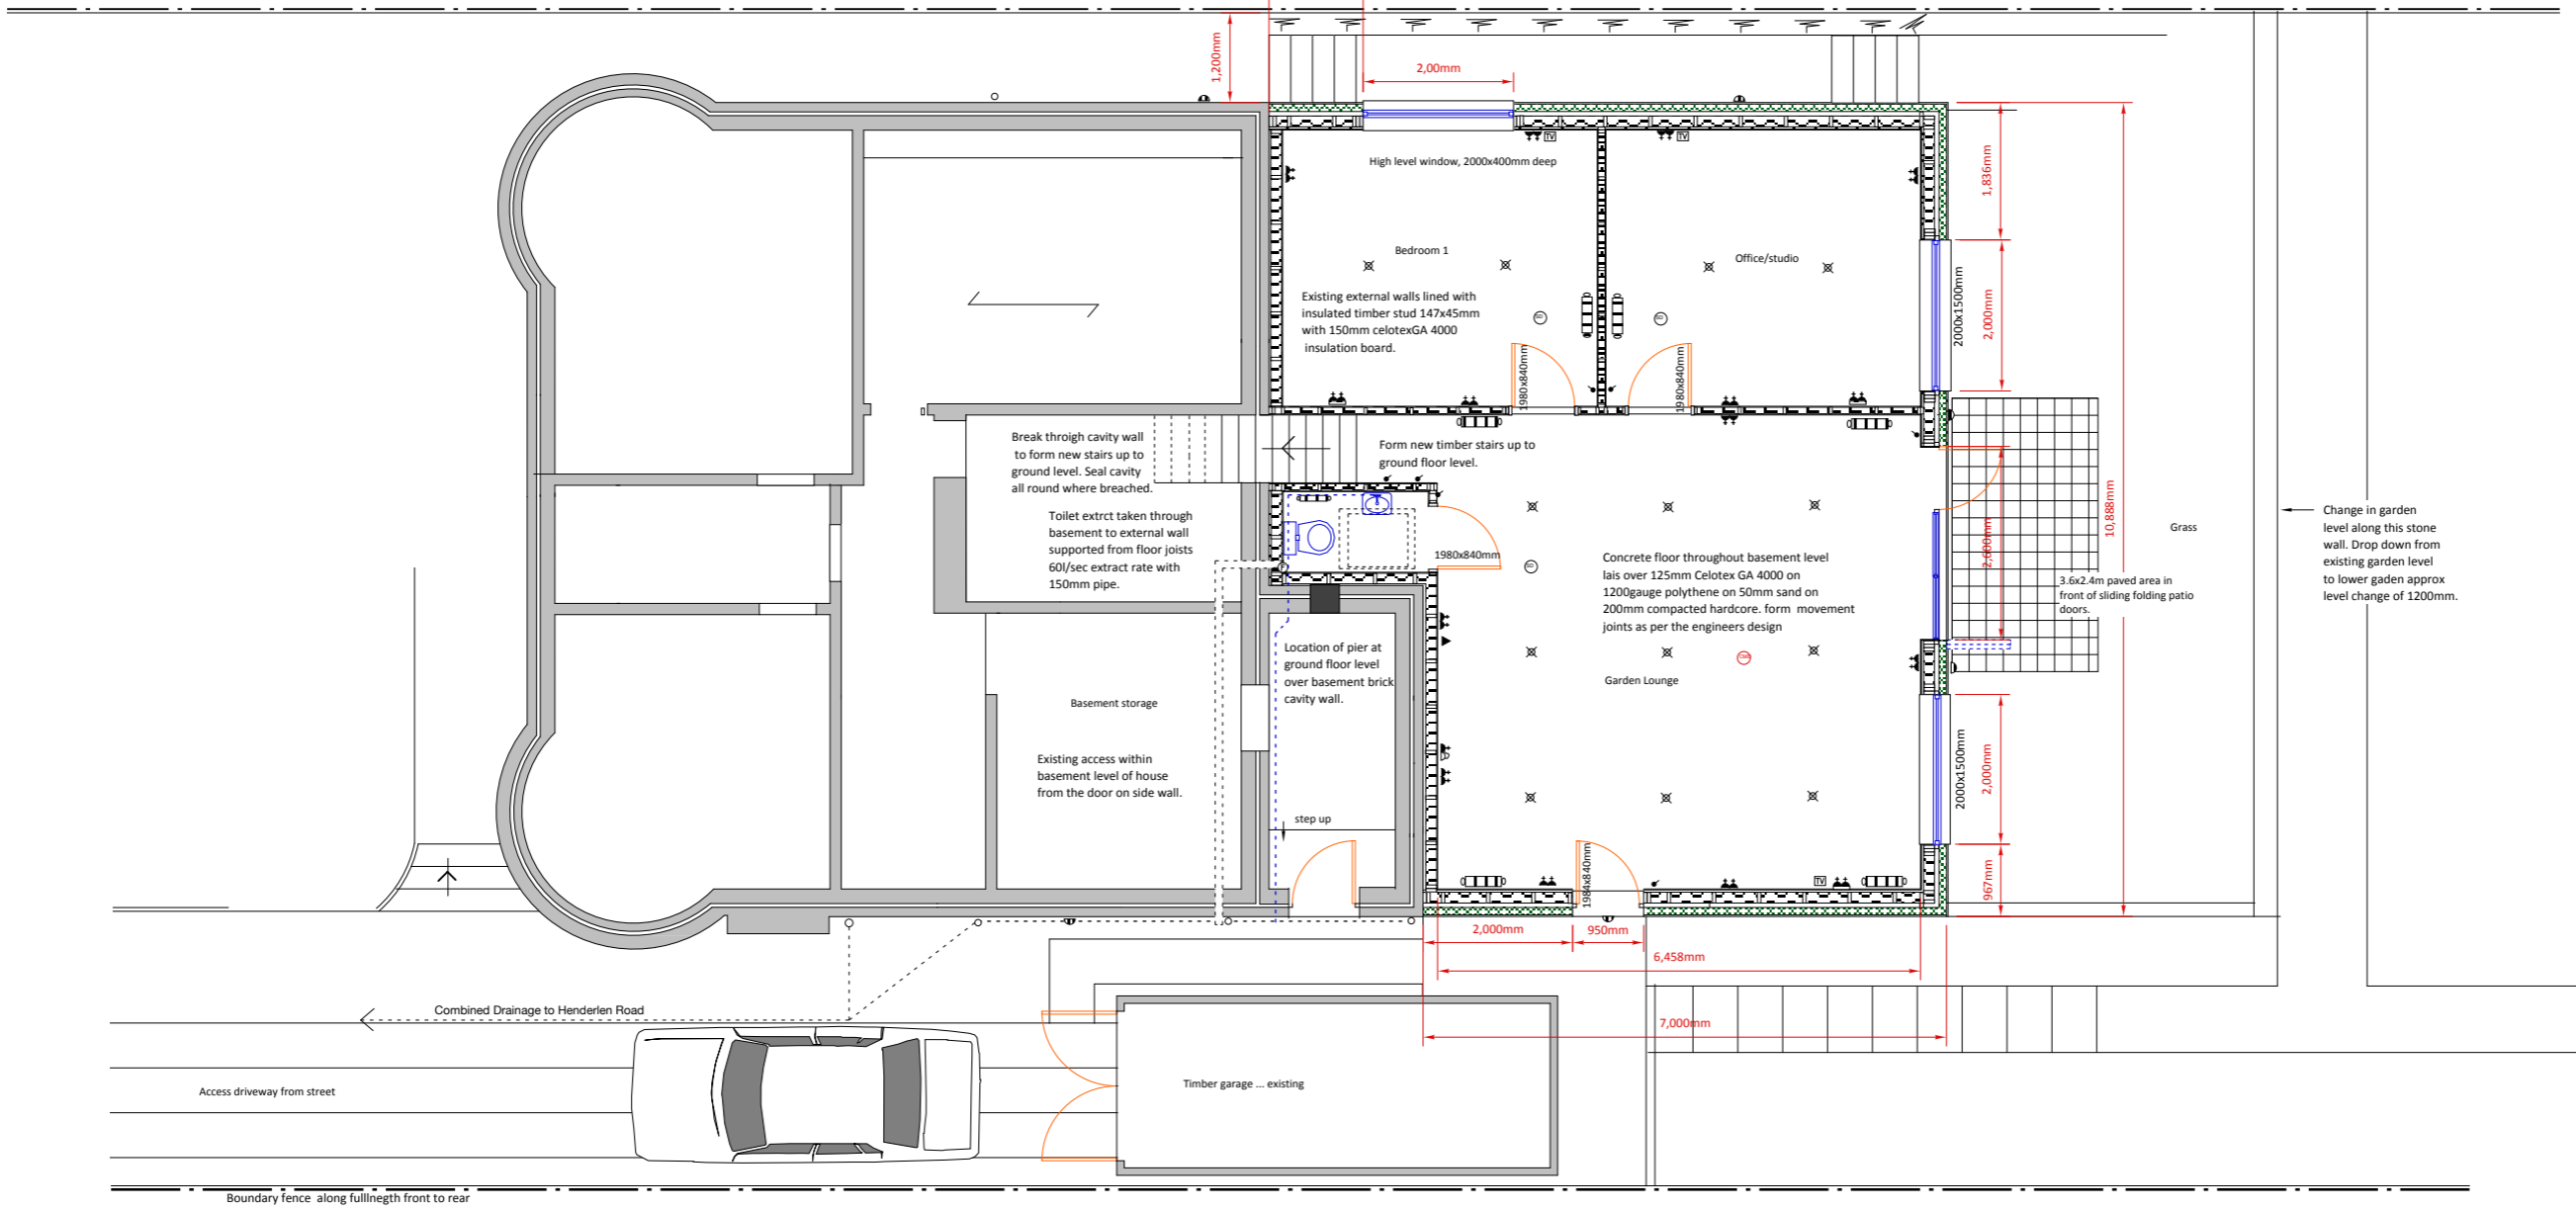

BASEMENT PLAN... 81.82 Sq m



IF IN DOUBT ASK
DO NOT SCALE FROM THIS DRAWING

REV	DATE	REMARKS

CLIENT:
Mr Tariq Purvaze

SITE ADDRESS:
71 Henderland Road, Glasgow G61 1JF

PROJECT:
House extension

DWG TITLE:
Basement Plan ... proposed

SCALE: 1:50 @ A1
1:100 @ A3

DATE: 23.10.23

DWG No: A1568.23.07

REV

KEITH EDWARDS ARCHITECT
 2 CALEDON STREET, GLASGOW ... G12 9GX
 tel: 0141 341 0694 mob: 07577359147
 email: k.edwards1701@gmail.com
 website: @keith.edwards.com