


NOTES

- ELECTRICAL LEGEND:**
- Double switch socket
  - Switch with remote spur
  - Light Fixture ceiling... pendant
  - Light switch
  - Bulkhead Light Fixture... PIR
  - Ceiling Mounted Exhaust Fan
  - Wall Mounted Exhaust Fan
  - Tv Outlet
  - Telephone Outlet
  - Smoke Detector... hard wired
  - Heat Detector... hard wired
  - Carbon monoxide Detector/hard wired
  - Under floor heating manifold
  - Door bell... electric
  - Door bell push
  - Cooker control unit
  - Shaver socket outlet
  - Consumer unit
  - Double switch + Broadband socket

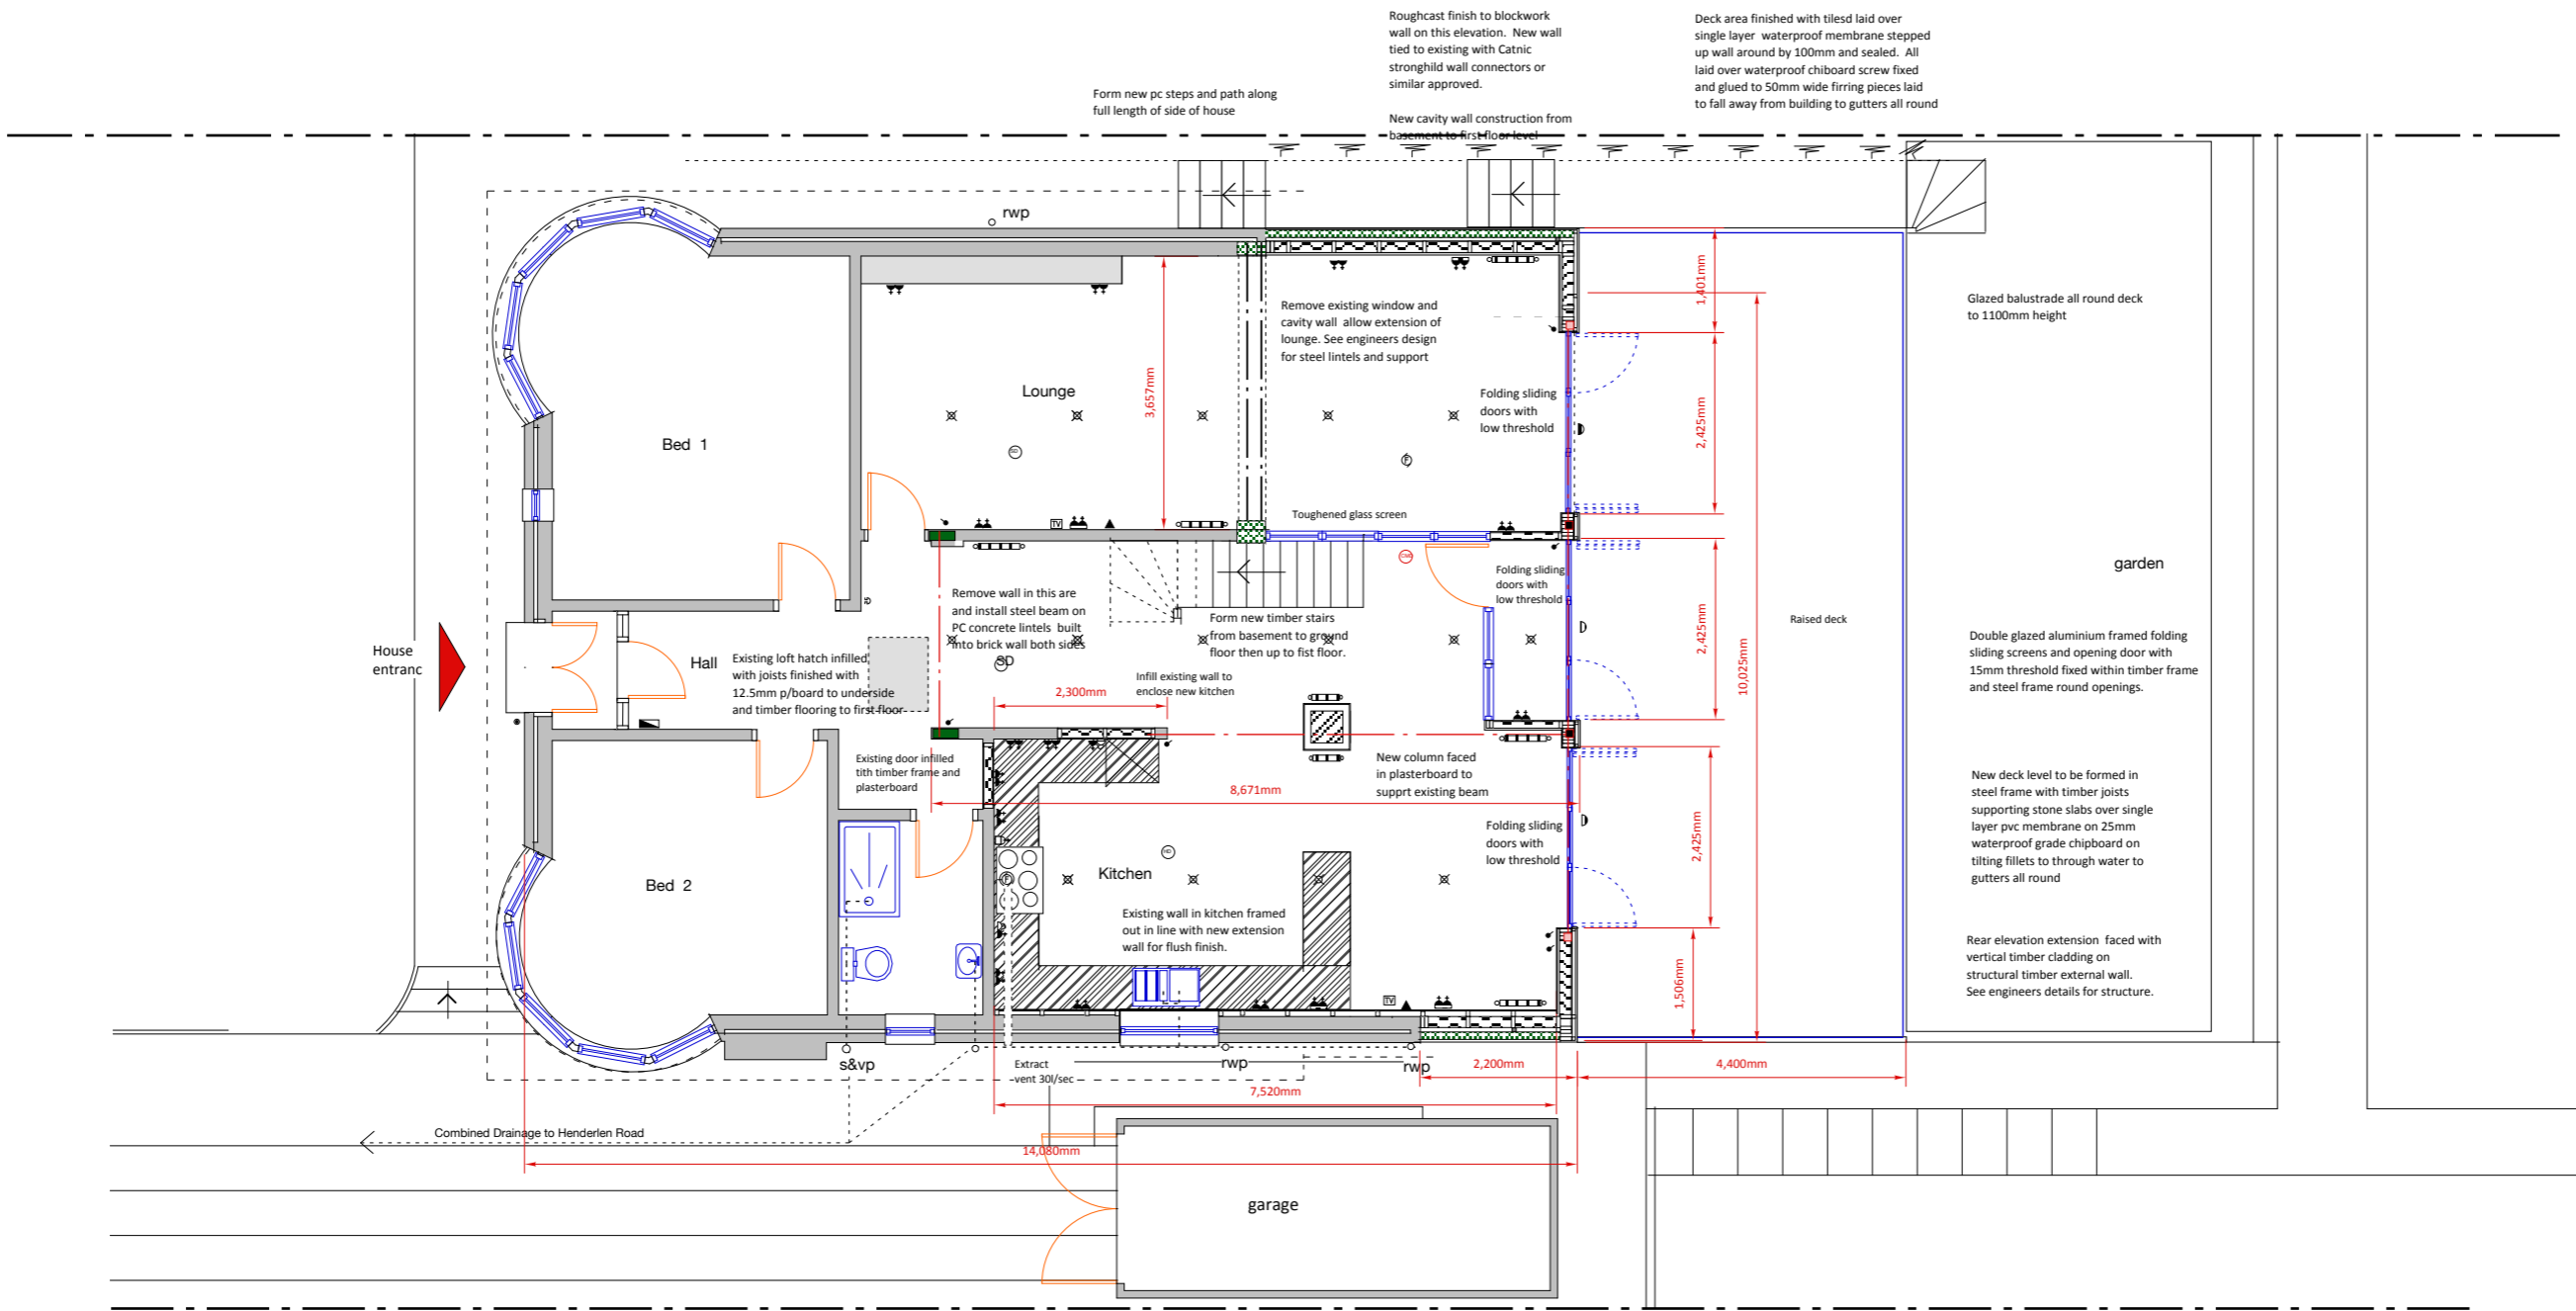

GROUND FLOOR PLAN...



IF IN DOUBT ASK  
DO NOT SCALE FROM THIS DRAWING

REV	DATE	REMARKS

CLIENT: Mr Tariq Bia

SITE ADDRESS: 71 Henderland Road, Glasgow G61 1JF

PROJECT: House extension

DWG TITLE: Ground Floor Plan .. proposed

SCALE: 1 : 50 @ A1  
1 : 100 @ A3

DATE: 17.03.23

DWG No: A1568.23.03

**KEA** KEITH EDWARDS ARCHITECT

2 CALEDON STREET, GLASGOW ... G12 9GX  
tel : 0141 341 0694 mob : 07577359147  
email : kedwards1701@gmail.com  
website : @keith.edwards.com