


NOTE 1:  
INSTALLATION AND COMMISSIONING CERTIFICATE TO BE  
ISSUED FOLLOWING TESTING OF FIRE ALARM SYSTEM.  
WRITTEN DOCUMENTATION ON USE & MAINTENANCE TO BE  
ISSUED TO CLIENT.

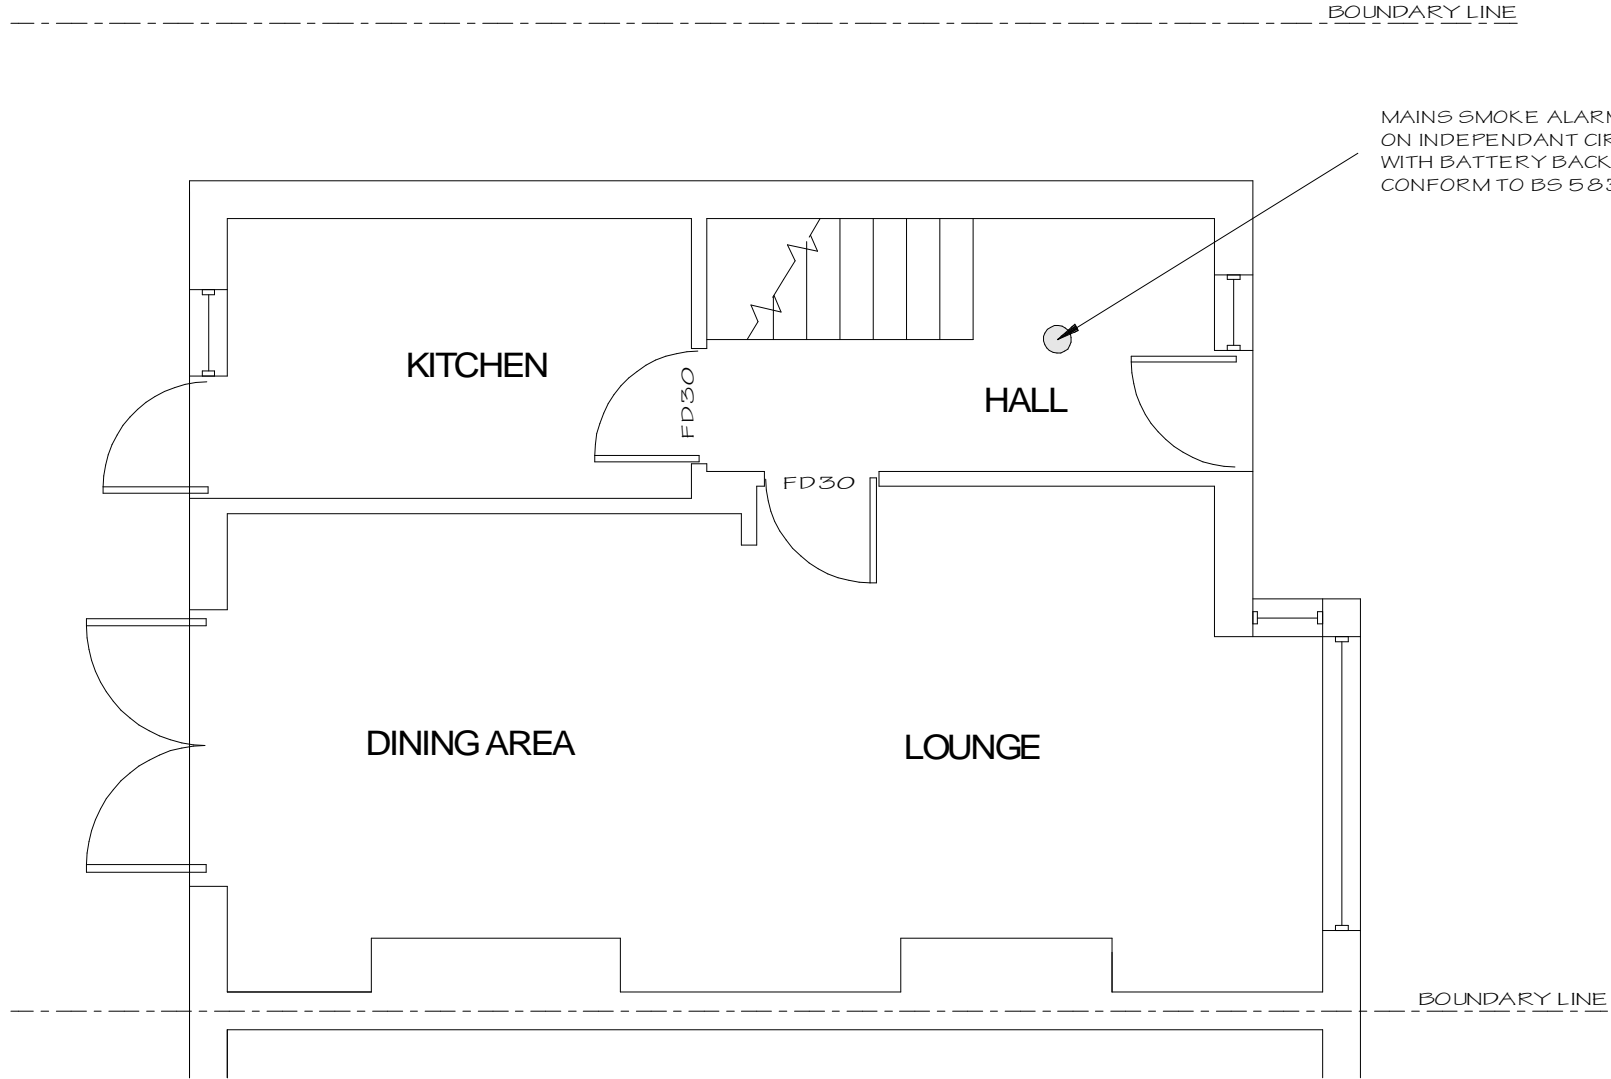

**PROPOSED GROUND FLOOR**  
1:50



**PROPOSED LOFT CONVERSION WITH DORMER  
TO REAR**  
124, WILMOT ROAD  
DARTFORD  
KENT DA1 3BE  
for MR. K. SLEAFER



SCALE 1:50  
DATE NOV.23  
DRG.No DH23/167/02

REV. A