


Ryburn Valley High School



Creation of an AGP

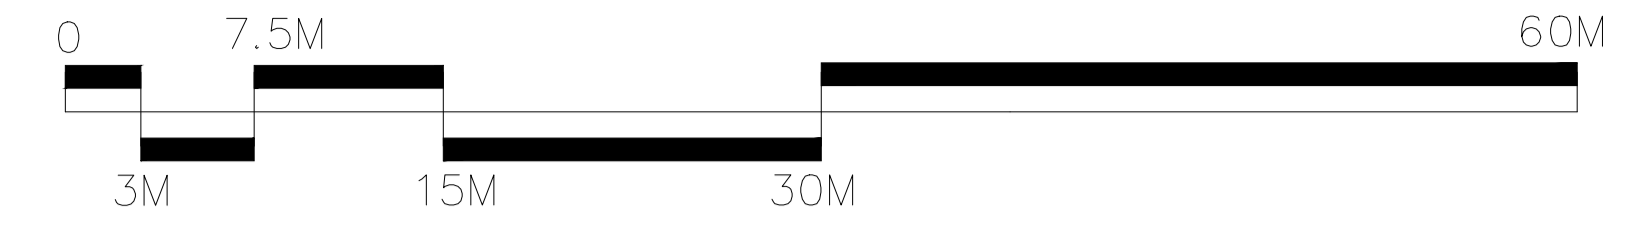

SSS
SURFACING STANDARDS LTD
CONTRACTORS

CONSULTANTS
Surfacing Standards LTD
Office: 2, Enterprise House,
Wether Road, Coptham, LE19 9WY
01535 400 012

- DO NOT SCALE FROM DRAWING. ALL DIMENSIONS TO BE CHECKED ON SITE PRIOR TO COMMENCEMENT OF WORKS.
- THIS DRAWING IS COPYRIGHT © SURFACING STANDARDS LTD.
- ALL PERSONNEL SHOULD BE AWARE OF THE HEALTH AND SAFETY PLAN WHICH IS RETAINED IN THE SITE MANAGER'S OFFICE.

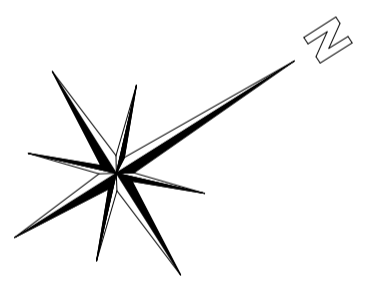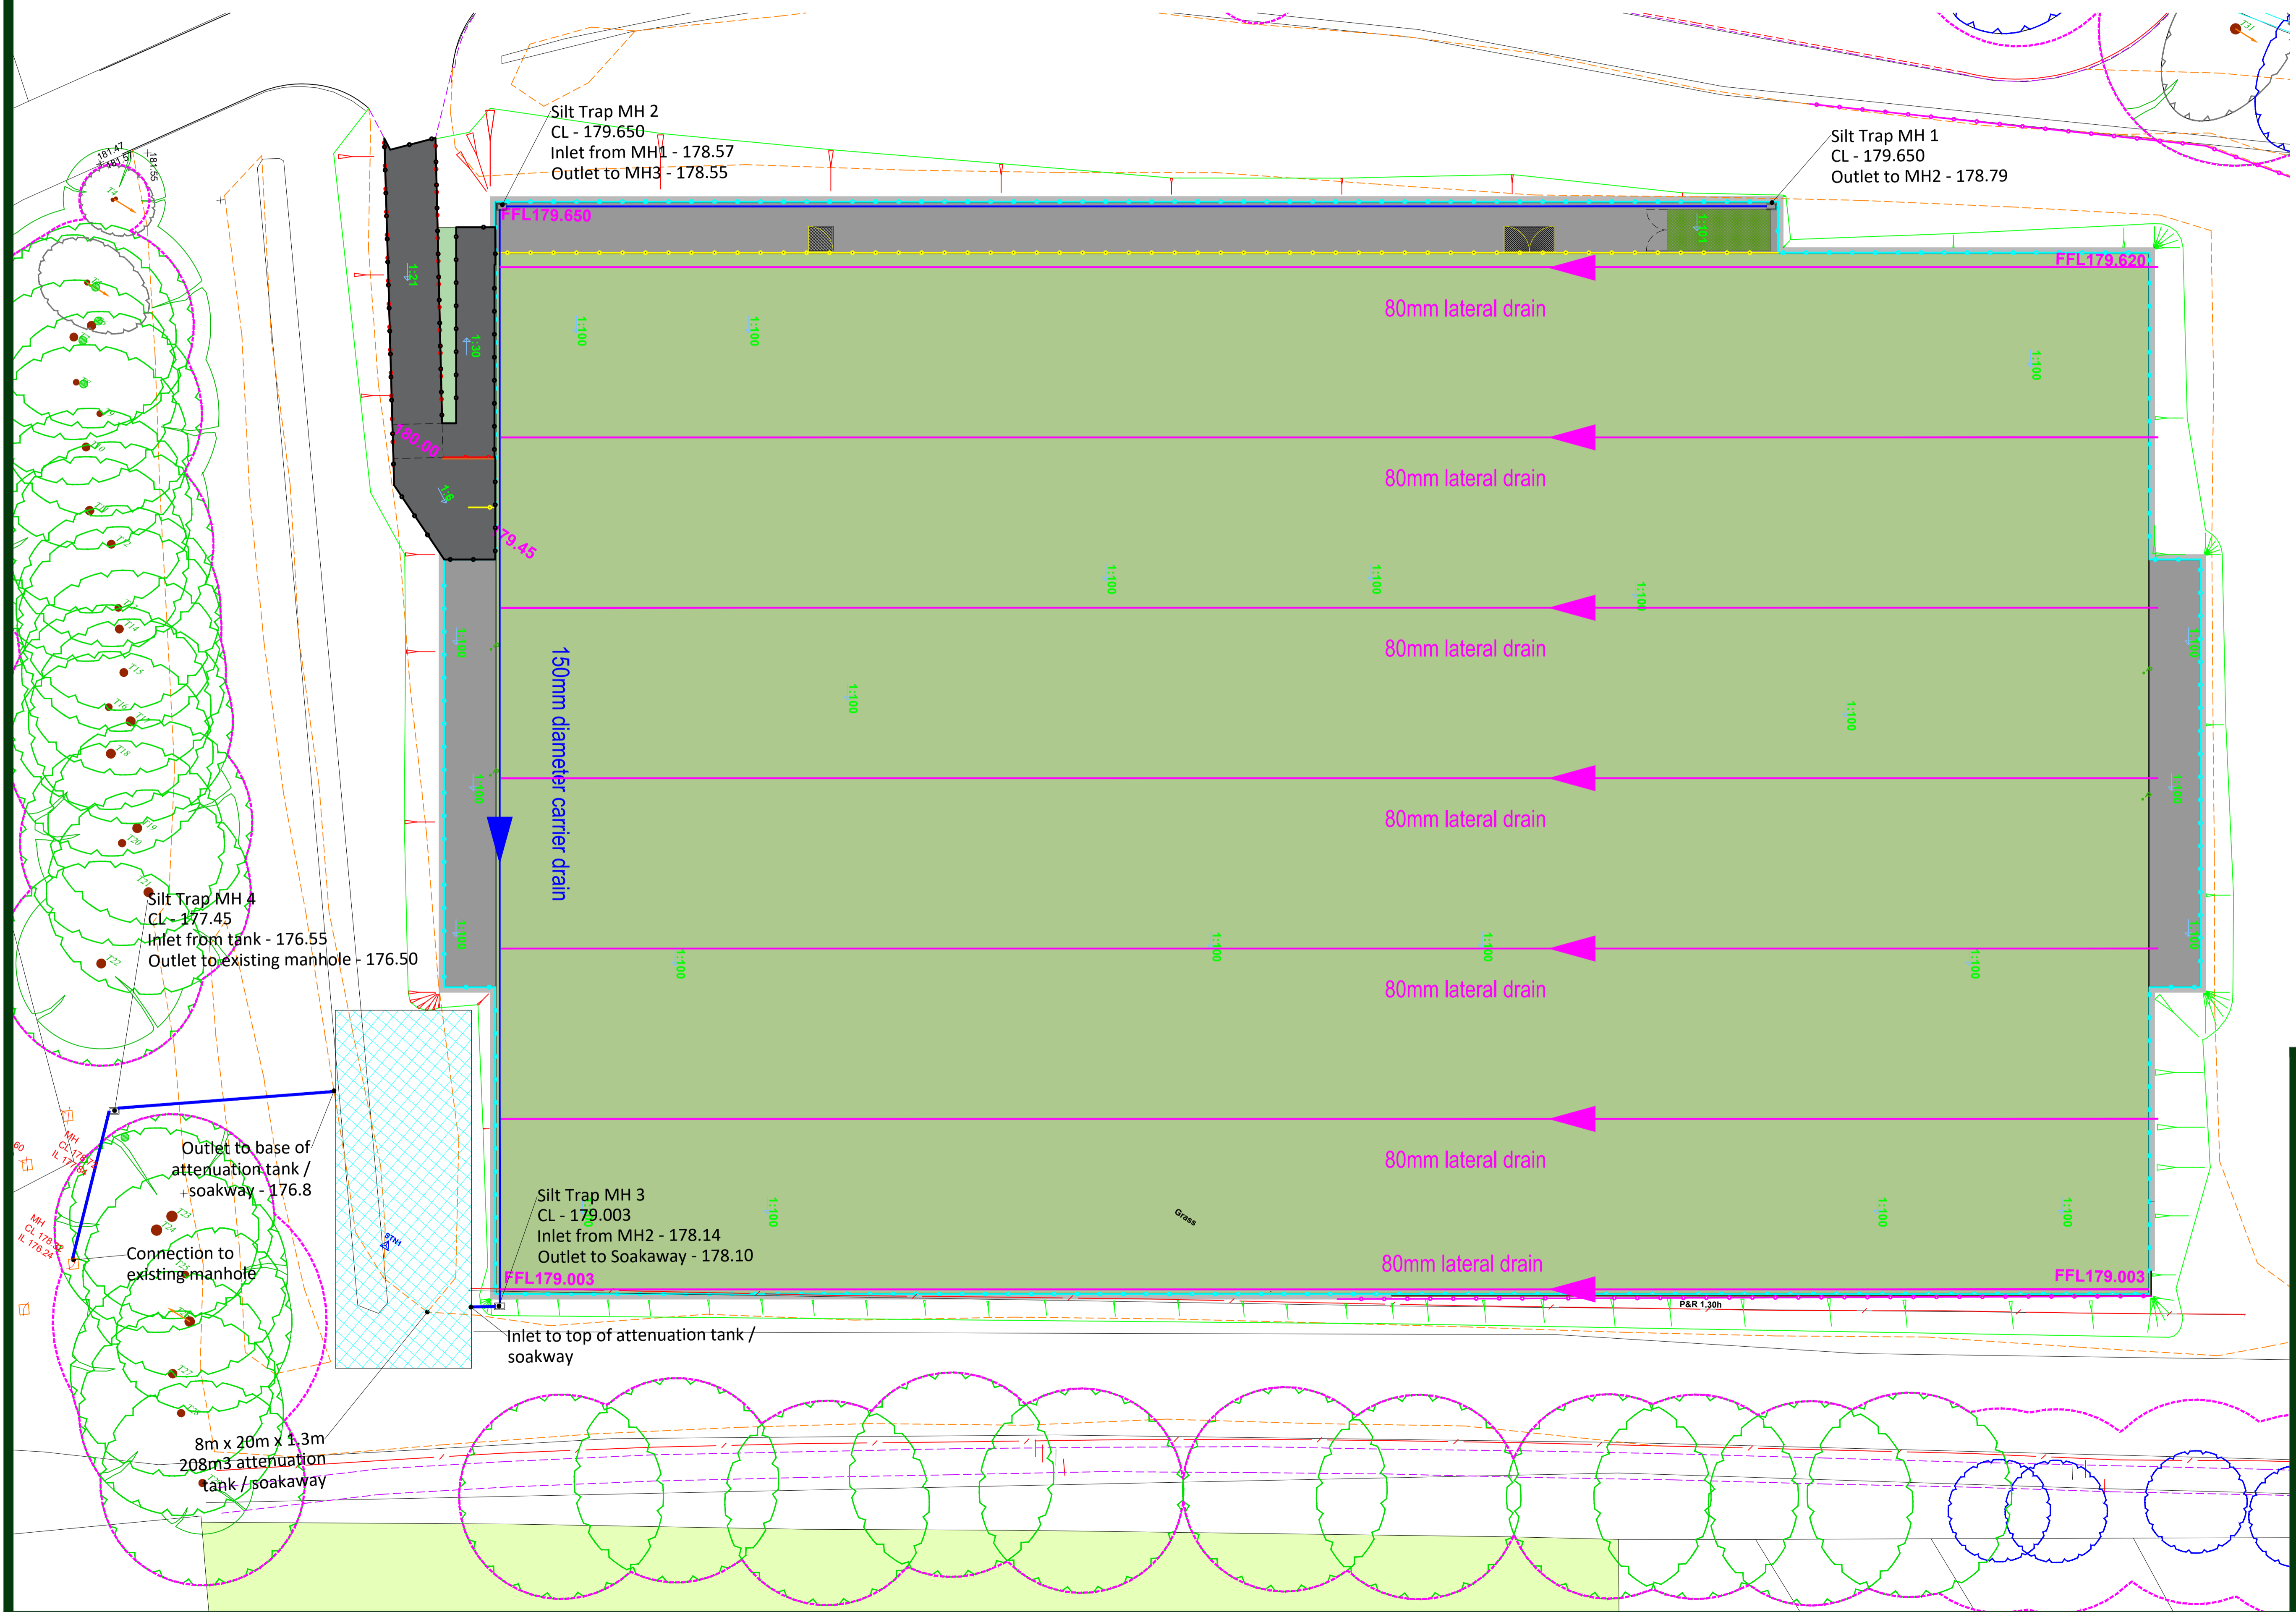

00	PLANNING ISSUE	WB	18.10.23
REV	DESCRIPTION	REV	CK DATE
S&C SLATTER			
AUTHOR ME			
TITLE Ryburn Valley High School Creation of an AGP Proposed AGP Drainage Layout			
PROJECT SC105	SCALE 1:300	SIZE A1	REVISION 00
DRAWING No 07			