

Project  
**1 West Halkin**

---

Project Number  
**1083**

---


Drawing Title  
**Lower Ground Floor - Plumbing Plan**

---

Paper Scale	Issue Date
@ A3	16/08/23

---

REV A 271123

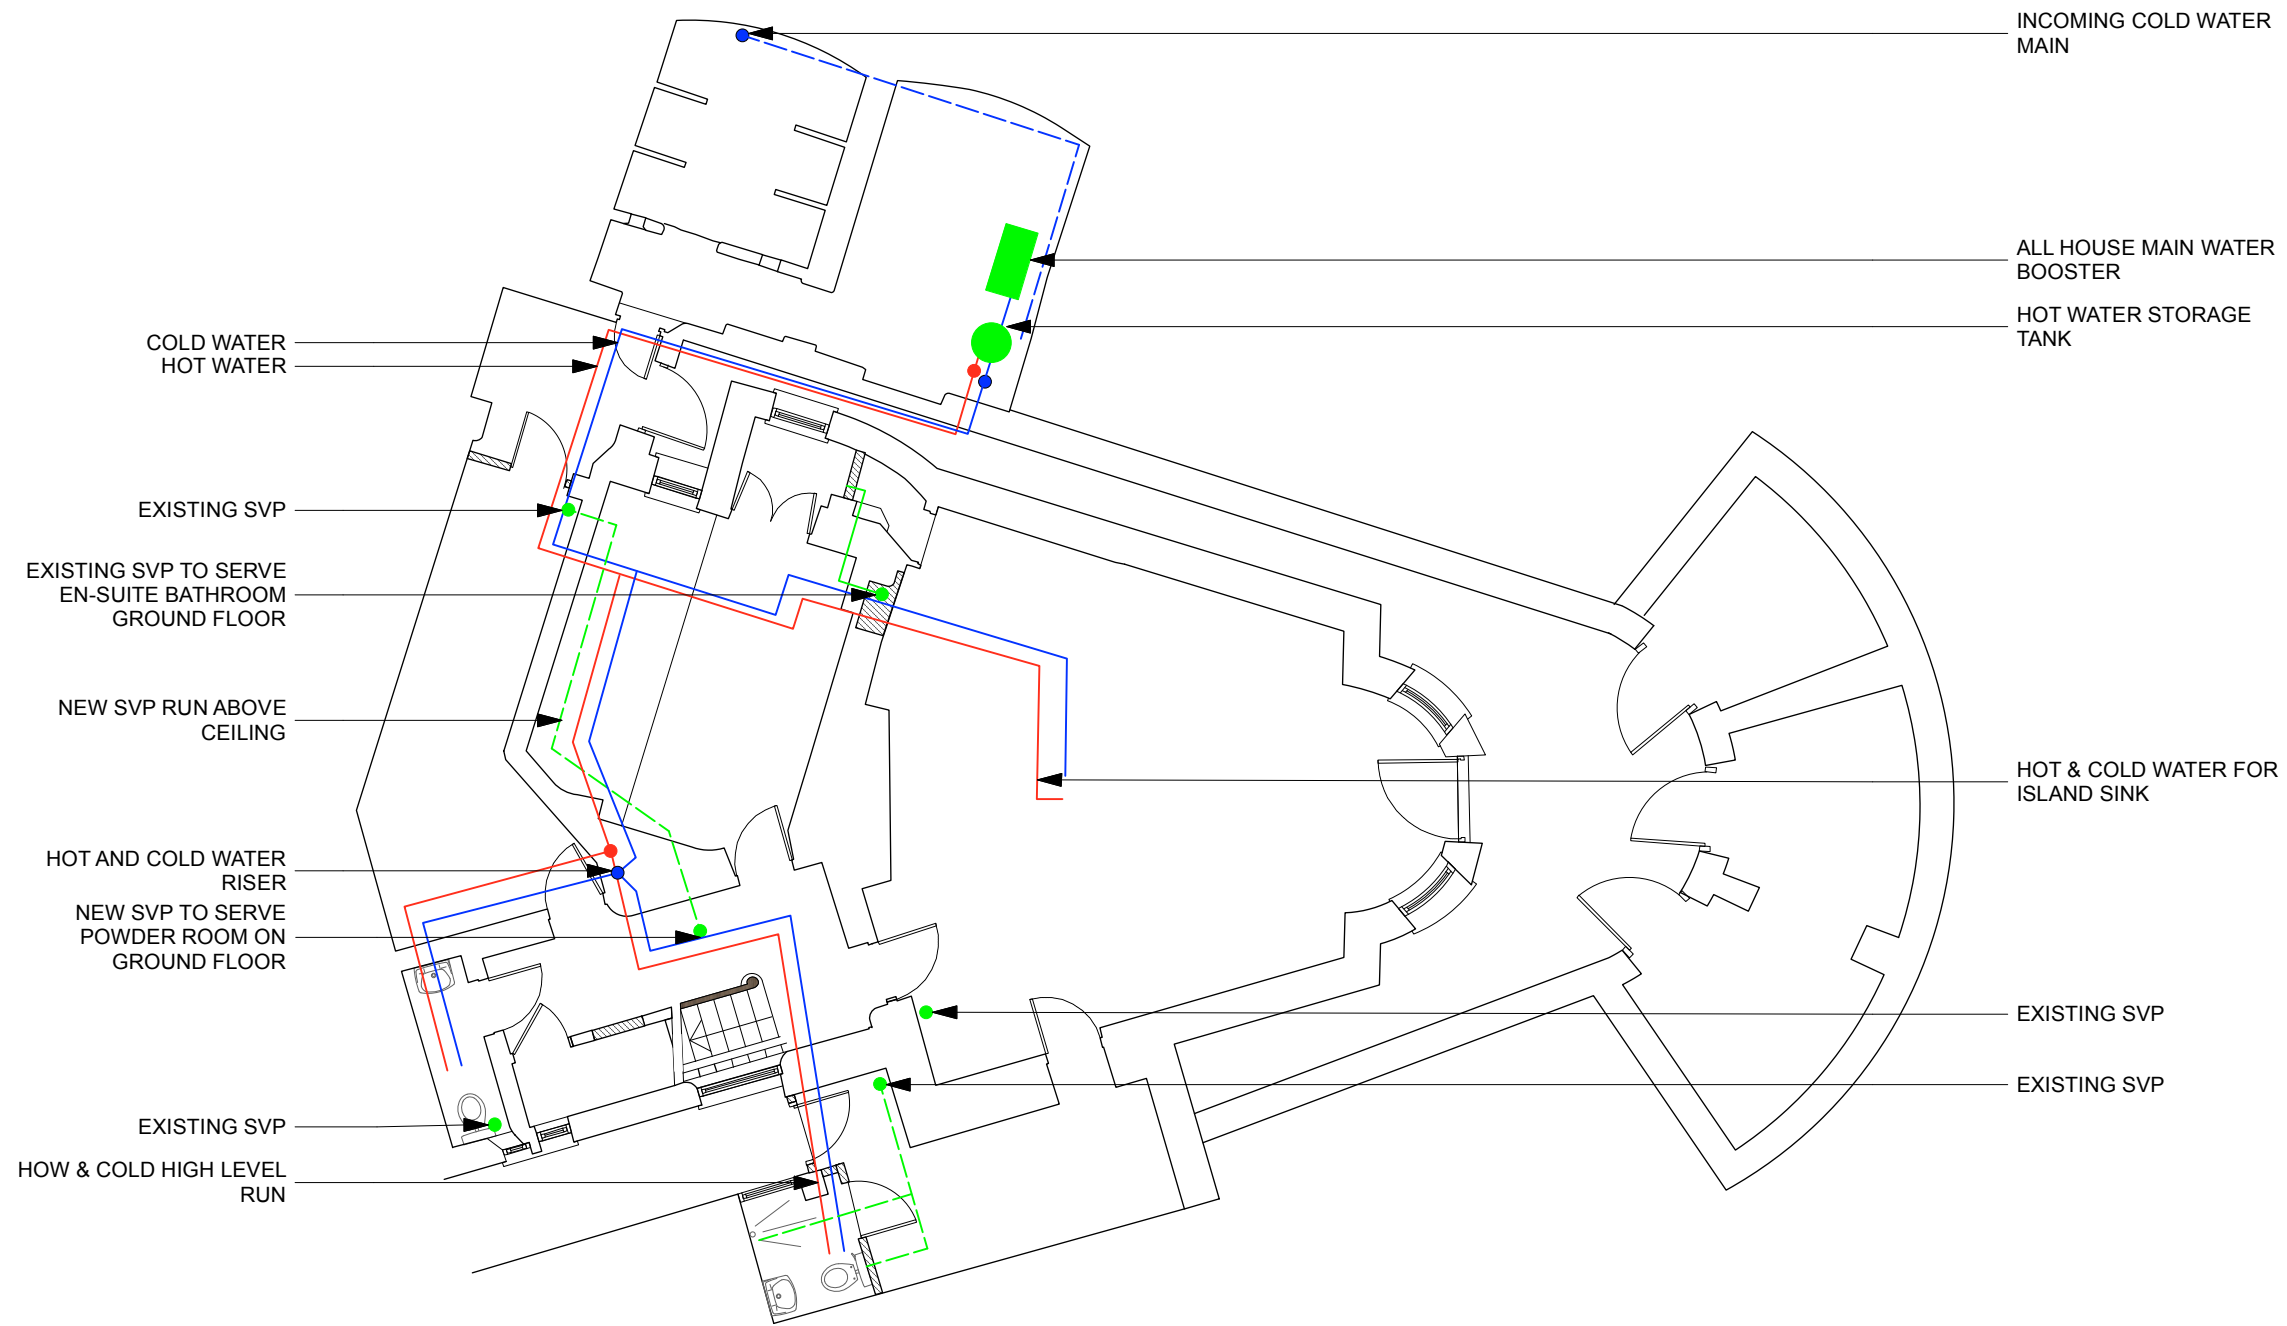

1 Lower Ground Floor  
 Scale: 1:100




**DESIGN & THAT**  
 177 Victoria Park Road, E9 7JN  
 Phone +44 (0) 7891611379

---

www.designandthat.com  
 hello@designandthat.com


Project	
<b>1 West Halkin</b>	
Project Number	
<b>1083</b>	
Drawing Title	
<b>Ground Floor GA - Plumbing Plan</b>	
Paper Scale	Issue Date
<b>@ A3</b>	<b>16/08/23</b>

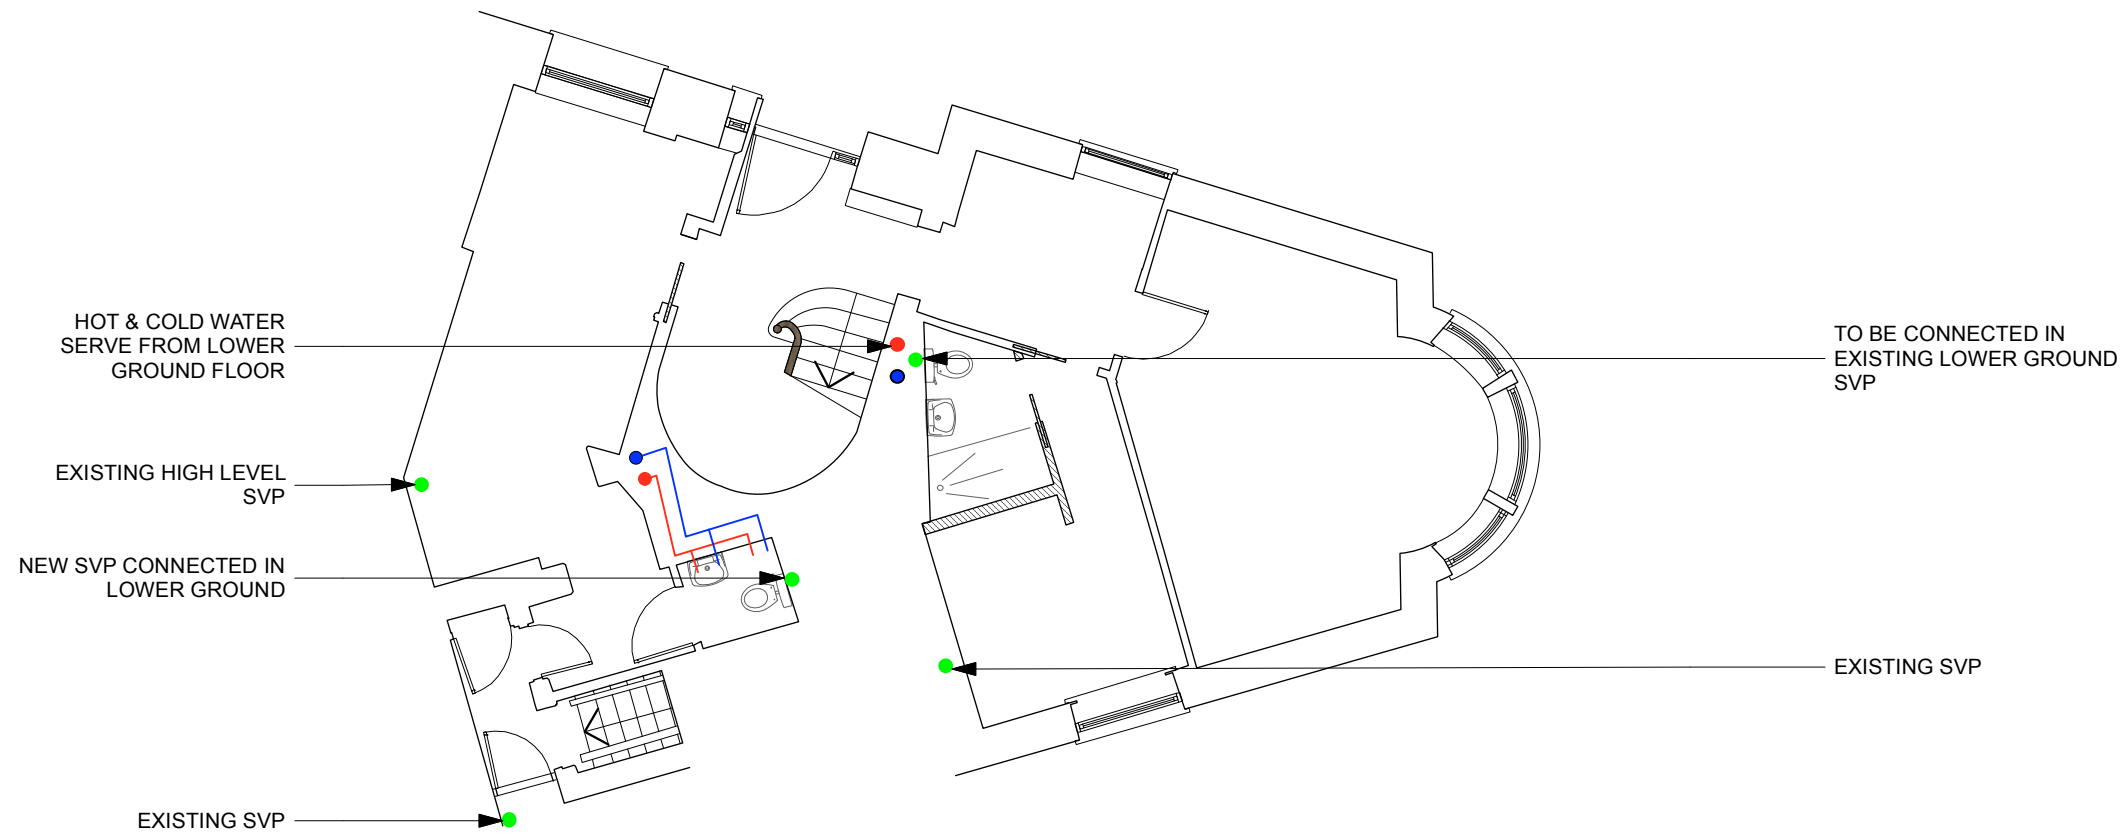

**1** Ground Floor  
Scale: 1:100



Project	
<b>1 West Halkin</b>	
Project Number	
<b>1083</b>	
Drawing Title	
<b>First Floor - Plumbing Plan</b>	
Paper Scale	Issue Date
<b>@ A3</b>	<b>16/08/23</b>

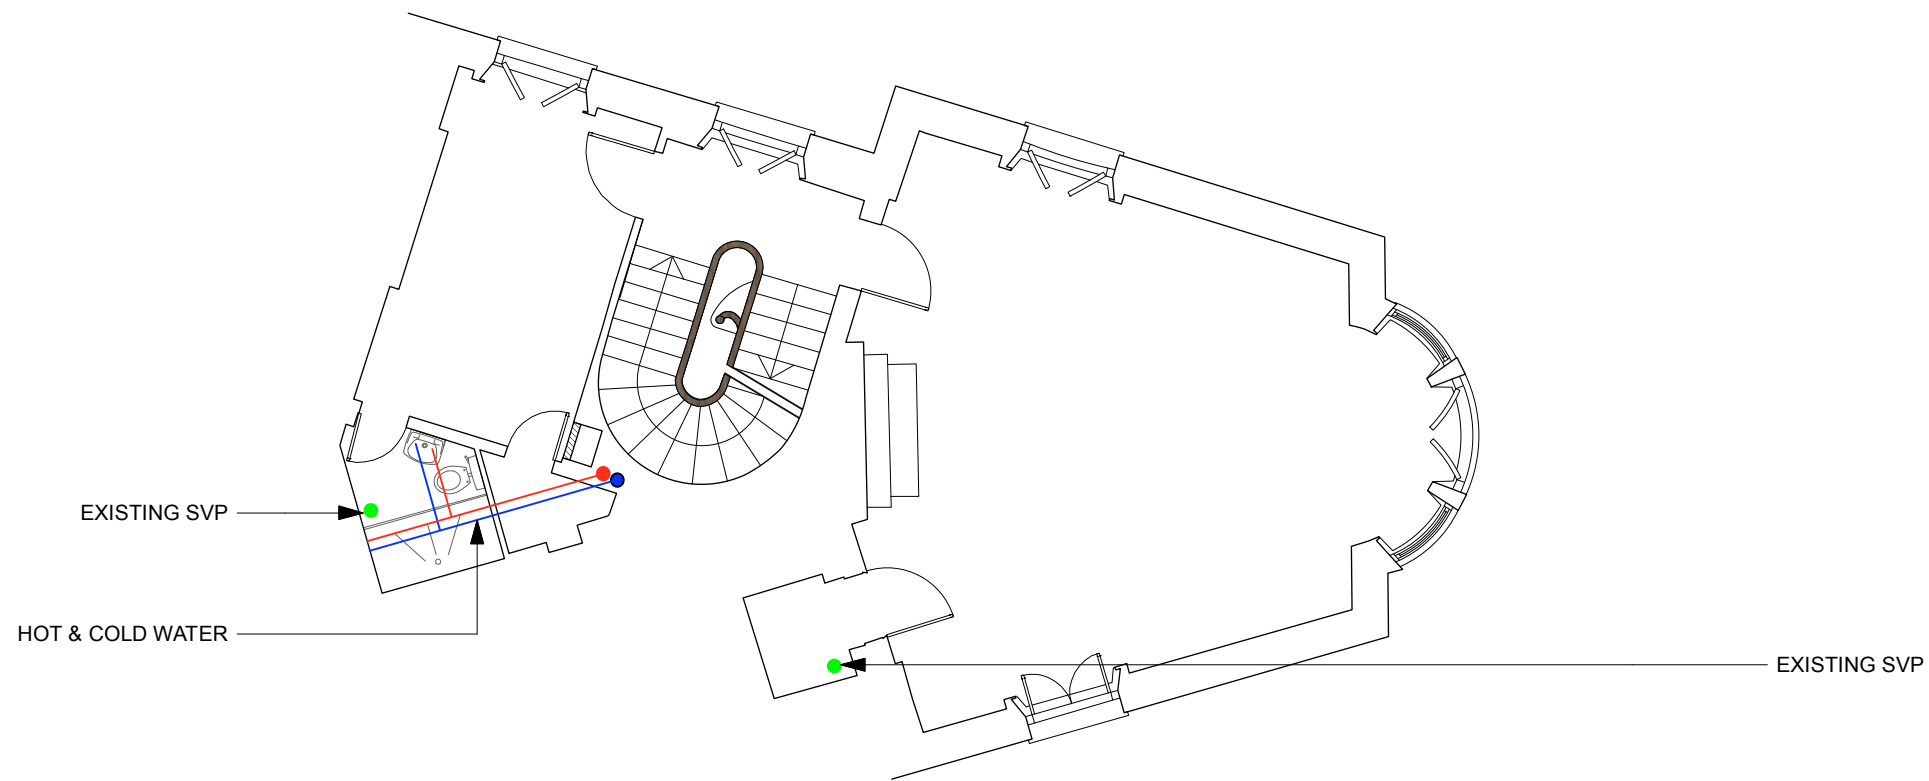

1 **First Floor**  
Scale: 1:100



Project

1 West Halkin

Project Number

1083

Drawing Title


Second Floor - Plumbing Plan

Paper Scale

@ A3

Issue Date

16/08/23

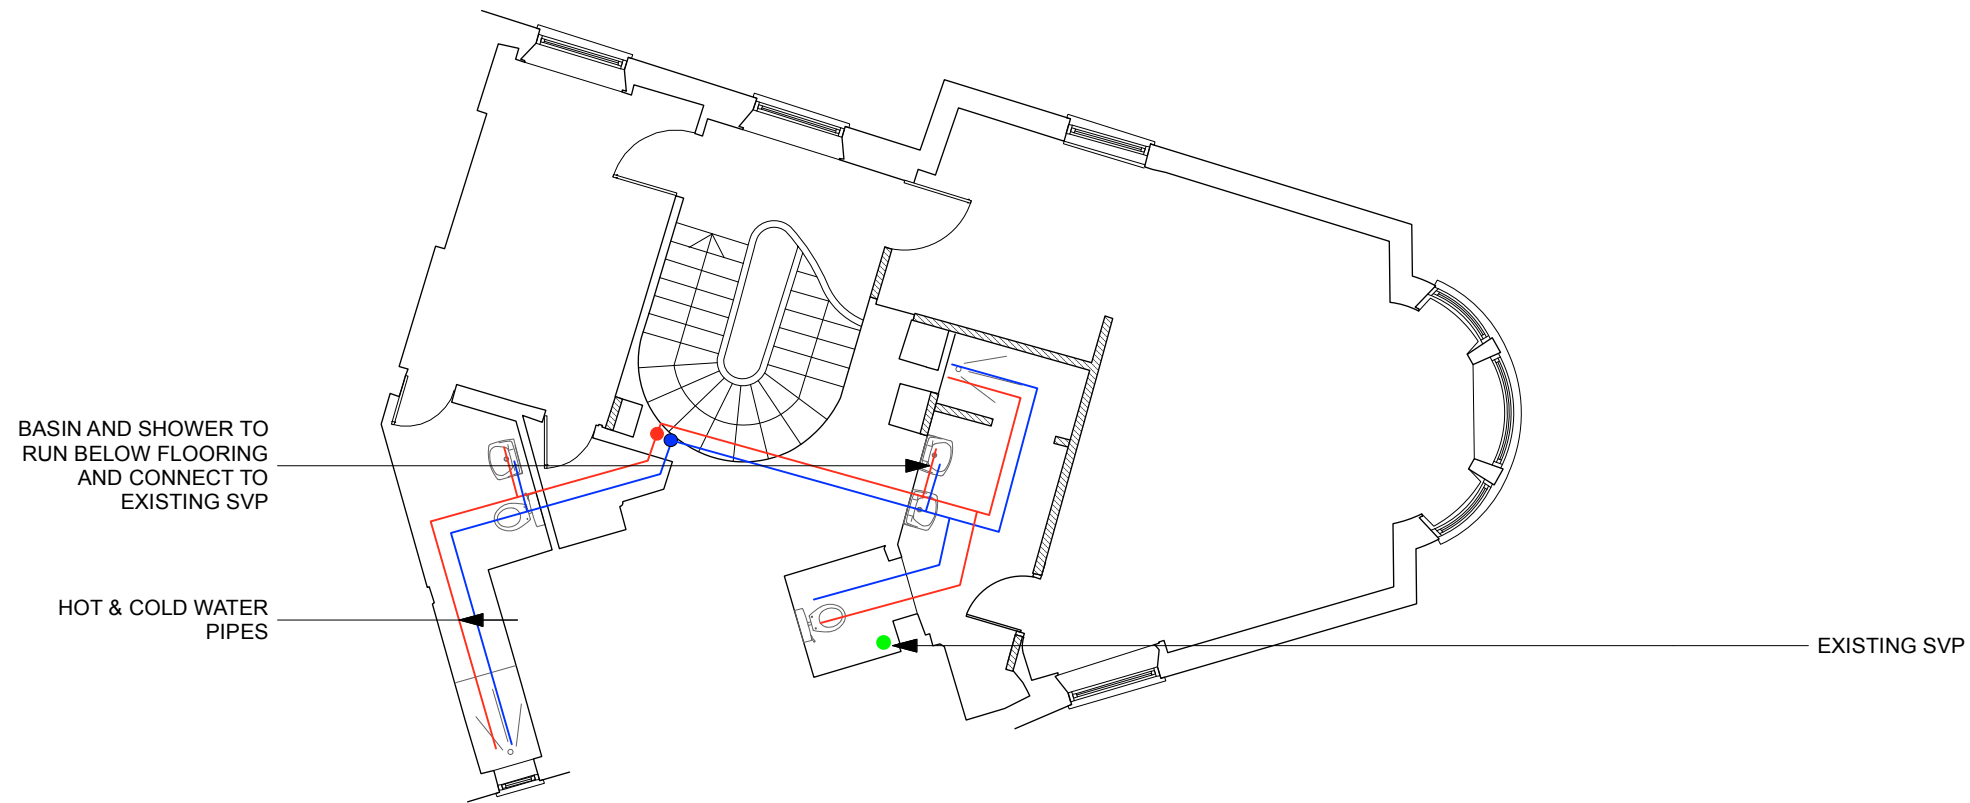

1 Second Floor  
Scale: 1:100



**DESIGN & THAT**

177 Victoria Park Road, E9 7JN  
Phone +44 (0) 7891611379

www.designandthat.com  
hello@designandthat.com