


Sewage Works

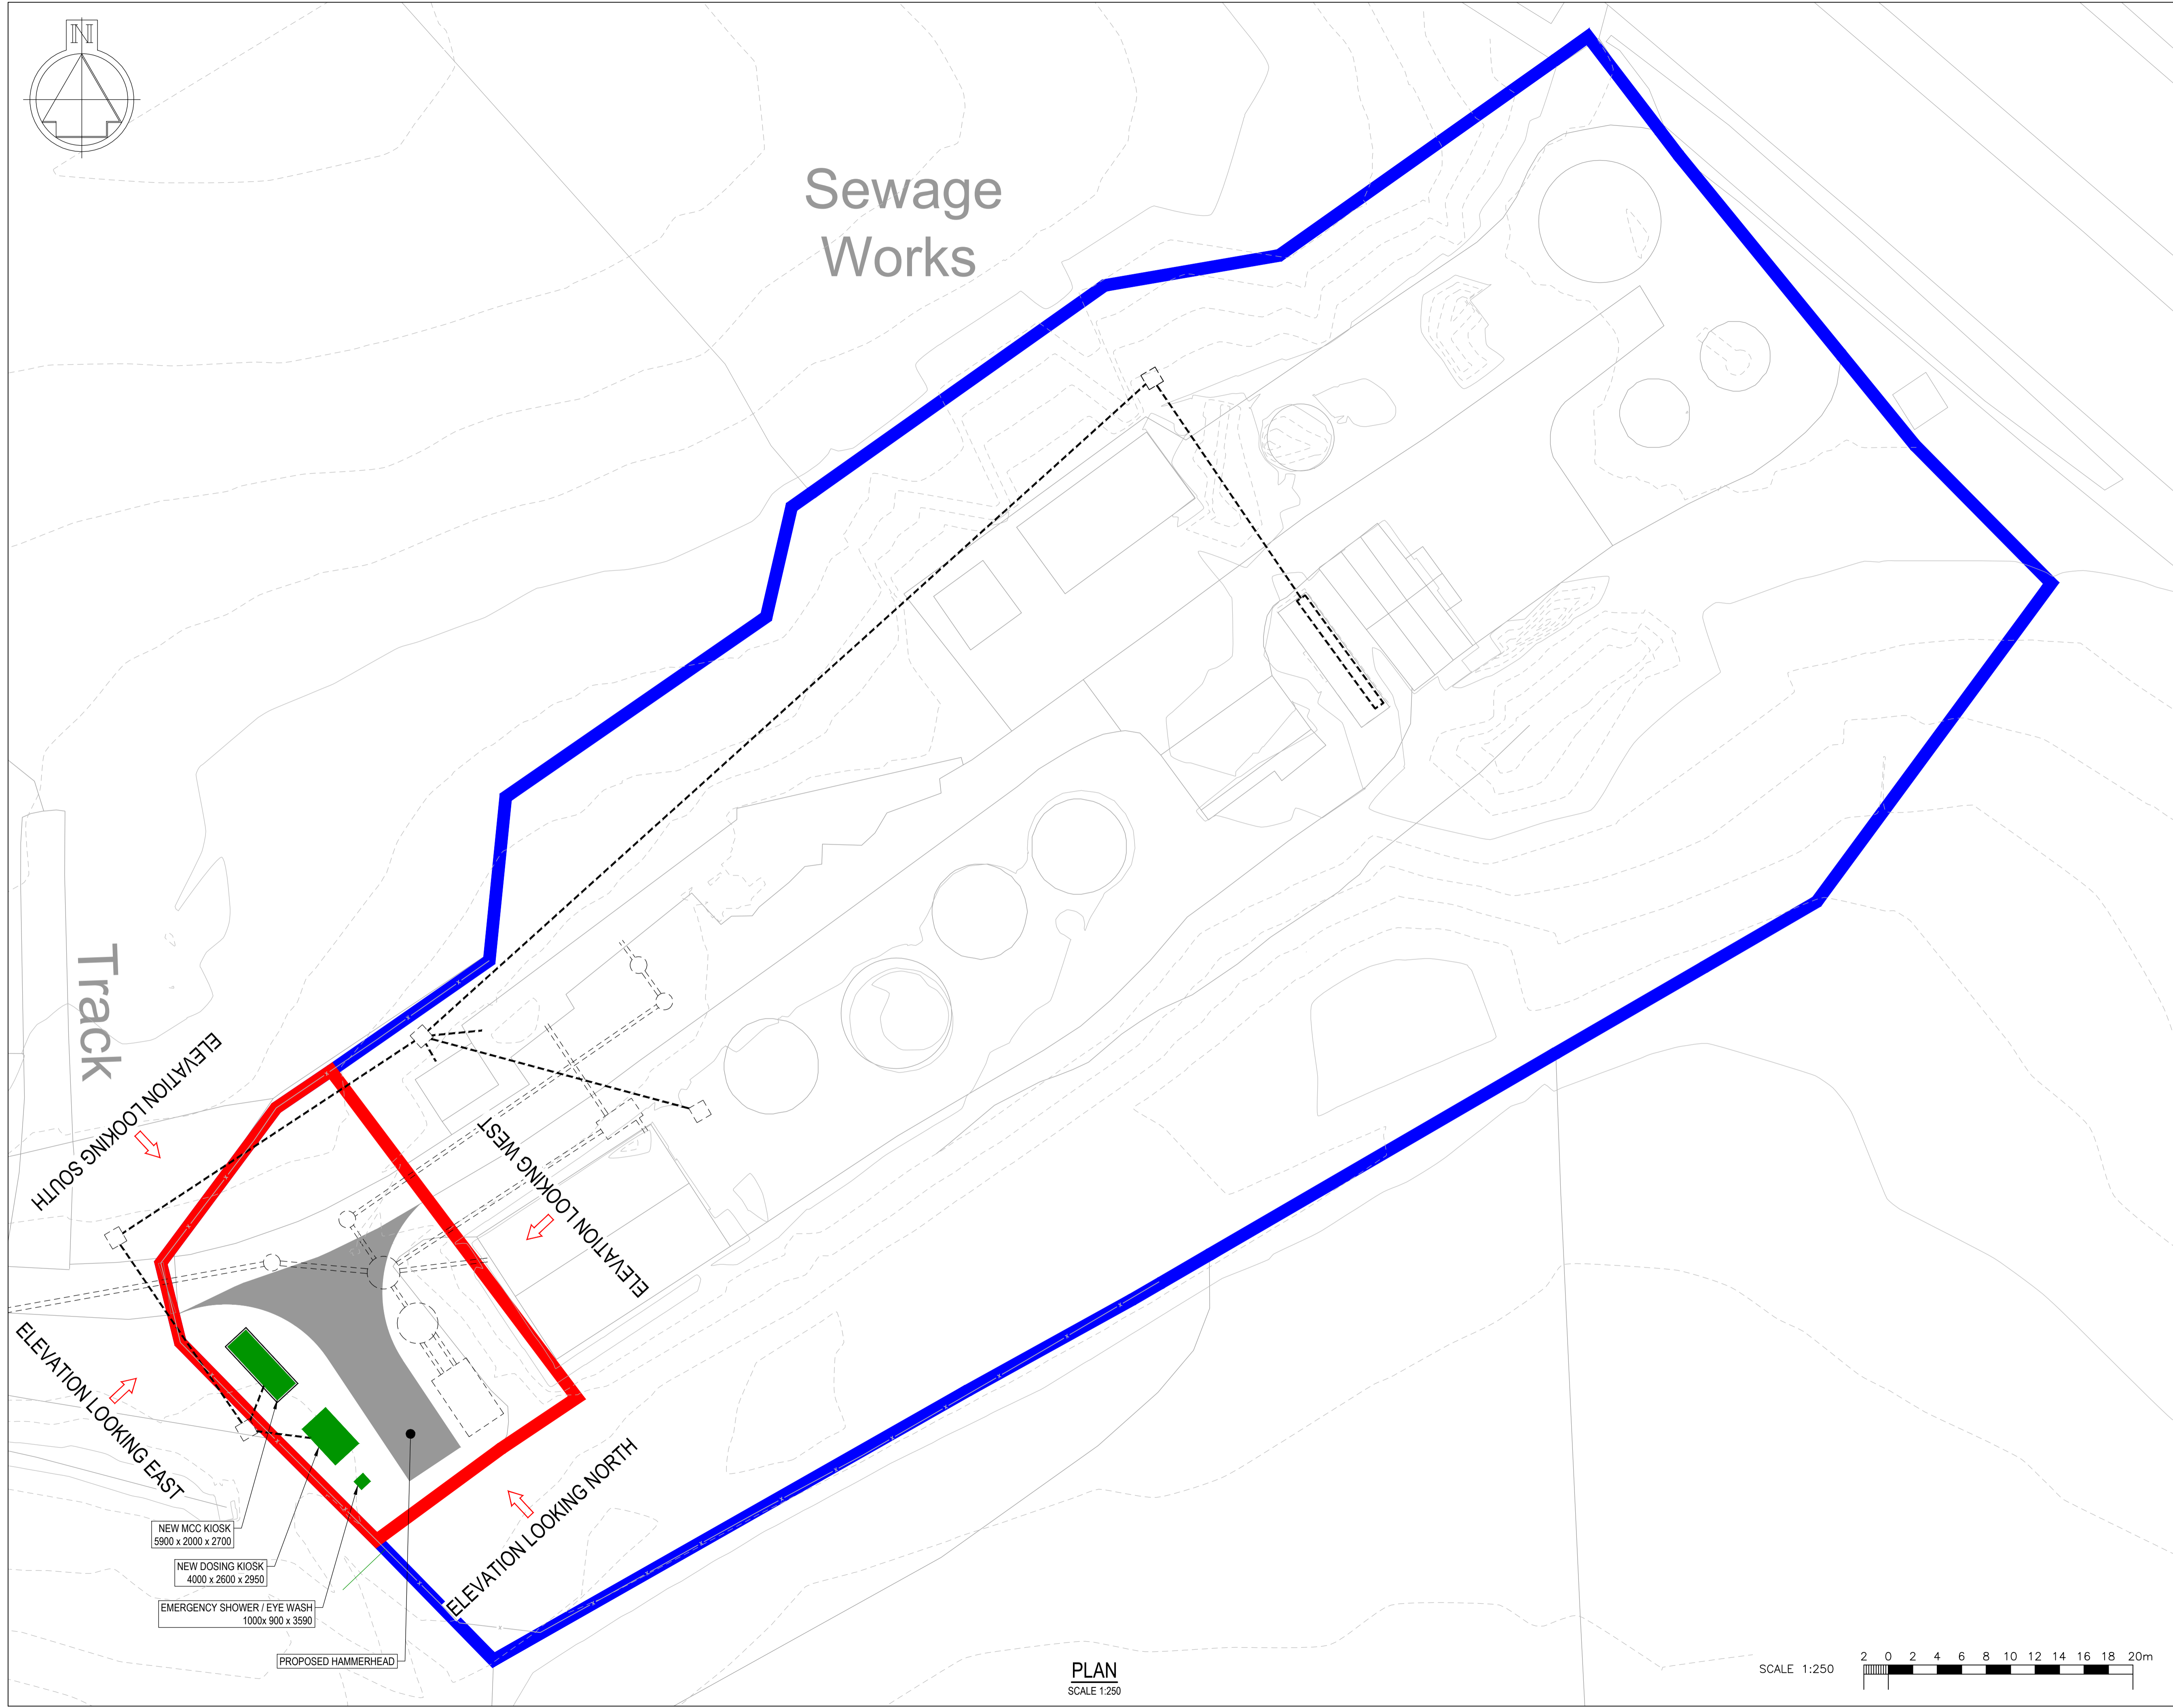

- NOTES:**
1. ALL DIMENSIONS IN MILLIMETRES AND ALL LEVELS IN METRES UNLESS SHOWN OTHERWISE.
 2. ALL DIMENSIONS AND LEVELS TO BE CHECKED ON SITE AND ANY DISCREPANCIES IDENTIFIED SHOULD BE REPORTED TO THE DESIGN ENGINEER PRIOR TO COMMENCEMENT OF WORK.
 3. ALL LEVELS IN METRES (m) ABOVE ORDNANCE DATUM (AOD).

LEGEND:

	RED LINE BOUNDARY NEW DEVELOPMENT AREA = 0.055 ha
	BLUE LINE BOUNDARY SW LAND OWNERSHIP AREA = 0.889 ha
	PROPOSED HAMMERHEAD
	PROPOSED GRP KIOSKS
	PERIMETER FENCE
	NEW SEWER PIPE
	NEW UNDERGROUND STRUCTURES
	NEW CABLE DUCTS

- REFERENCES:**
- 5206850000-CWA-XX-XX-DR-C-710001 - PLANNING APPLICATION SITE LOCATION PLAN
 - 5206850000-CWA-XX-XX-DR-C-720001 - PLANNING APPLICATION ELEVATIONS
 - 5206850000-CWA-XX-XX-DR-C-750001 - PLANNING APPLICATION MCC KIOSK GENERAL ARRANGEMENT
 - 5206850000-CWA-XX-XX-DR-C-750002 - PLANNING APPLICATION DOSING KIOSK GENERAL ARRANGEMENT
 - 5206850000-CWA-XX-XX-DR-C-750003 - PLANNING APPLICATION EYE WASH GENERAL ARRANGEMENT

Rev	Description	Drawn	Chk'd	Rev'd	App'd	Date
P01	For Information	DZ	SJF	SJF	RW	01/11/20

This drawing is the property of Scottish Water and must not be copied or used for any purpose other than that for which it is supplied without the written consent of Scottish Water.
Copyright © Scottish Water

Scottish Water
Trusted to serve Scotland

SCOTTISH WATER
THE BRIDGE
6 BUCHANAN GATE,
GLASGOW, G3 6FB
TEL: 0800 0778778

CALEDONIA WATER ALLIANCE
1st FLOOR, BUCHANAN TOWER,
BUCHANAN BUSINESS PARK,
CUMBERNAULD ROAD,
STEPPS,
GLASGOW, G33 6HZ
TEL: 0141 212 6610

Scale:	Status:	Suitability:
	S2	Suitable for information

Project Title: Plan to Cowie Pipeline

Drawing Title: Planning Application Site Plan

Ellipse Equipment No.	Autocode No.	520685
Drawing No.	REV.	

5206850000-CWA-XX-XX-DR-C-710002 P01

PLAN
SCALE 1:250

