


1 : 500

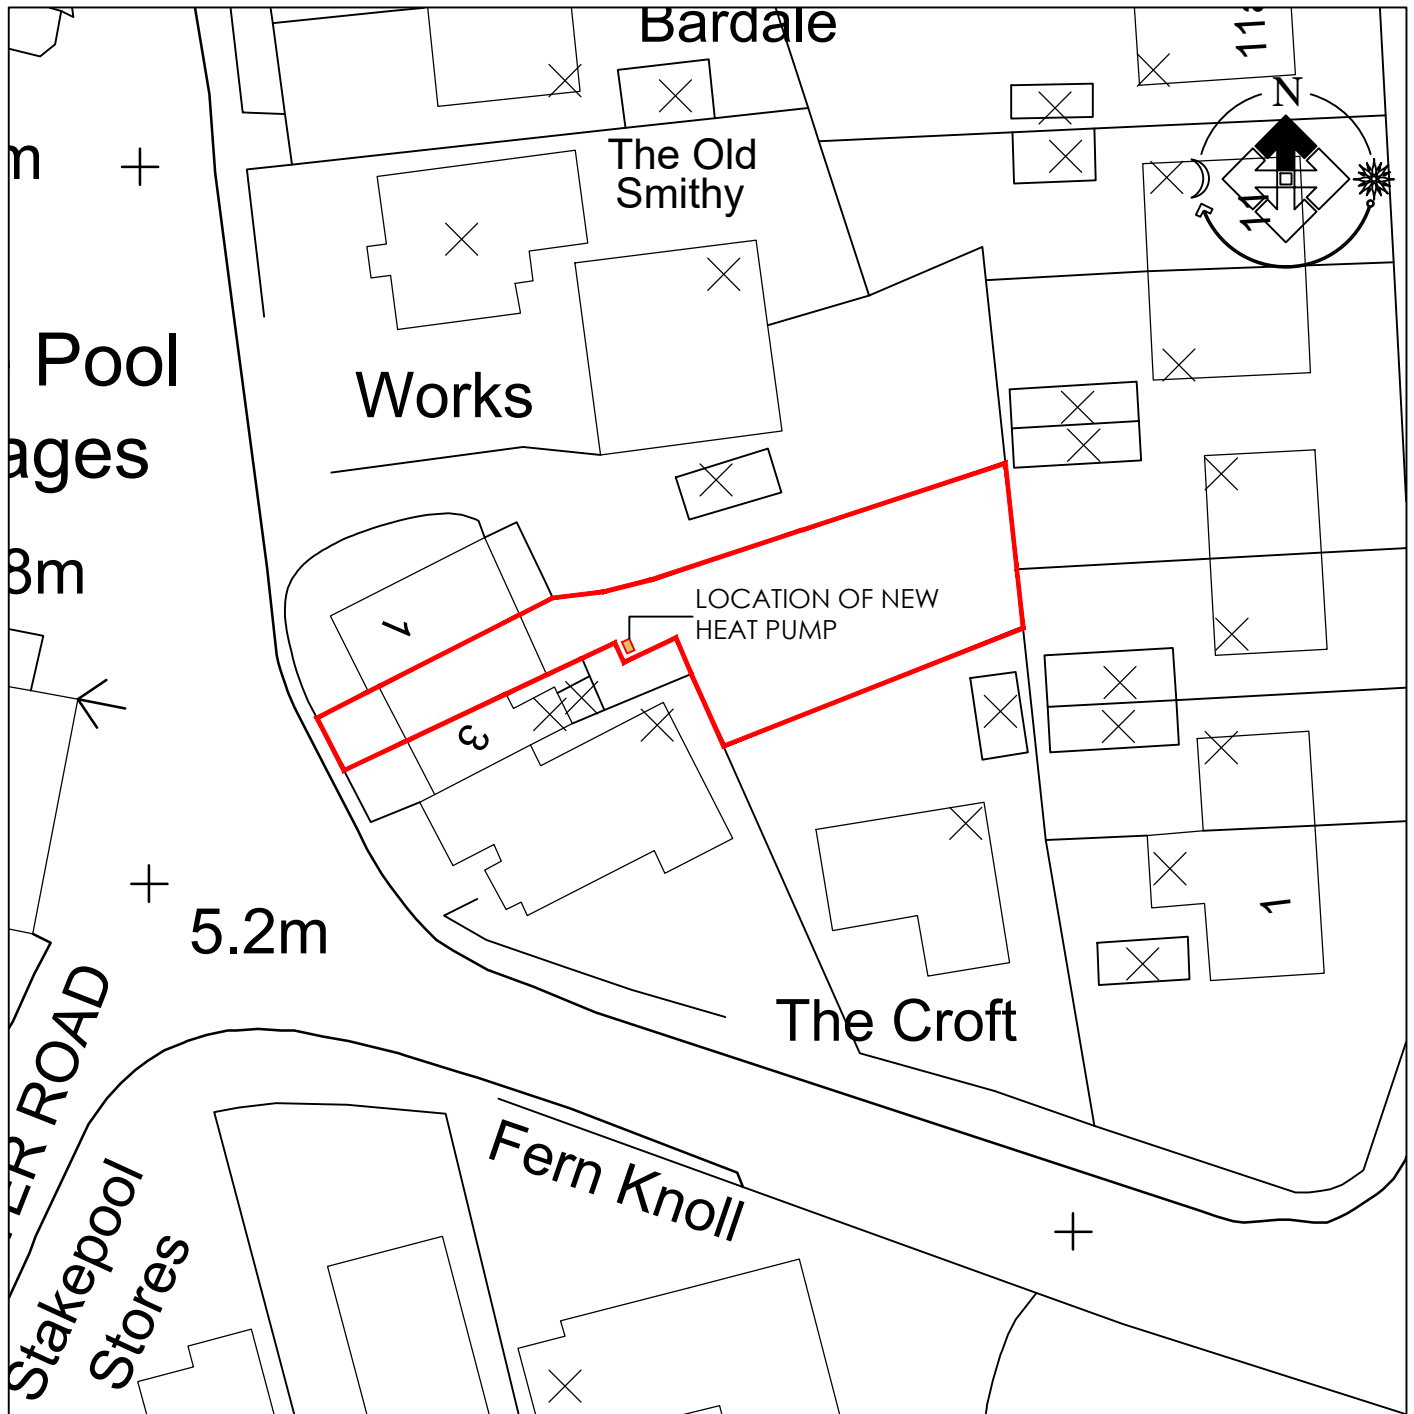

PLANNING

Client:
Mr Steven Kerry

Project:
Proposed Air Source Heat Pump

Drawing Title:
Proposed Site Plan
2 Stakepool Cottage, Pilling



9 clover drive, freckleton, preston, lancashire pr4 1tg
tel: 07773 014899 email info@clover-design.co.uk

Drawn: MS	Checked:	Scale: 1:500	Date: Nov 23
--------------	----------	-----------------	-----------------

Job No: 23-060	Drawing No: 1100	Rev:
-------------------	---------------------	------