

NOTES :-
These drawings are solely for the purpose of seeking planning and building regulation approvals, they are not a specification of work and DAK draughting Ltd accepts no liability should they be used for any other purpose

All drawings are to be read in conjunction with specialist design elements and structural engineers notes. Any works carried out prior to approval is done at the clients / builders risk

The contractor is responsible for checking all scaled and stated dimensions prior to any activity commencing or orders being placed


Any boundaries shown on the plans are assumed location and the client / contractor must check the precise location of any boundaries prior to commencement and ensure work does not take place across boundaries or outside of any given approval

The client is responsible for ensuring all required approvals have been granted and all matters relating to Party walls have been resolved in accordance with the Party Wall act 1996 prior to commencing building works


All drainage layouts shown on the plans are indicative only

DAK Draughting Ltd will not be liable for the accuracy of any hidden details such as wall construction, lintels, existing beams, foundations, drainage etc. It is the responsibility of the client and the contractor to expose all hidden features prior to commencement of any building works


This drawing is the copyright of DAK Draughting Ltd and must not be copied, reproduced or replicated in any way without prior consent

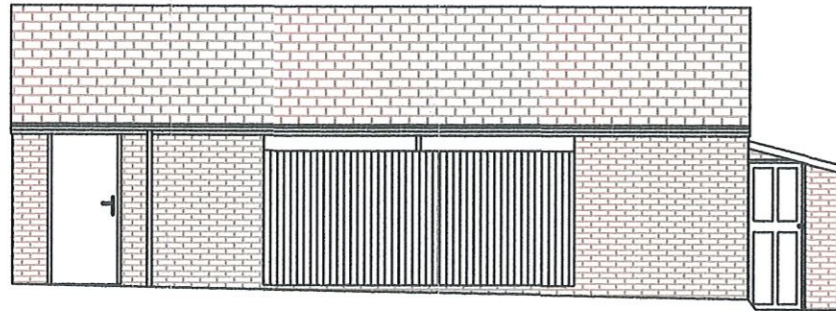


EXISTING FRONT ELEVATION

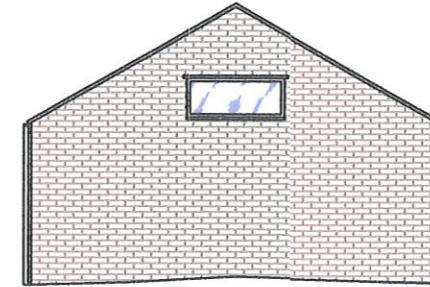

EXISTING SIDE ELEVATION 1

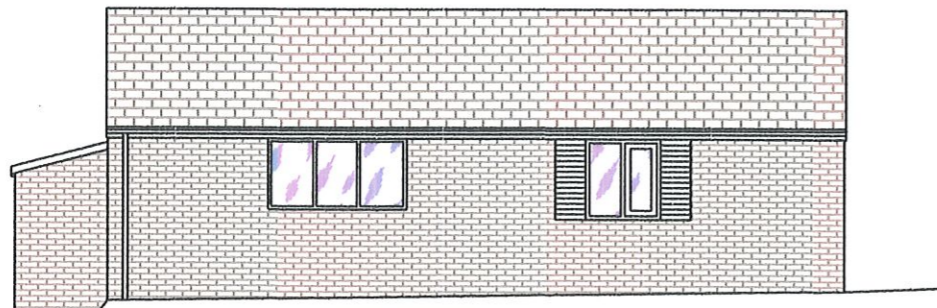

EXISTING REAR ELEVATION

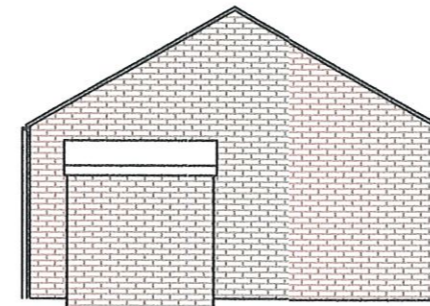

EXISTING SIDE ELEVATION 2

DAK Draughting

tele :- 01590 615139

CLIENT MR DAVID TREAIS
SITE 69 PRIORY ROAD
GOSPORT
PO12 4LF

DRAWING

EXISTING GARAGE ELEVATIONS

DRAWING No. DAK / PR / 06
SCALE 1 : 100 @ A3 (printed to scale)

DATE :- 14 / 08 / 2023 DRAWN BY:- DAK

