



LEGEND:-




ALPHA-ETEC HYBRID HEAT PUMP/AIR SOURCE PUMP.
845MM LONG
745MM TALL
350MM DEEP.
BROCHURE ATTACHED

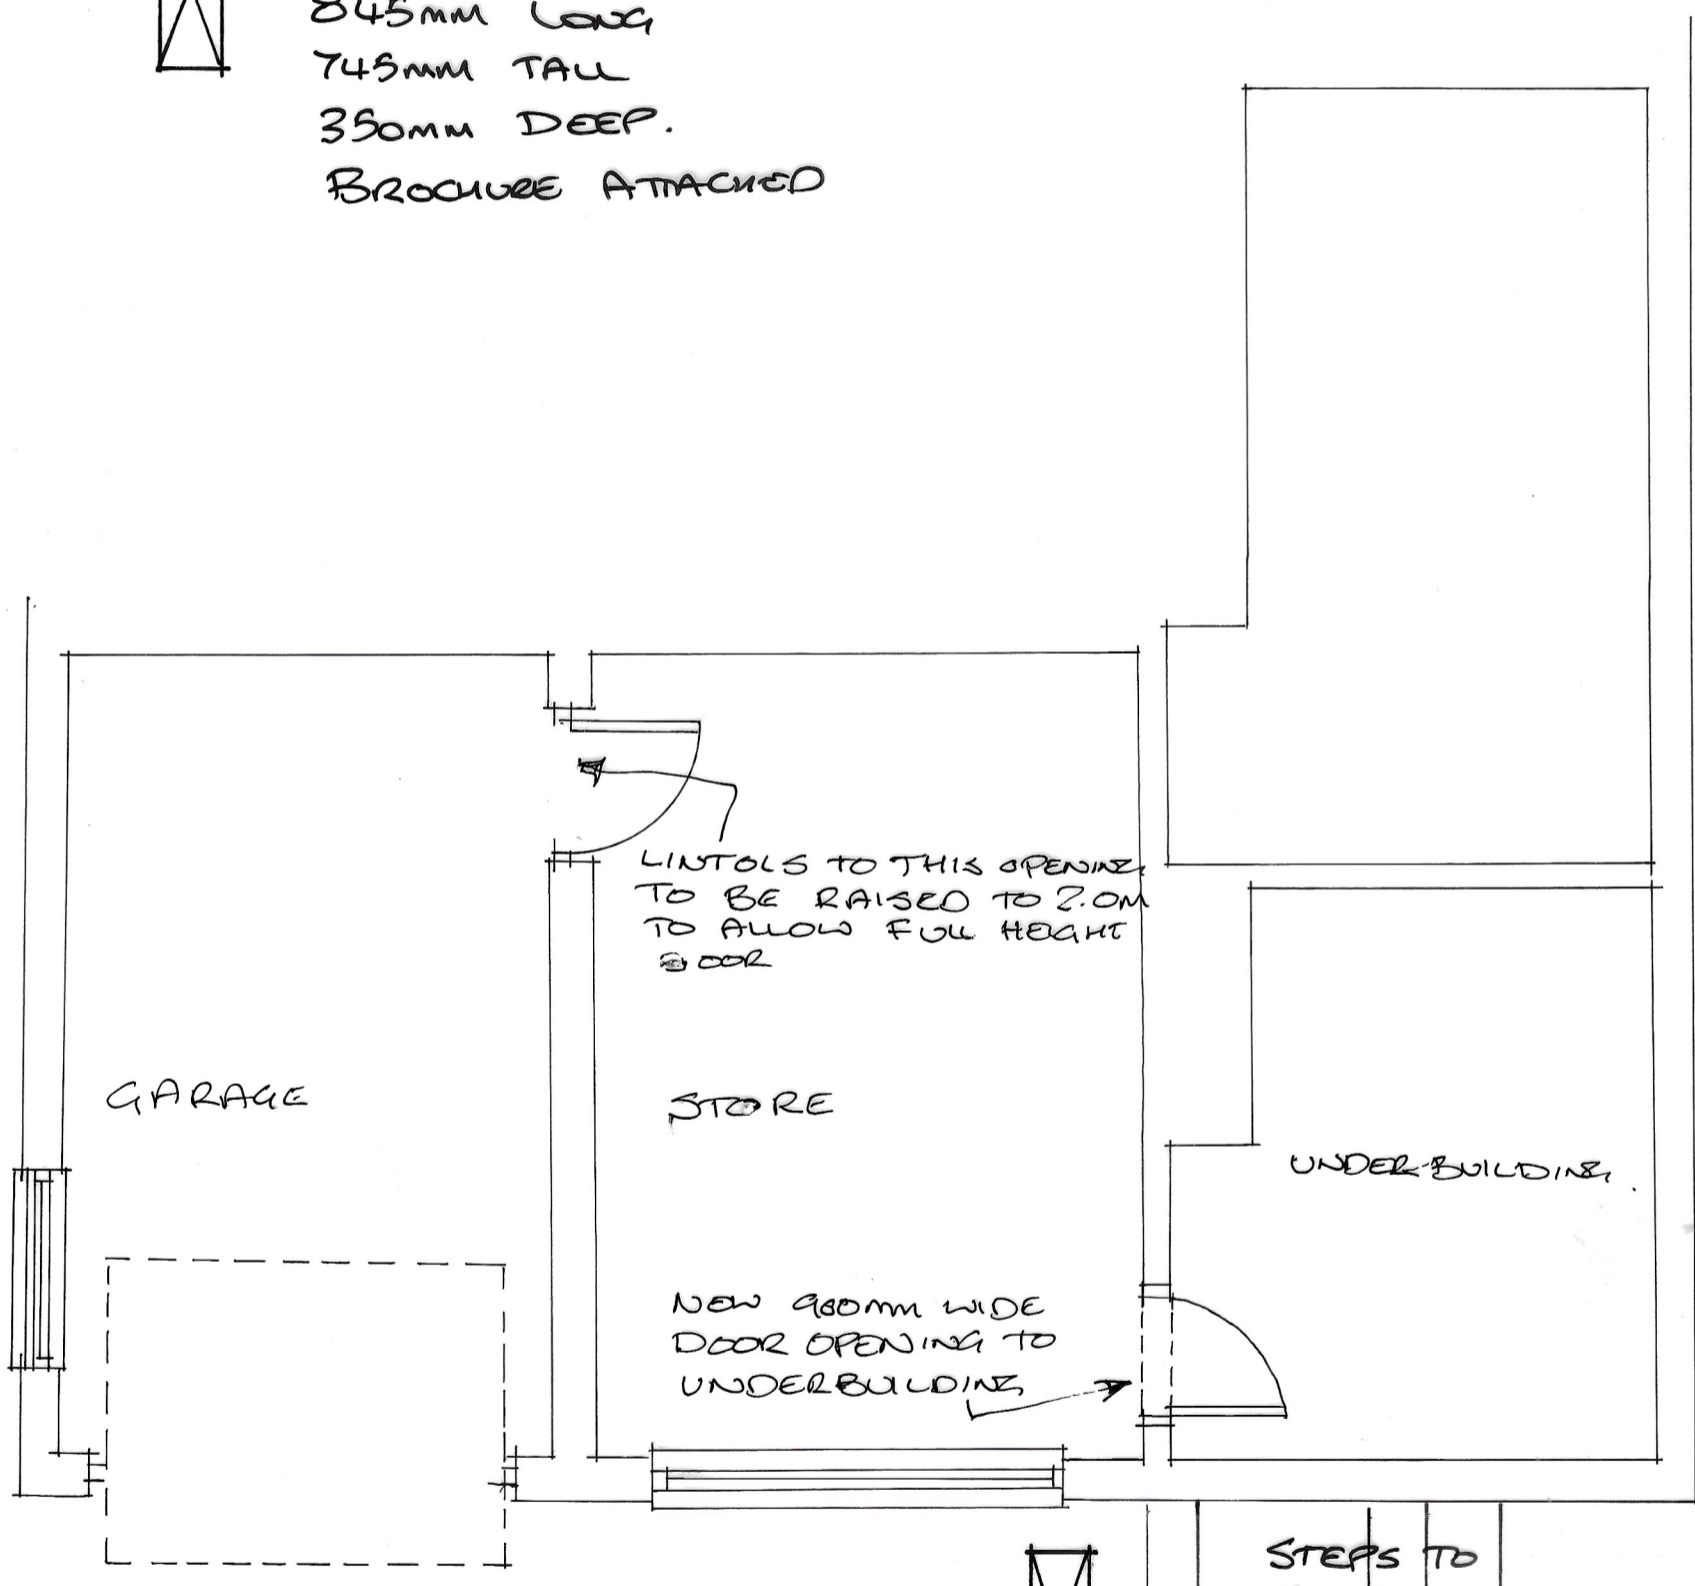

LOWER GROUND FLOOR PLAN

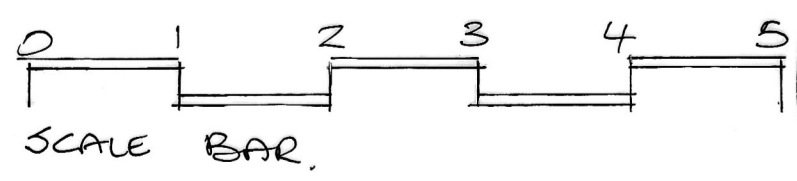

SCALE BAR.

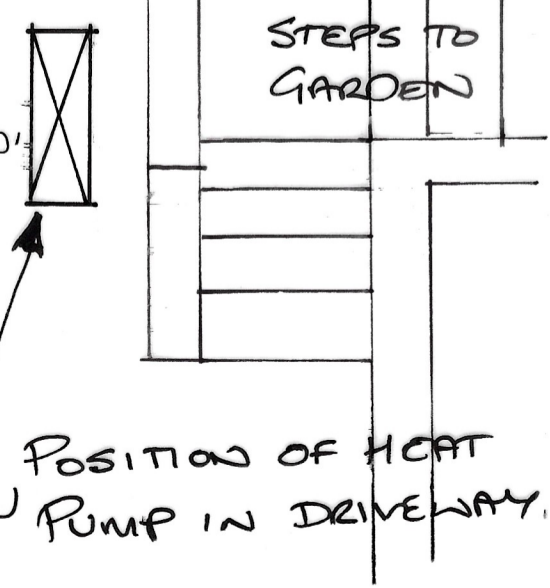

Proposed Alterations at:-

4 Birrell Road
Milngavie
G62 7JZ
As Proposed

For Mr. & Mrs Stewart
Scale 1:50
Drawing No. 09