

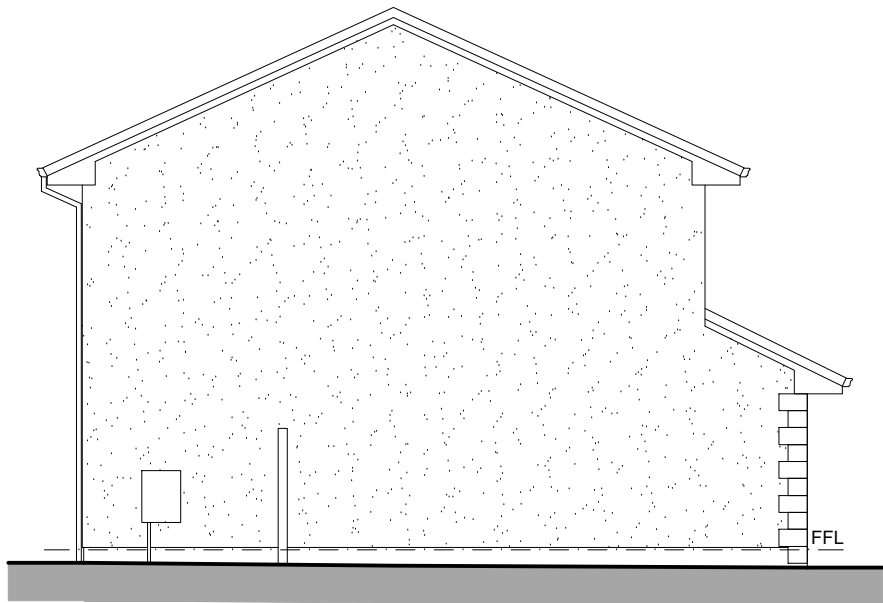



REAR ELEVATION
(1:100)

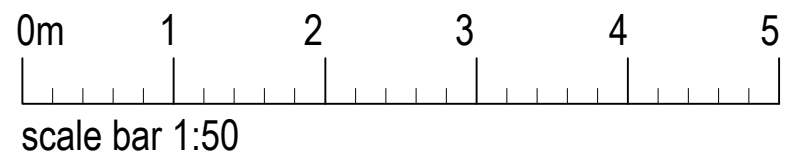

SIDE ELEVATION
(1:100)

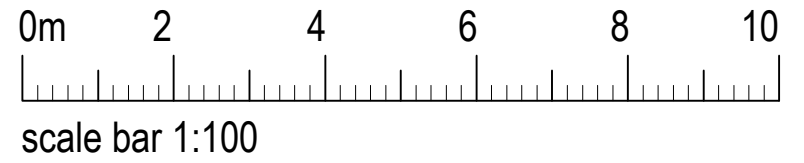

EXISTING SERVICES LEGEND	
	Double Switched Socket
	Radiator
	Single Light Switch
	Spotlight

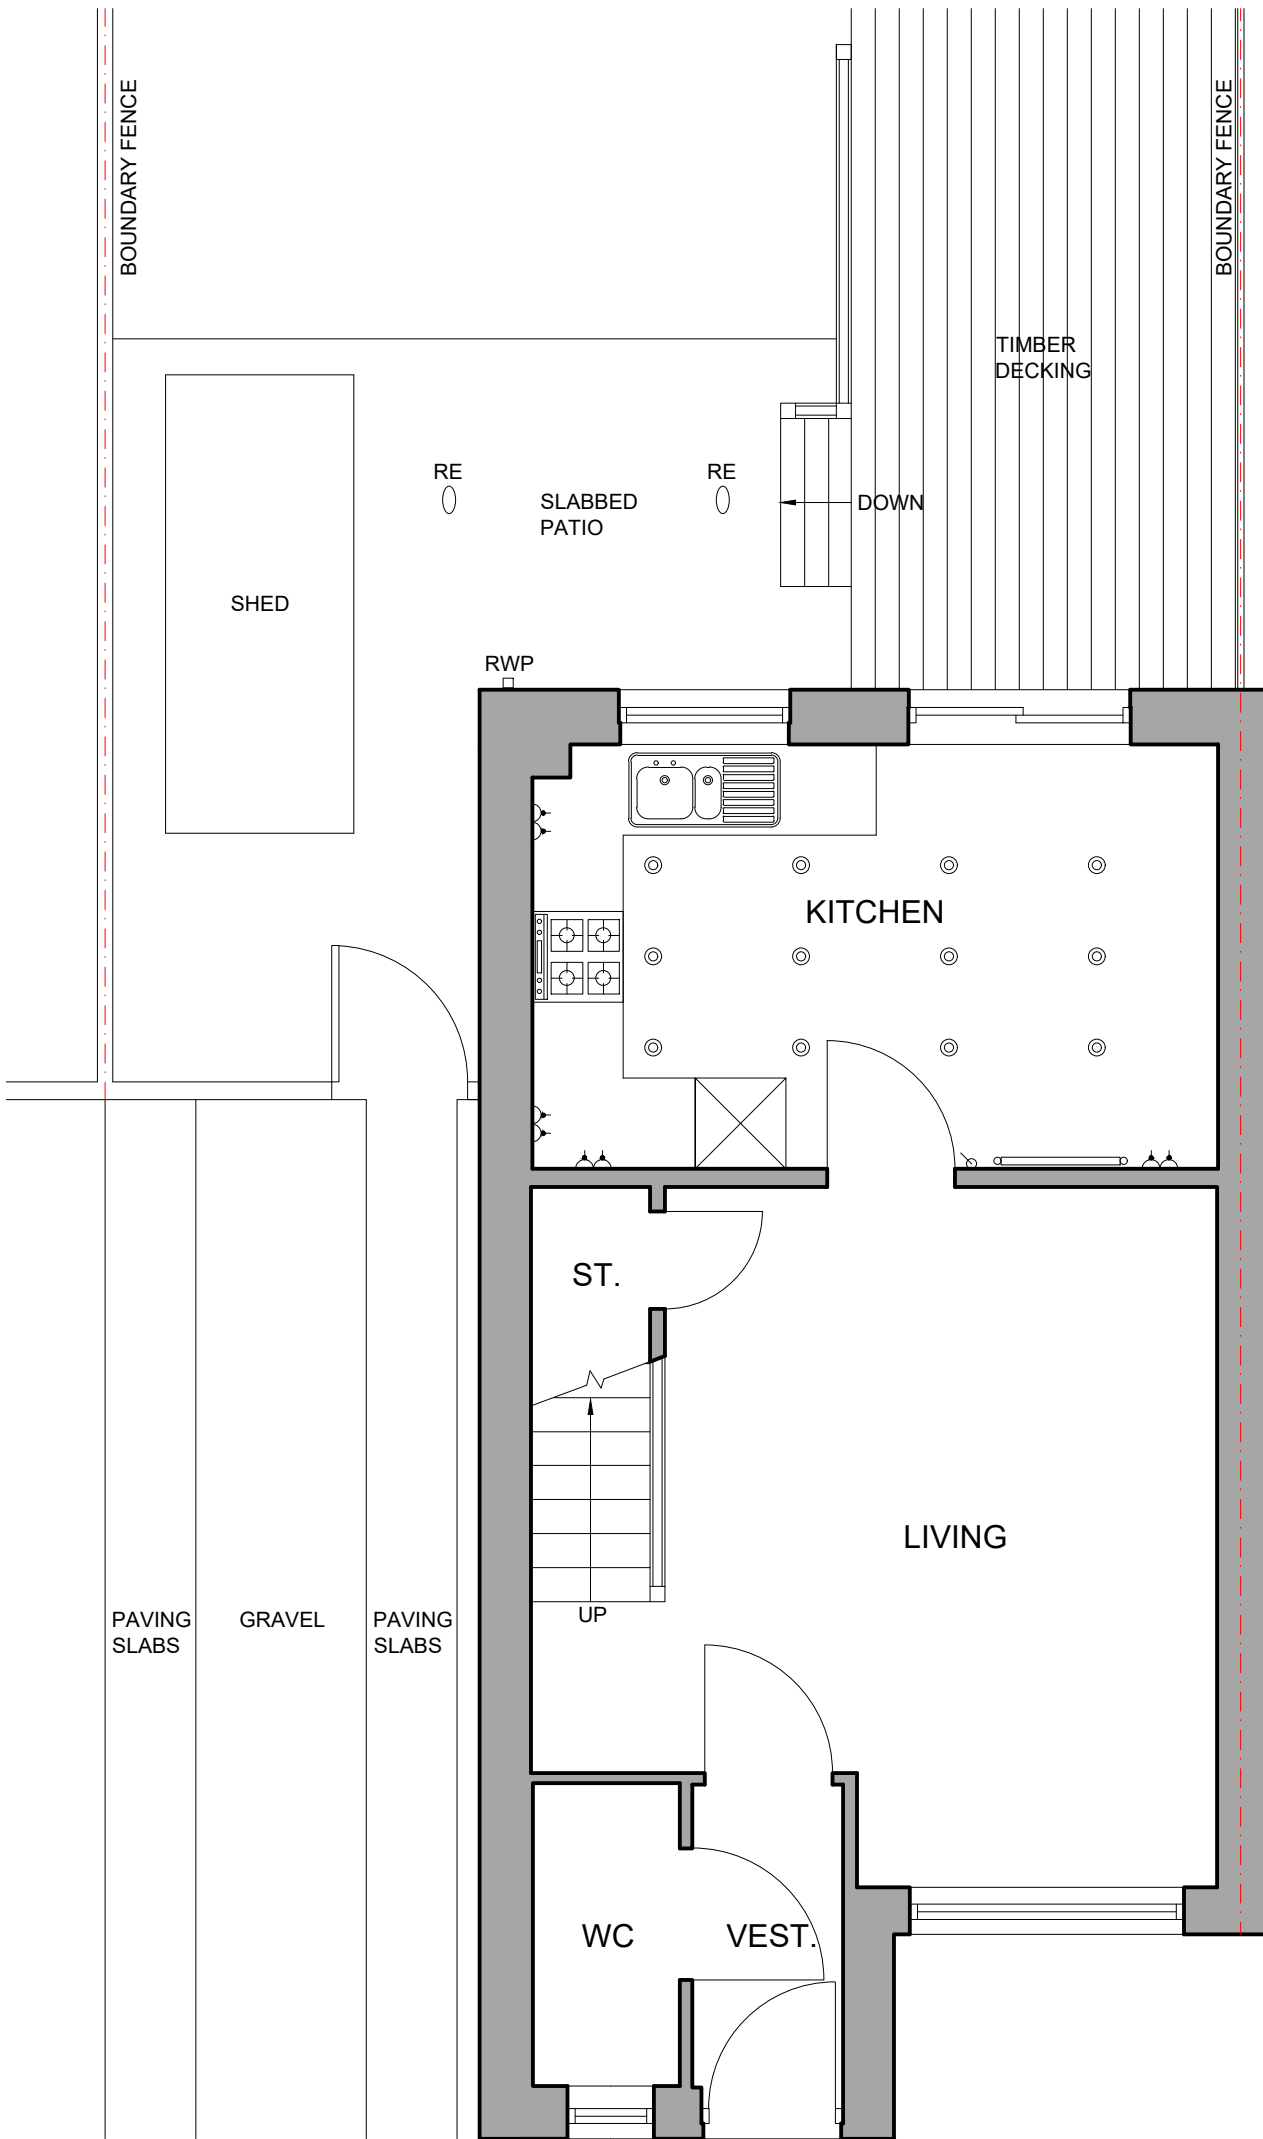

GROUND FLOOR PLAN (1:50)

AS EXISTING

DRAWING No. PL01	MR & MRS KINNEAR. PROPOSED EXTENSION TO 14 THE SHEILINGS, ALLOA, FK10 2NN.
SCALE 1:50, 1:100	