
 


BESS 33kV Switch Room [G007]

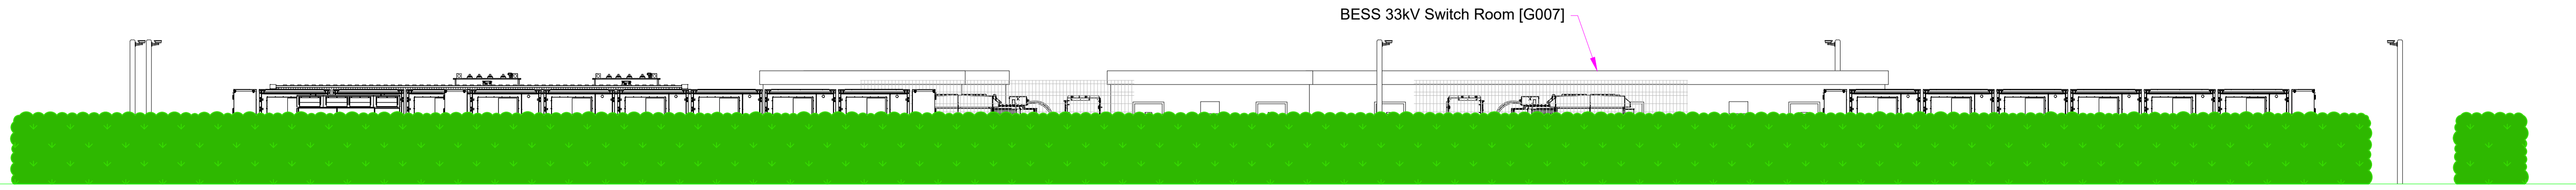

**SOUTH-WEST ELEVATION**  
scale 1:100 @A3



Battery Containers [G004]


BESS 33kV Switch Room [G007]

BESS Control Room [G010]

LV Auxiliary Switch Room [G010]

Auxiliary & Earthing Transformers [G008]

Spares Container [G002]

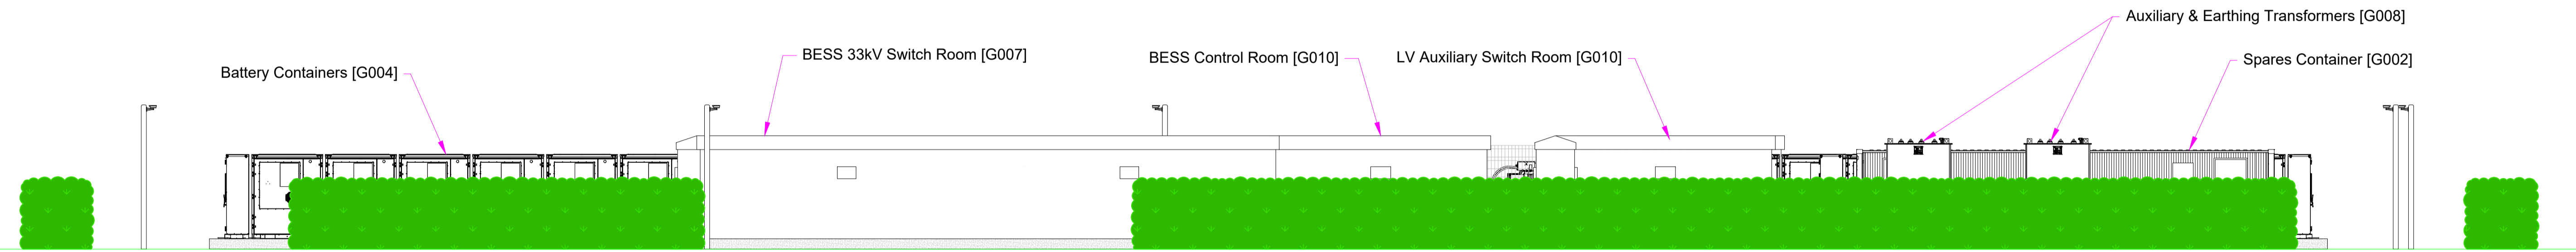


**NORTH-EAST ELEVATION**  
scale 1:100 @A3



Power Conversion System (PCS) & Transformer [G001]


Welfare Unit [G010]

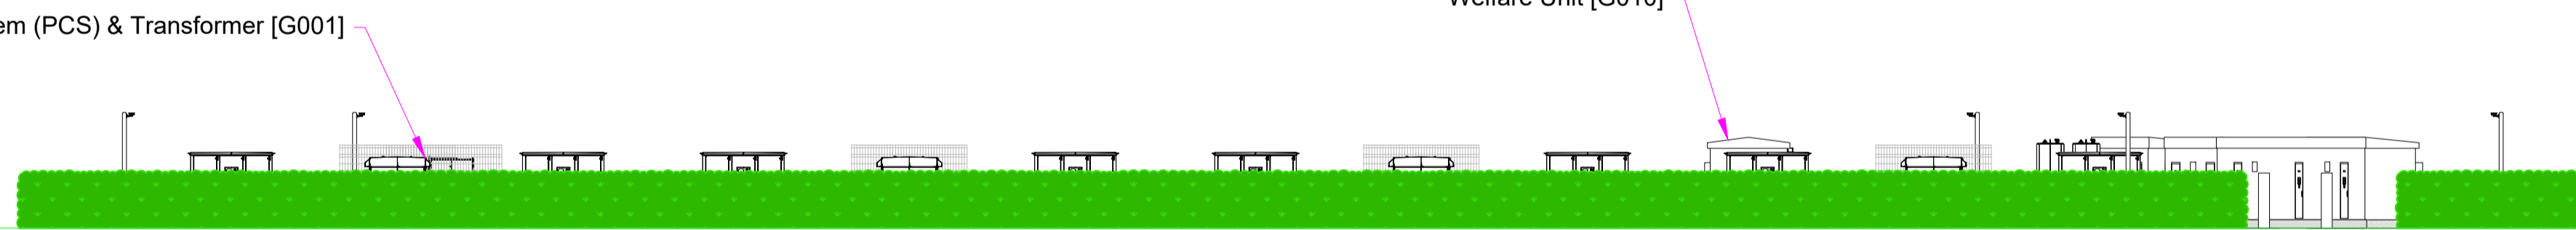

**SOUTH-EAST ELEVATION**  
scale 1:200 @A3



Power Conversion System (PCS) & Transformer [G001]

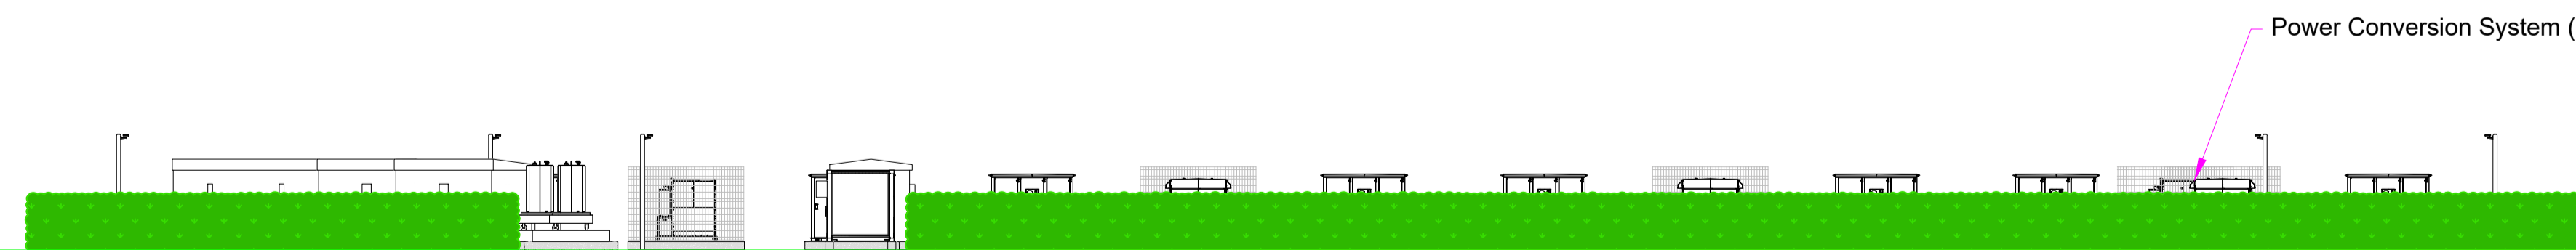

**NORTH-WEST ELEVATION**  
scale 1:200 @A3



C	Welfare unit repositioned	25.04.23	SS	CH
B	New layout & sheet template	22.03.23	SS	
A	33kV s/g & control room revised	08.07.21	SS	
-	First Issue	18.06.21	SS	
Rev	Description	Date	Checked	

Drawing No.

BRE-EDFR-TCL-DRG-E001

Project

Bredbury BESS

Title

Site Elevations

Scale 1:300 @A3

Drawn by SS  
Checked CH  
Date 25.04.23



W: [www.edf-re.uk](http://www.edf-re.uk)

A: Cardinal Place, 80 Victoria Street, London SW1E 5JL