




TRANSFORMER / RING MAIN UNIT SKID – PLAN VIEW

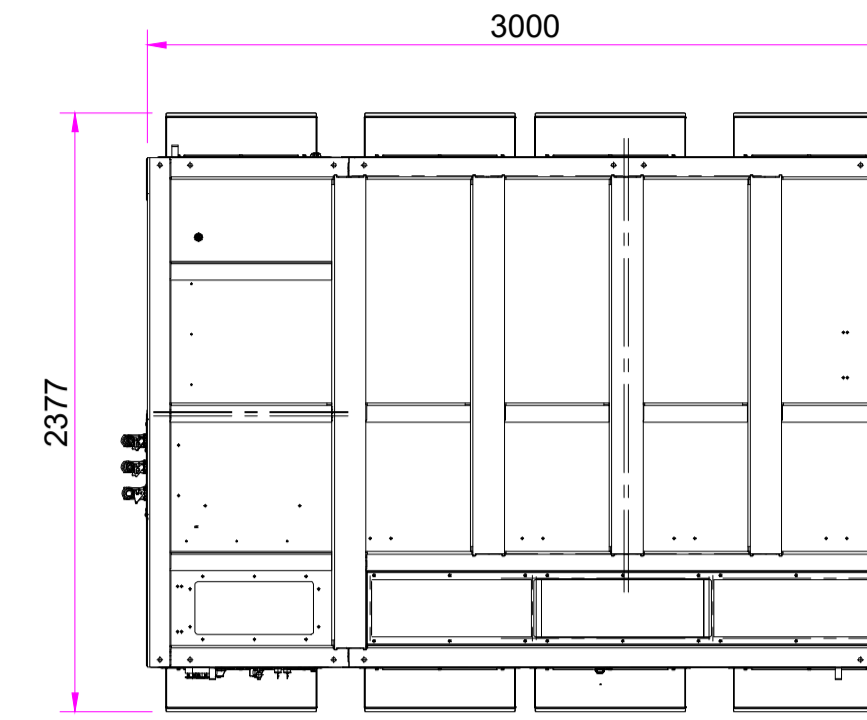


PCS INVERTER – PLAN VIEW

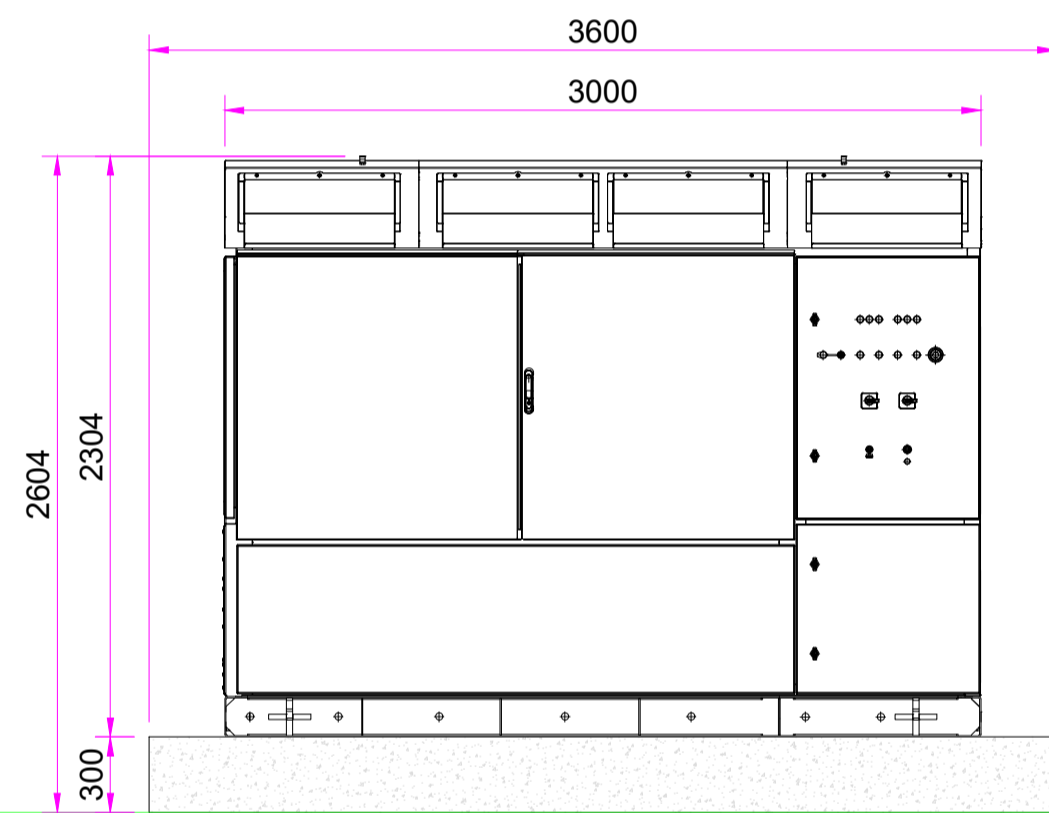


PCS INVERTER – FRONT ELEVATION

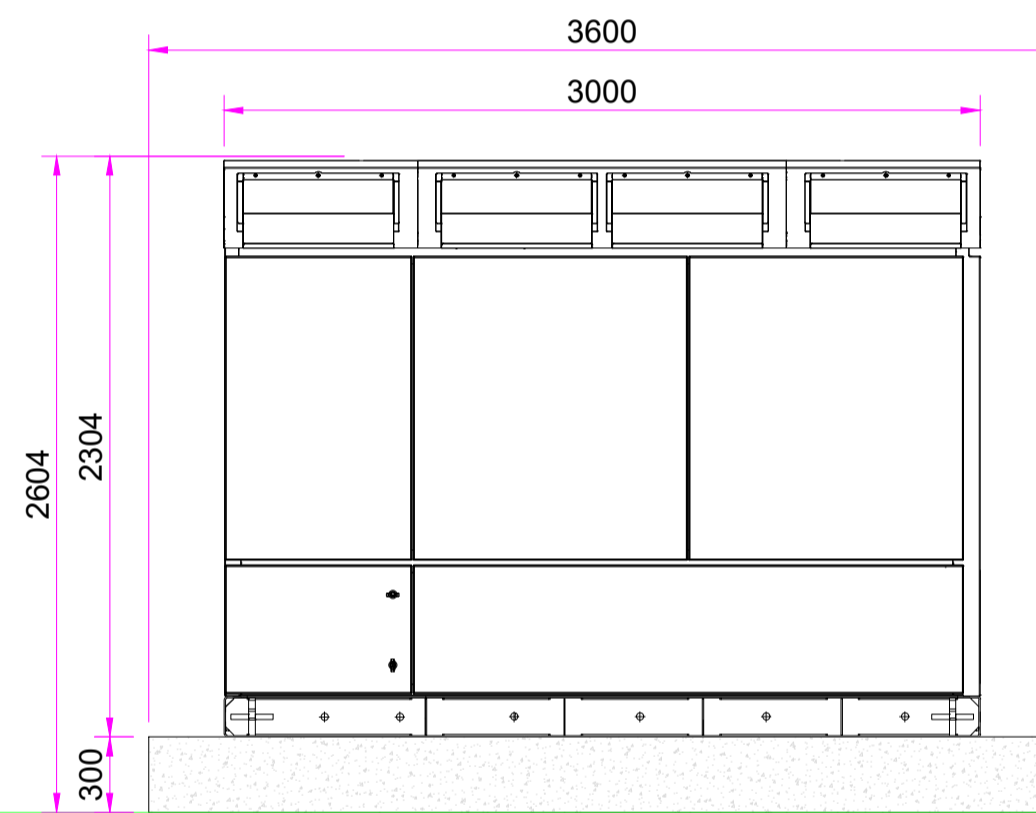


PCS INVERTER – REAR ELEVATION

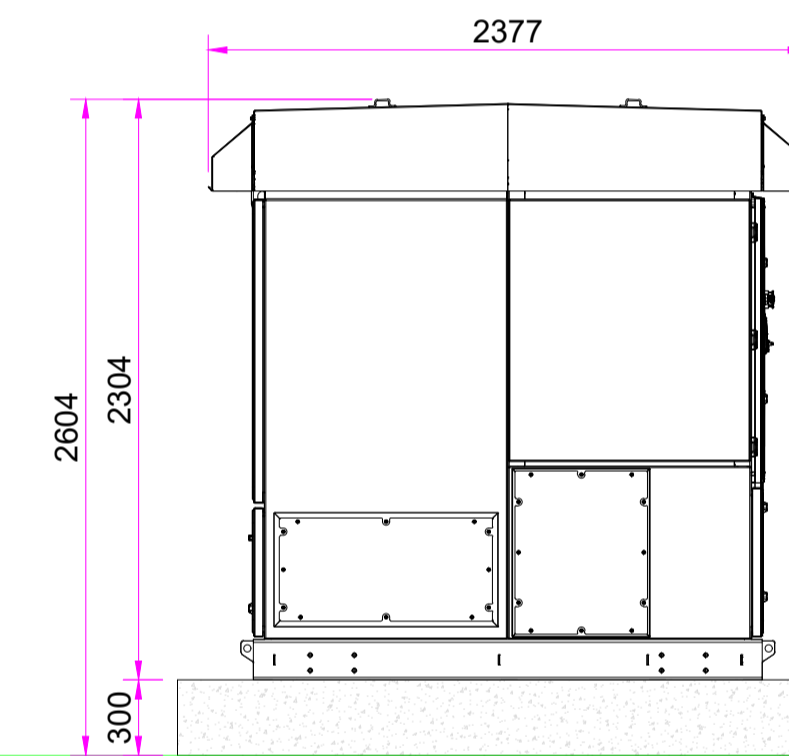

PCS INVERTER – SIDE ELEVATIONS

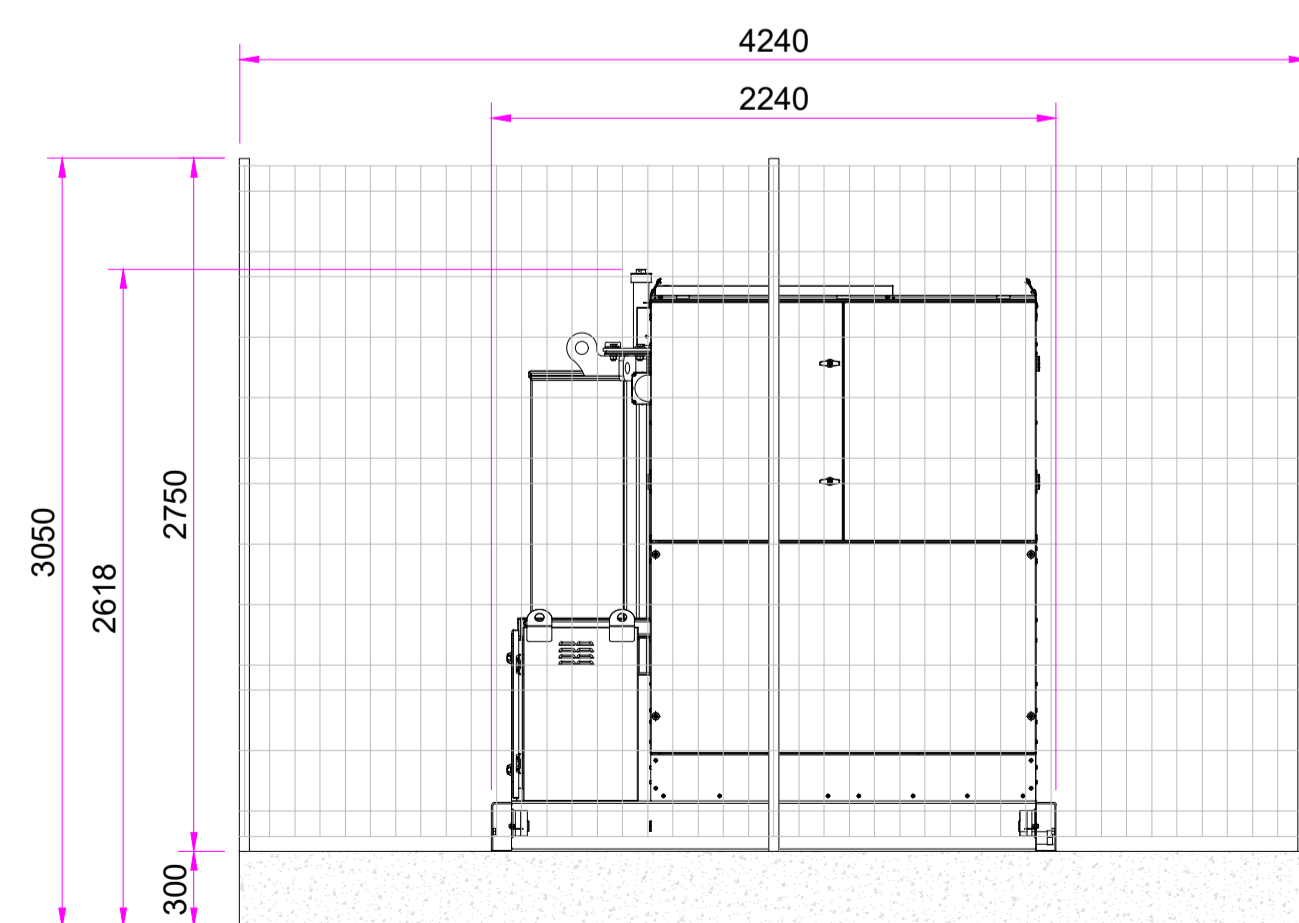

TRANSFORMER / RING MAIN UNIT SKID – SIDE ELEVATIONS

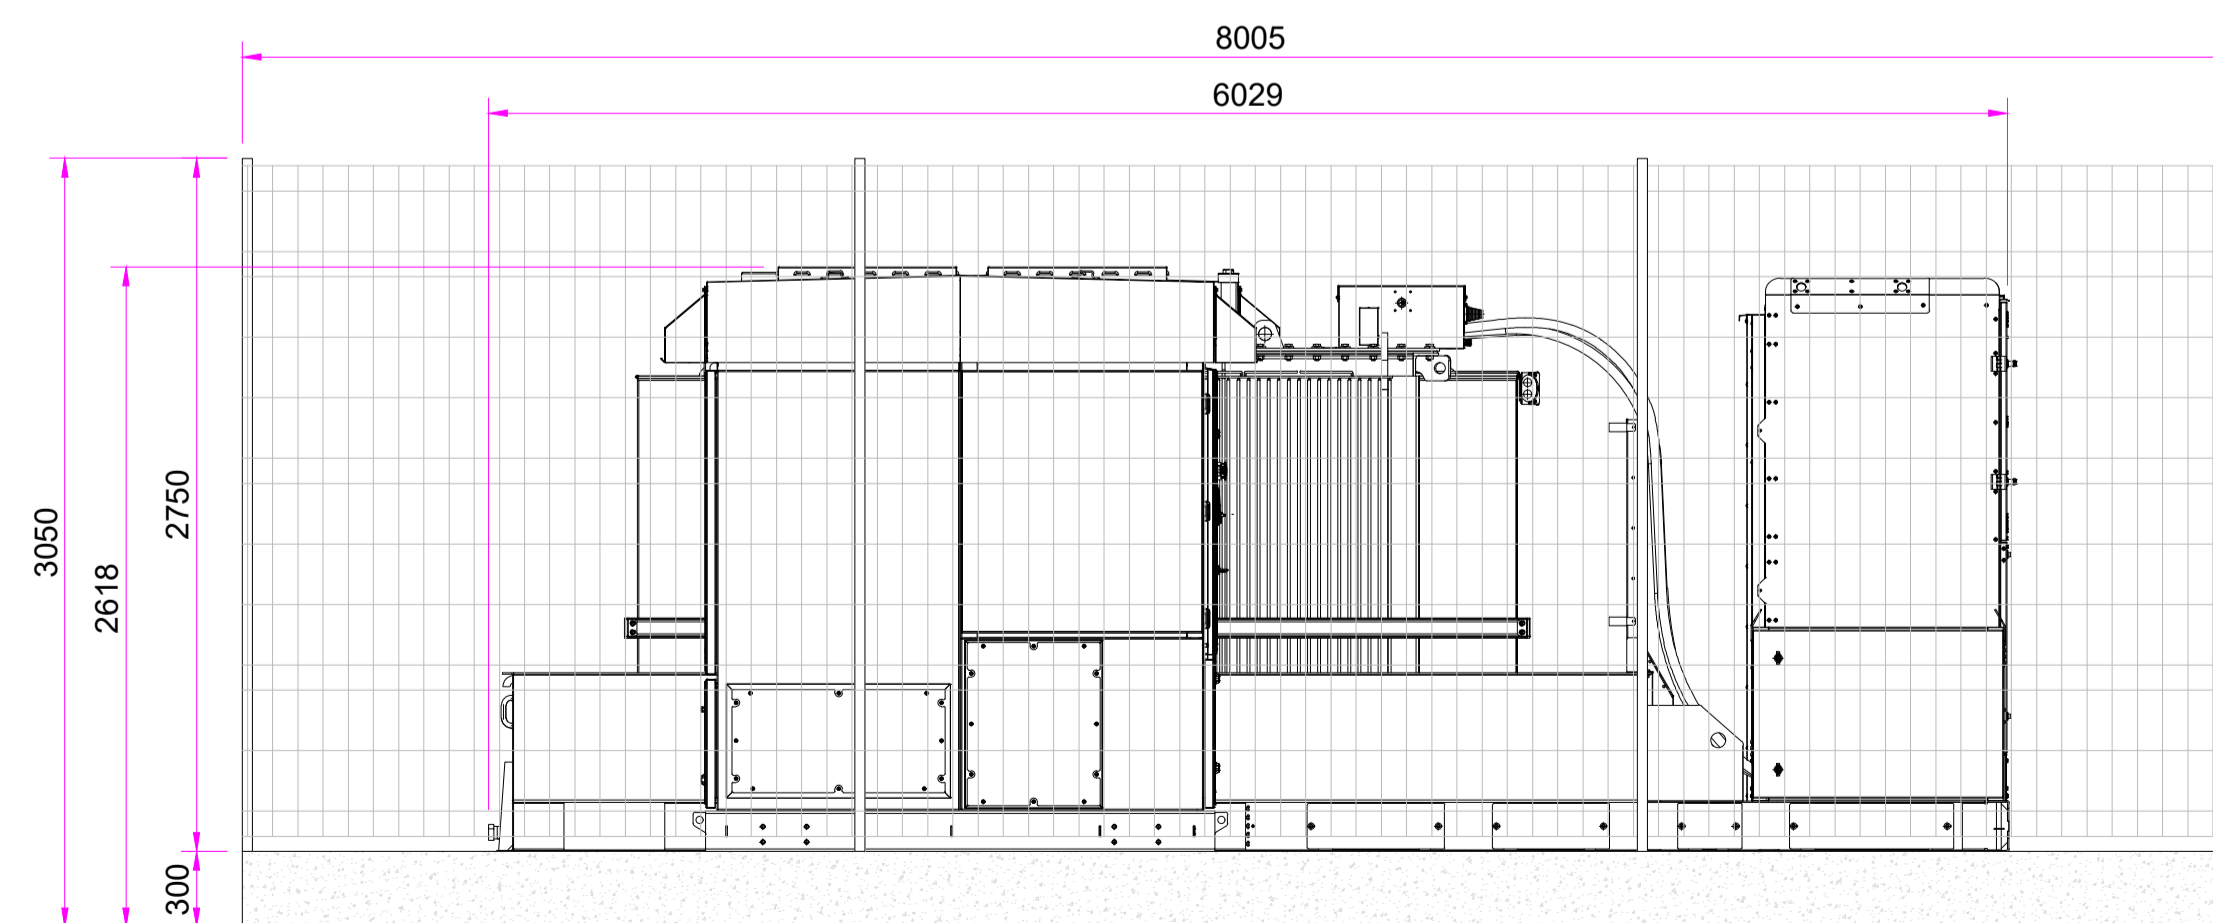

TRANSFORMER / RING MAIN UNIT SKID – FRONT/REAR ELEVATIONS

GL

GL

0 1 2 3 4 5m

A	Revised equipment	17.06.21	SS	CH
-	First Issue	17.06.21	SS	
Rev	Description	Date	Checked	

Drawing No.

BRE-EDFR-TCL-DRG-G001

Project

Bredbury BESS

Title

PCS & Transformer Arrangement

Scale

1:30 @A1

Drawn by

Checked

Date

SS

CH

21.03.23



W: www.edf-re.uk

A: Cardinal Place, 80 Victoria Street, London SW1E 5JL