


Dimensions are not to be scaled from this drawing



Kingfisher Lighting

Part of the Luceco PLC group of companies **LUCECO**

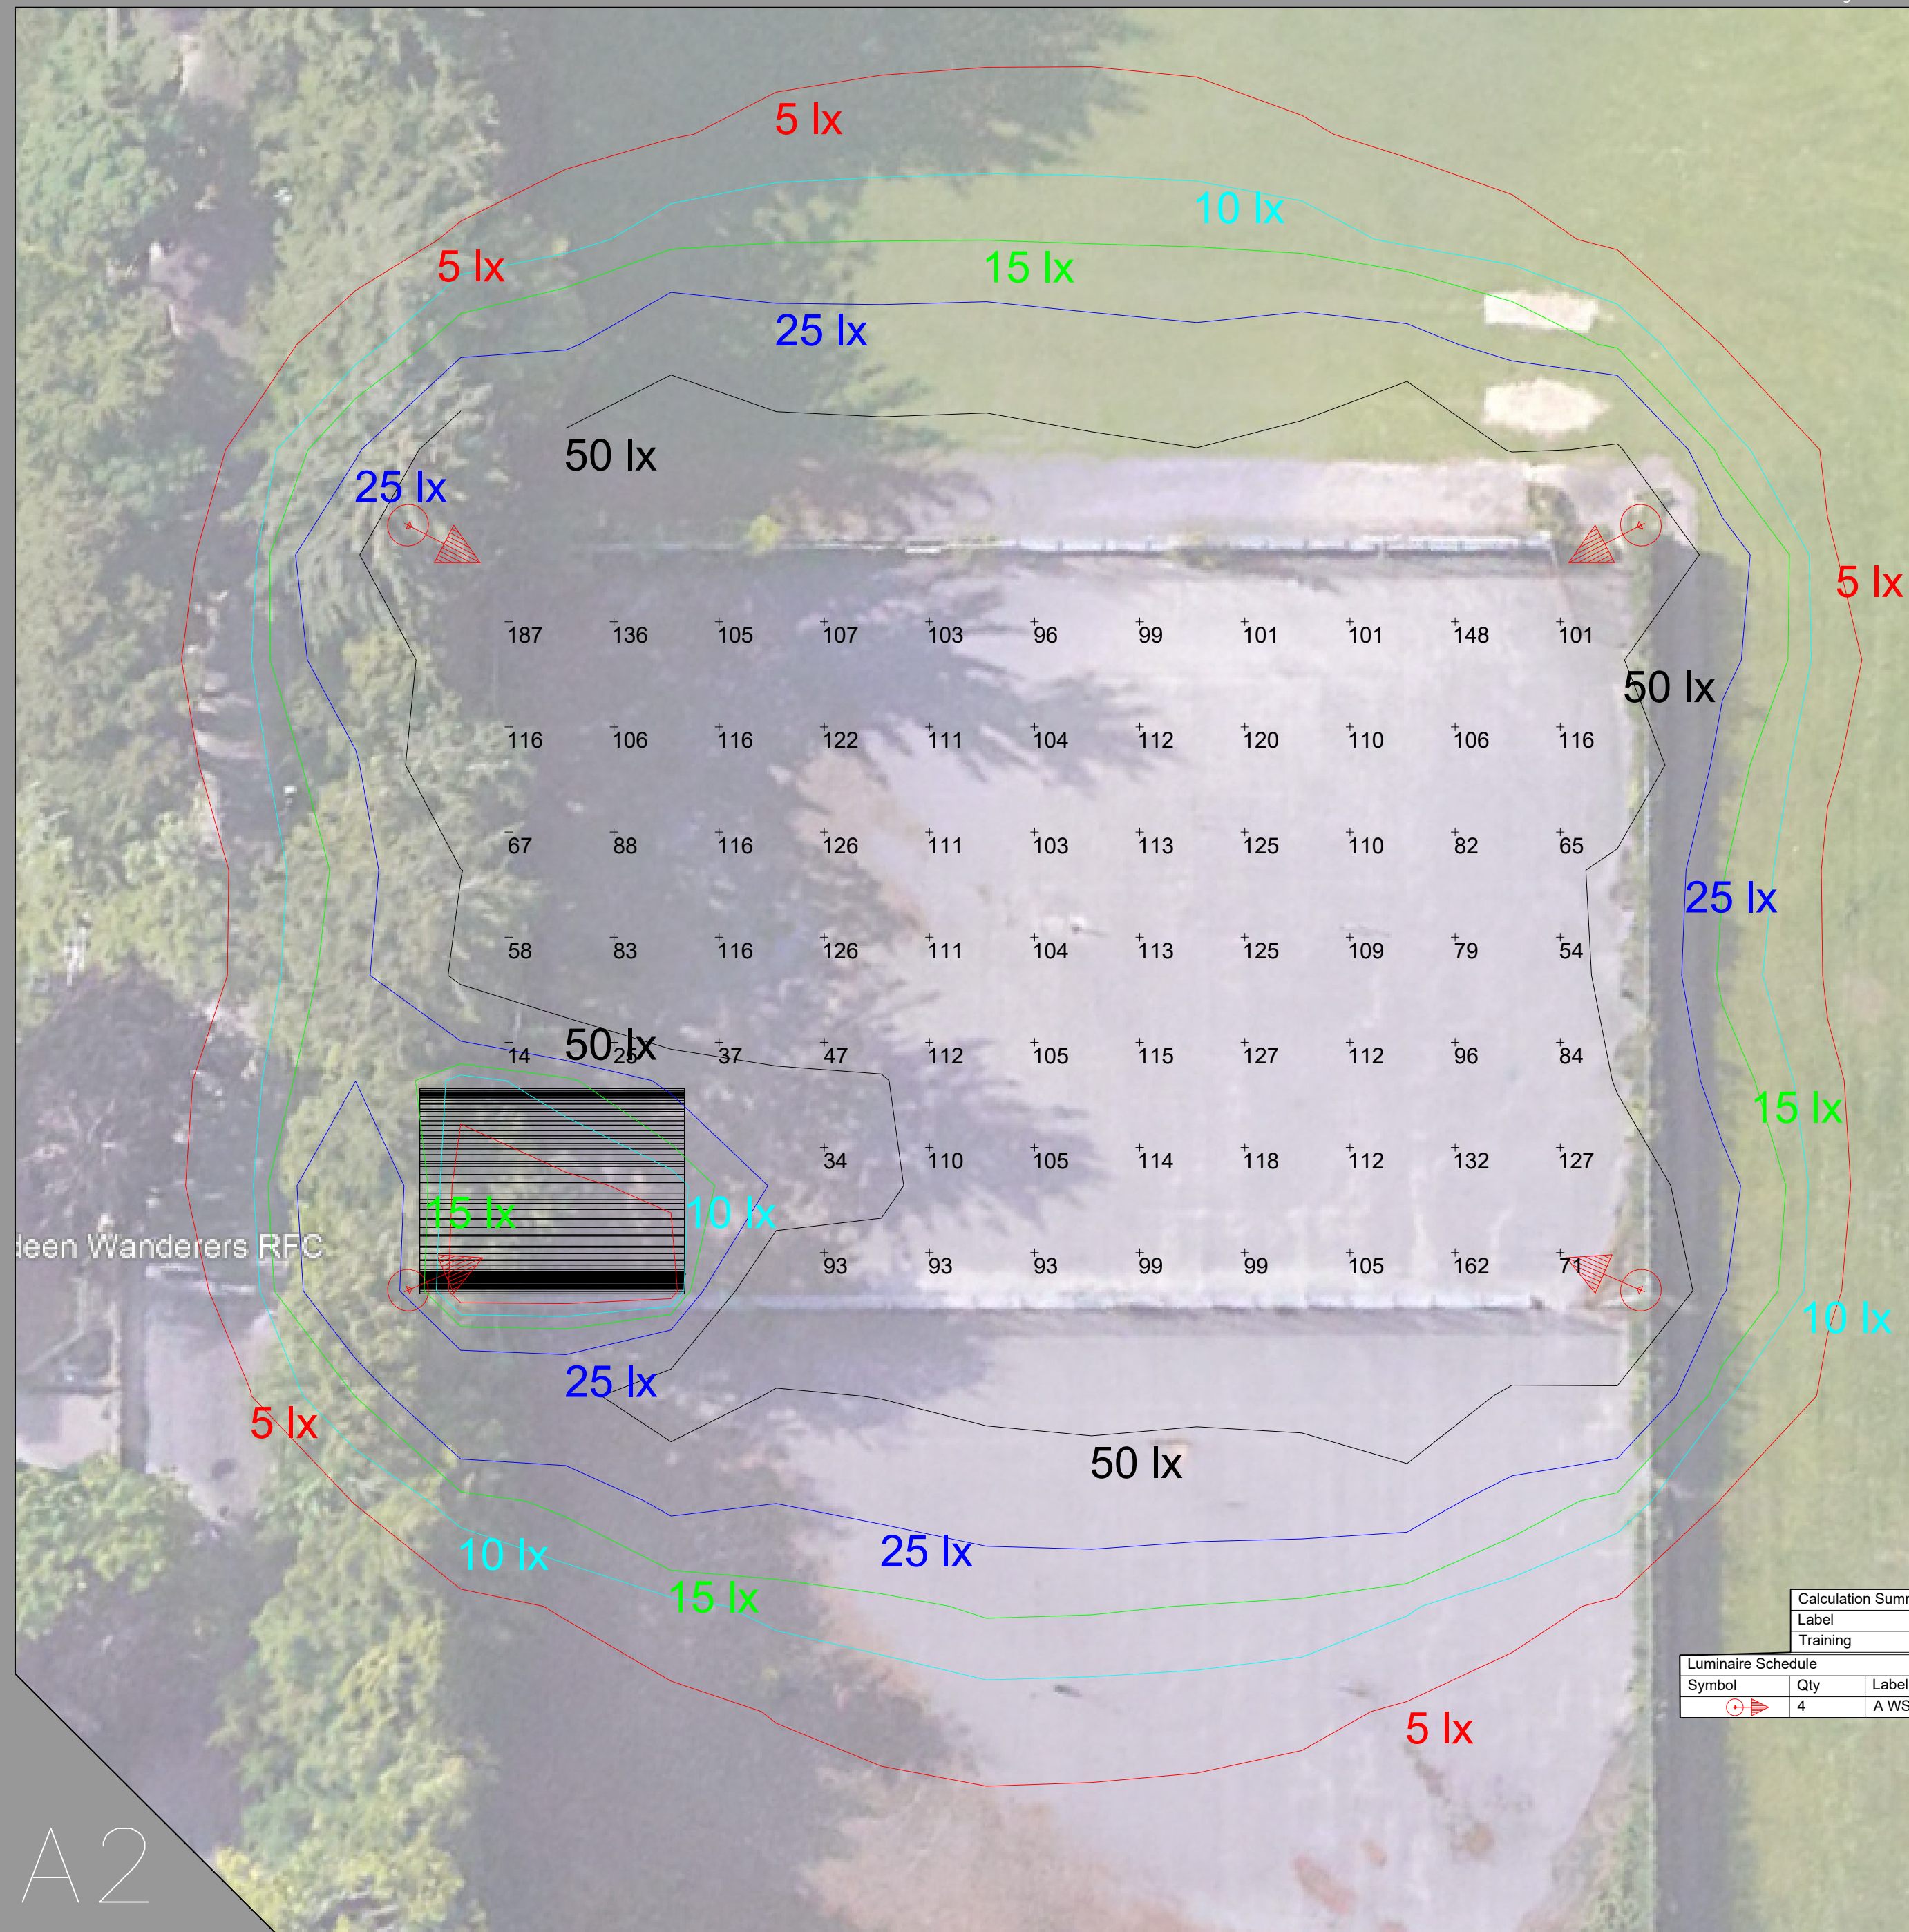

Wanderers RFC

Calculation Summary							
Label	CalcType	Units	Avg	Max	Min	Min/Avg	Min/Max
Training	Illuminance	Lux	102.08	187	14	0.14	0.07

Luminaire Schedule				
Symbol	Qty	Label	Arrangement	Description
	4	A WST 665w	SINGLE	665w LED 4000k Amnis Match Flood with WST Optic @ 10m

Project Title: Wanderers Training area		Scale: 1:250 at A2	Project Number: 49043
Date: 03/08/2023		Drawing No.: Rev B	
Lighting Designer: R Houchin			



For our LED lighting designs a 0.9mf has been used. If this differs from the maintenance period for this project then you must advise us accordingly.

A lighting applications design service is provided by us in good faith and without charge, relating to Kingfisher products only. As such, whilst every endeavor is made for accuracy from information provided by yourselves, the final responsibility for the suitability of the design lies with the client. The company cannot, therefore, accept any liability or consequential loss incurred.

A2