 



Heat pump 134OR site plan

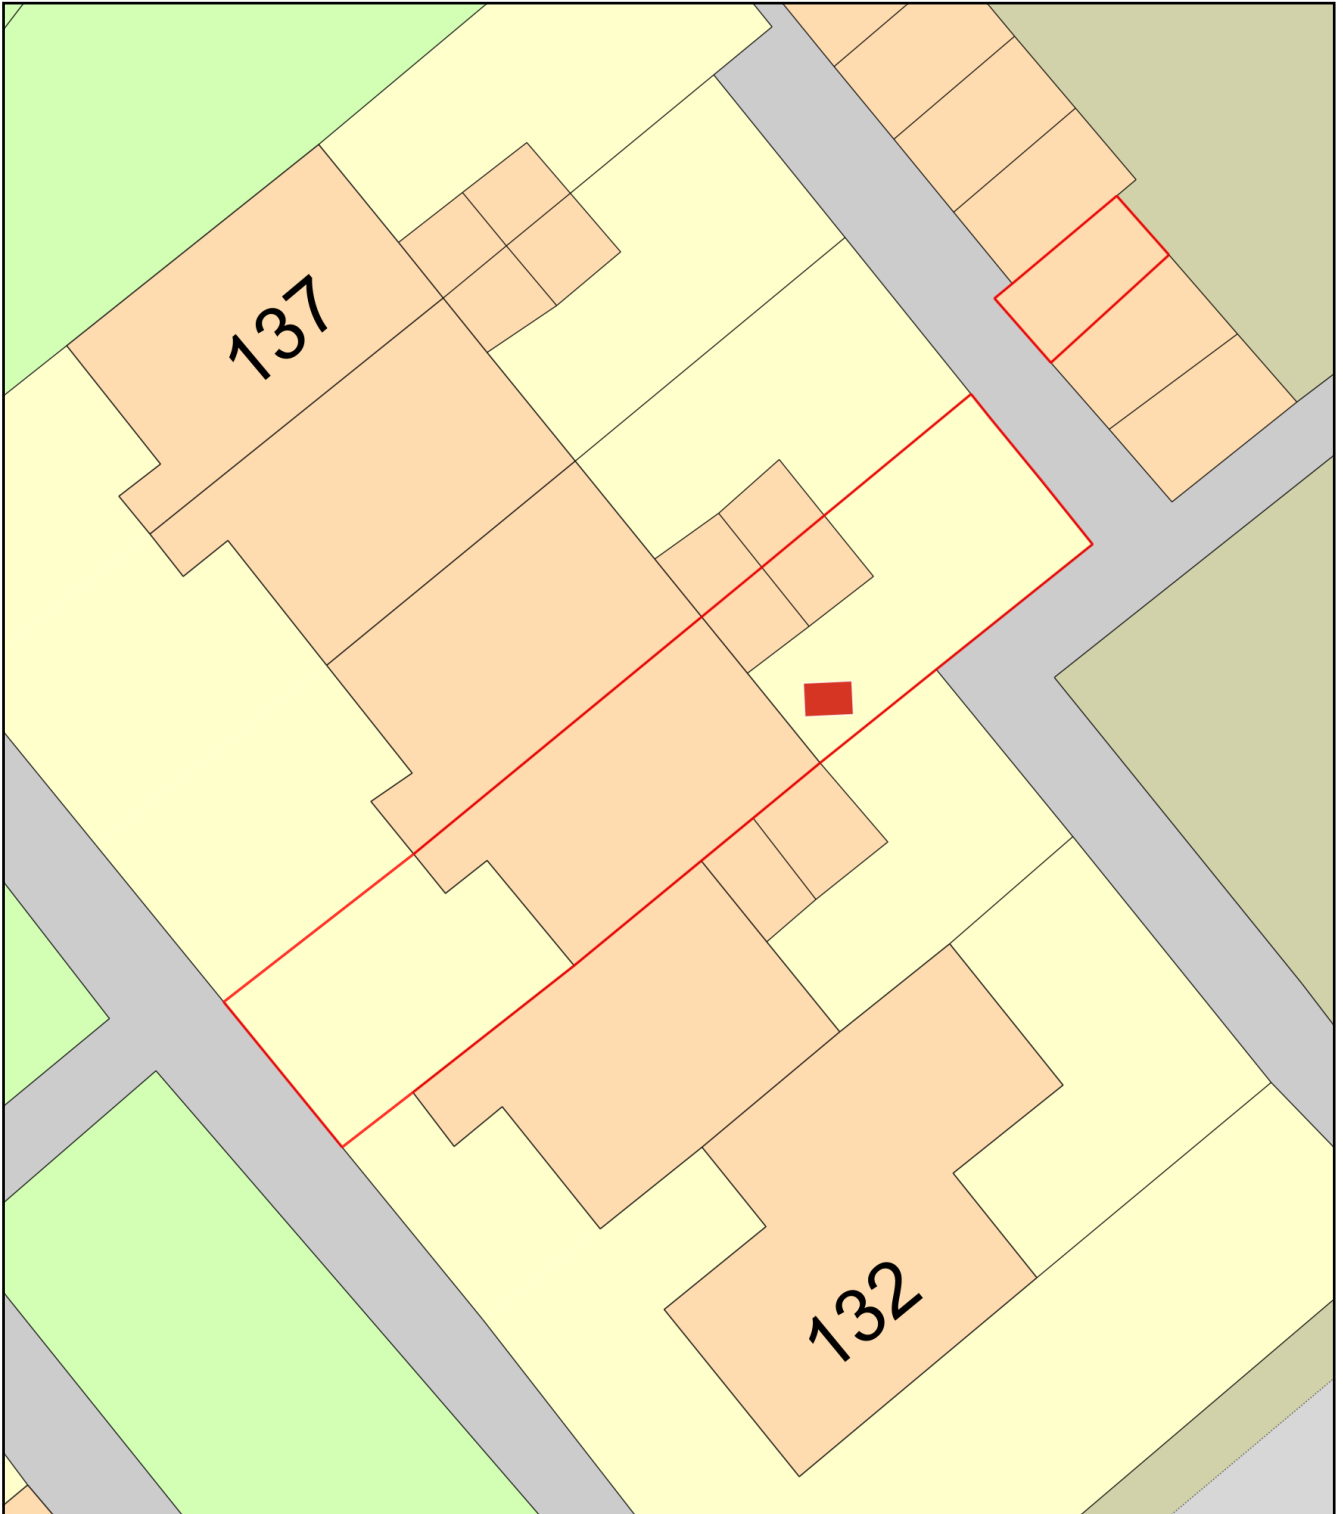

Plan Produced for: Jethro Walters
Date Produced: 12 Nov 2023
Plan Reference Number: TQRQM23316195253351
Scale: 1:200 @ A4