


REVISION	DATE

DO NOT SCALE ALL DIMENSIONS  
 TO BE CHECKED BY CONTRACTOR  
 ON SITE. ERRORS OR OMISSIONS  
 TO BE REPORTED TO ARCHITECTS

DRAFT  
 PRELIMINARY  
 PLANNING  
 TENDER  
 CONSTRUCTION  
 AS BUILT


**FIRE STRATEGY KEY**

- Primary Route of Escape
- Secondary means of escape
- 1 Hr Fire Compartment
- 30mins Fire Compartment
- FD30 or FD20 fire - Doors
- Vertical Fire stop
- Heat Detector
- Smoke Detector
- Non Sounding Smoke detector
- Emergency Lighting
- Jump Down

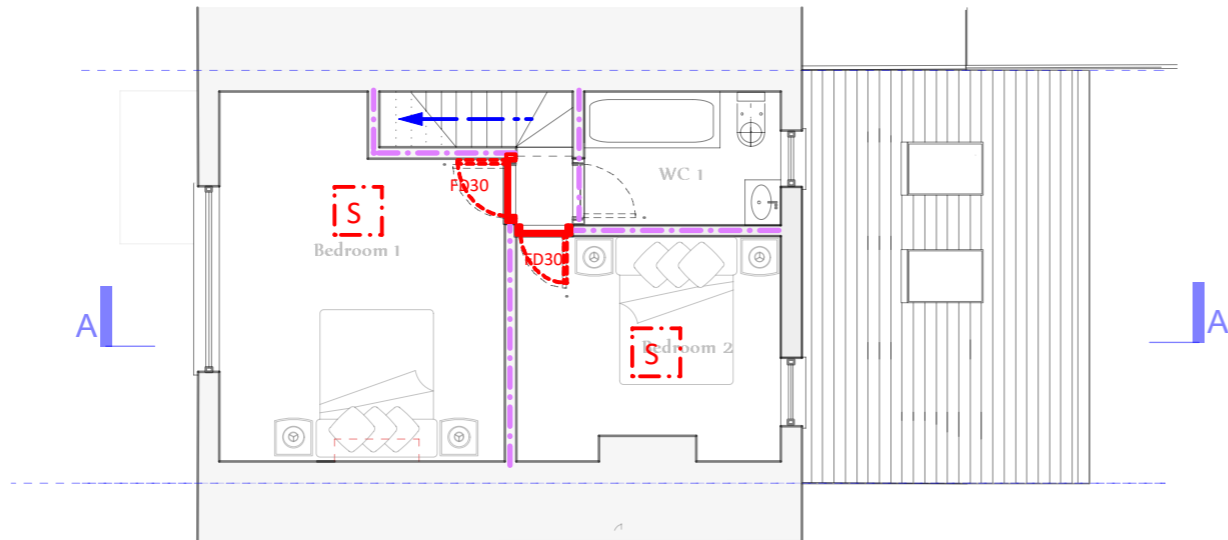

**FIRST FLOOR PLAN**

SCALE 1:100 @ A3

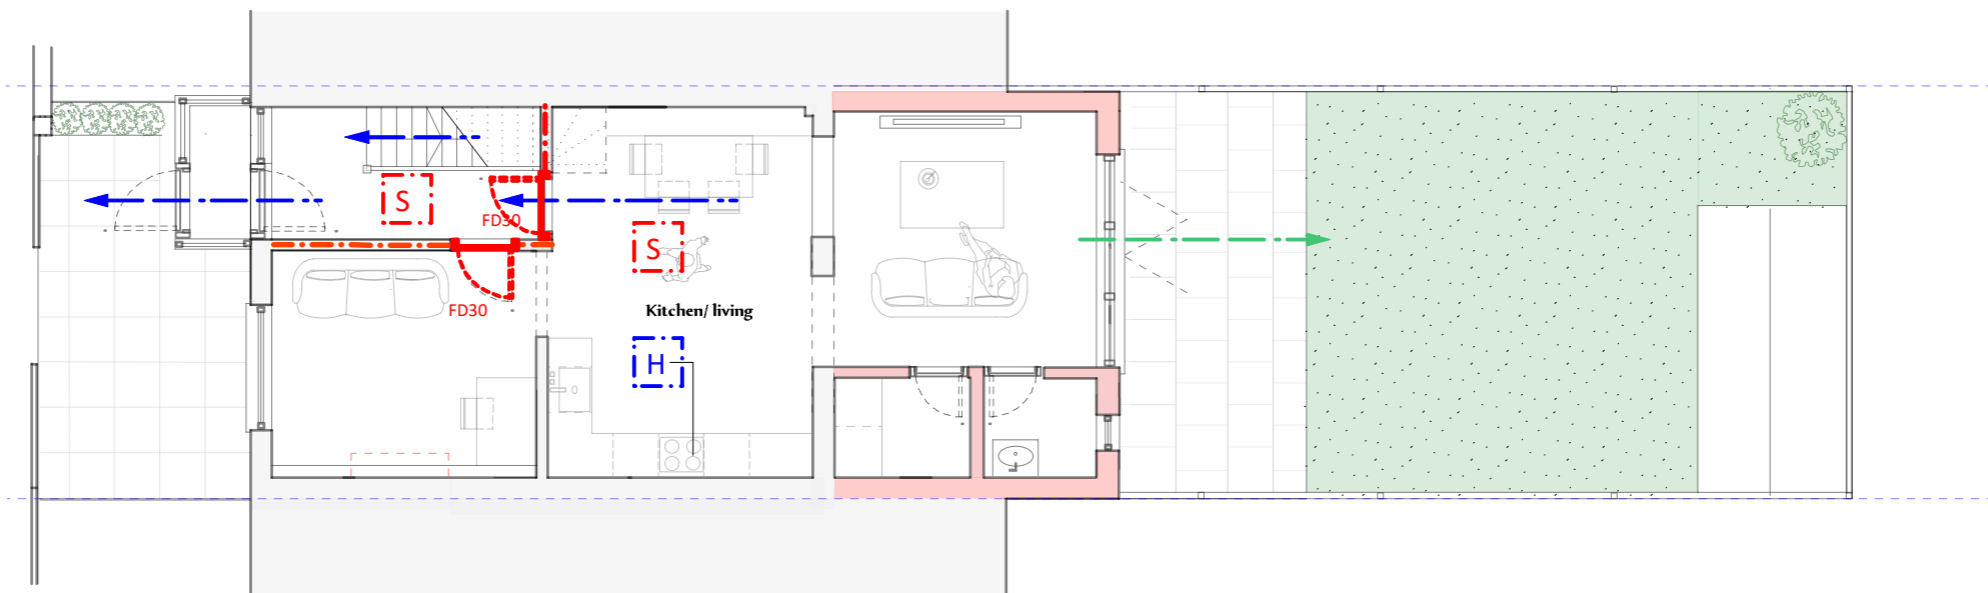

**GROUND FLOOR PLAN**

SCALE 1:100 @ A3

**FIRE STRATEGY**

SCALE: 1:50

**P-07**

DRAWN BY: KS