
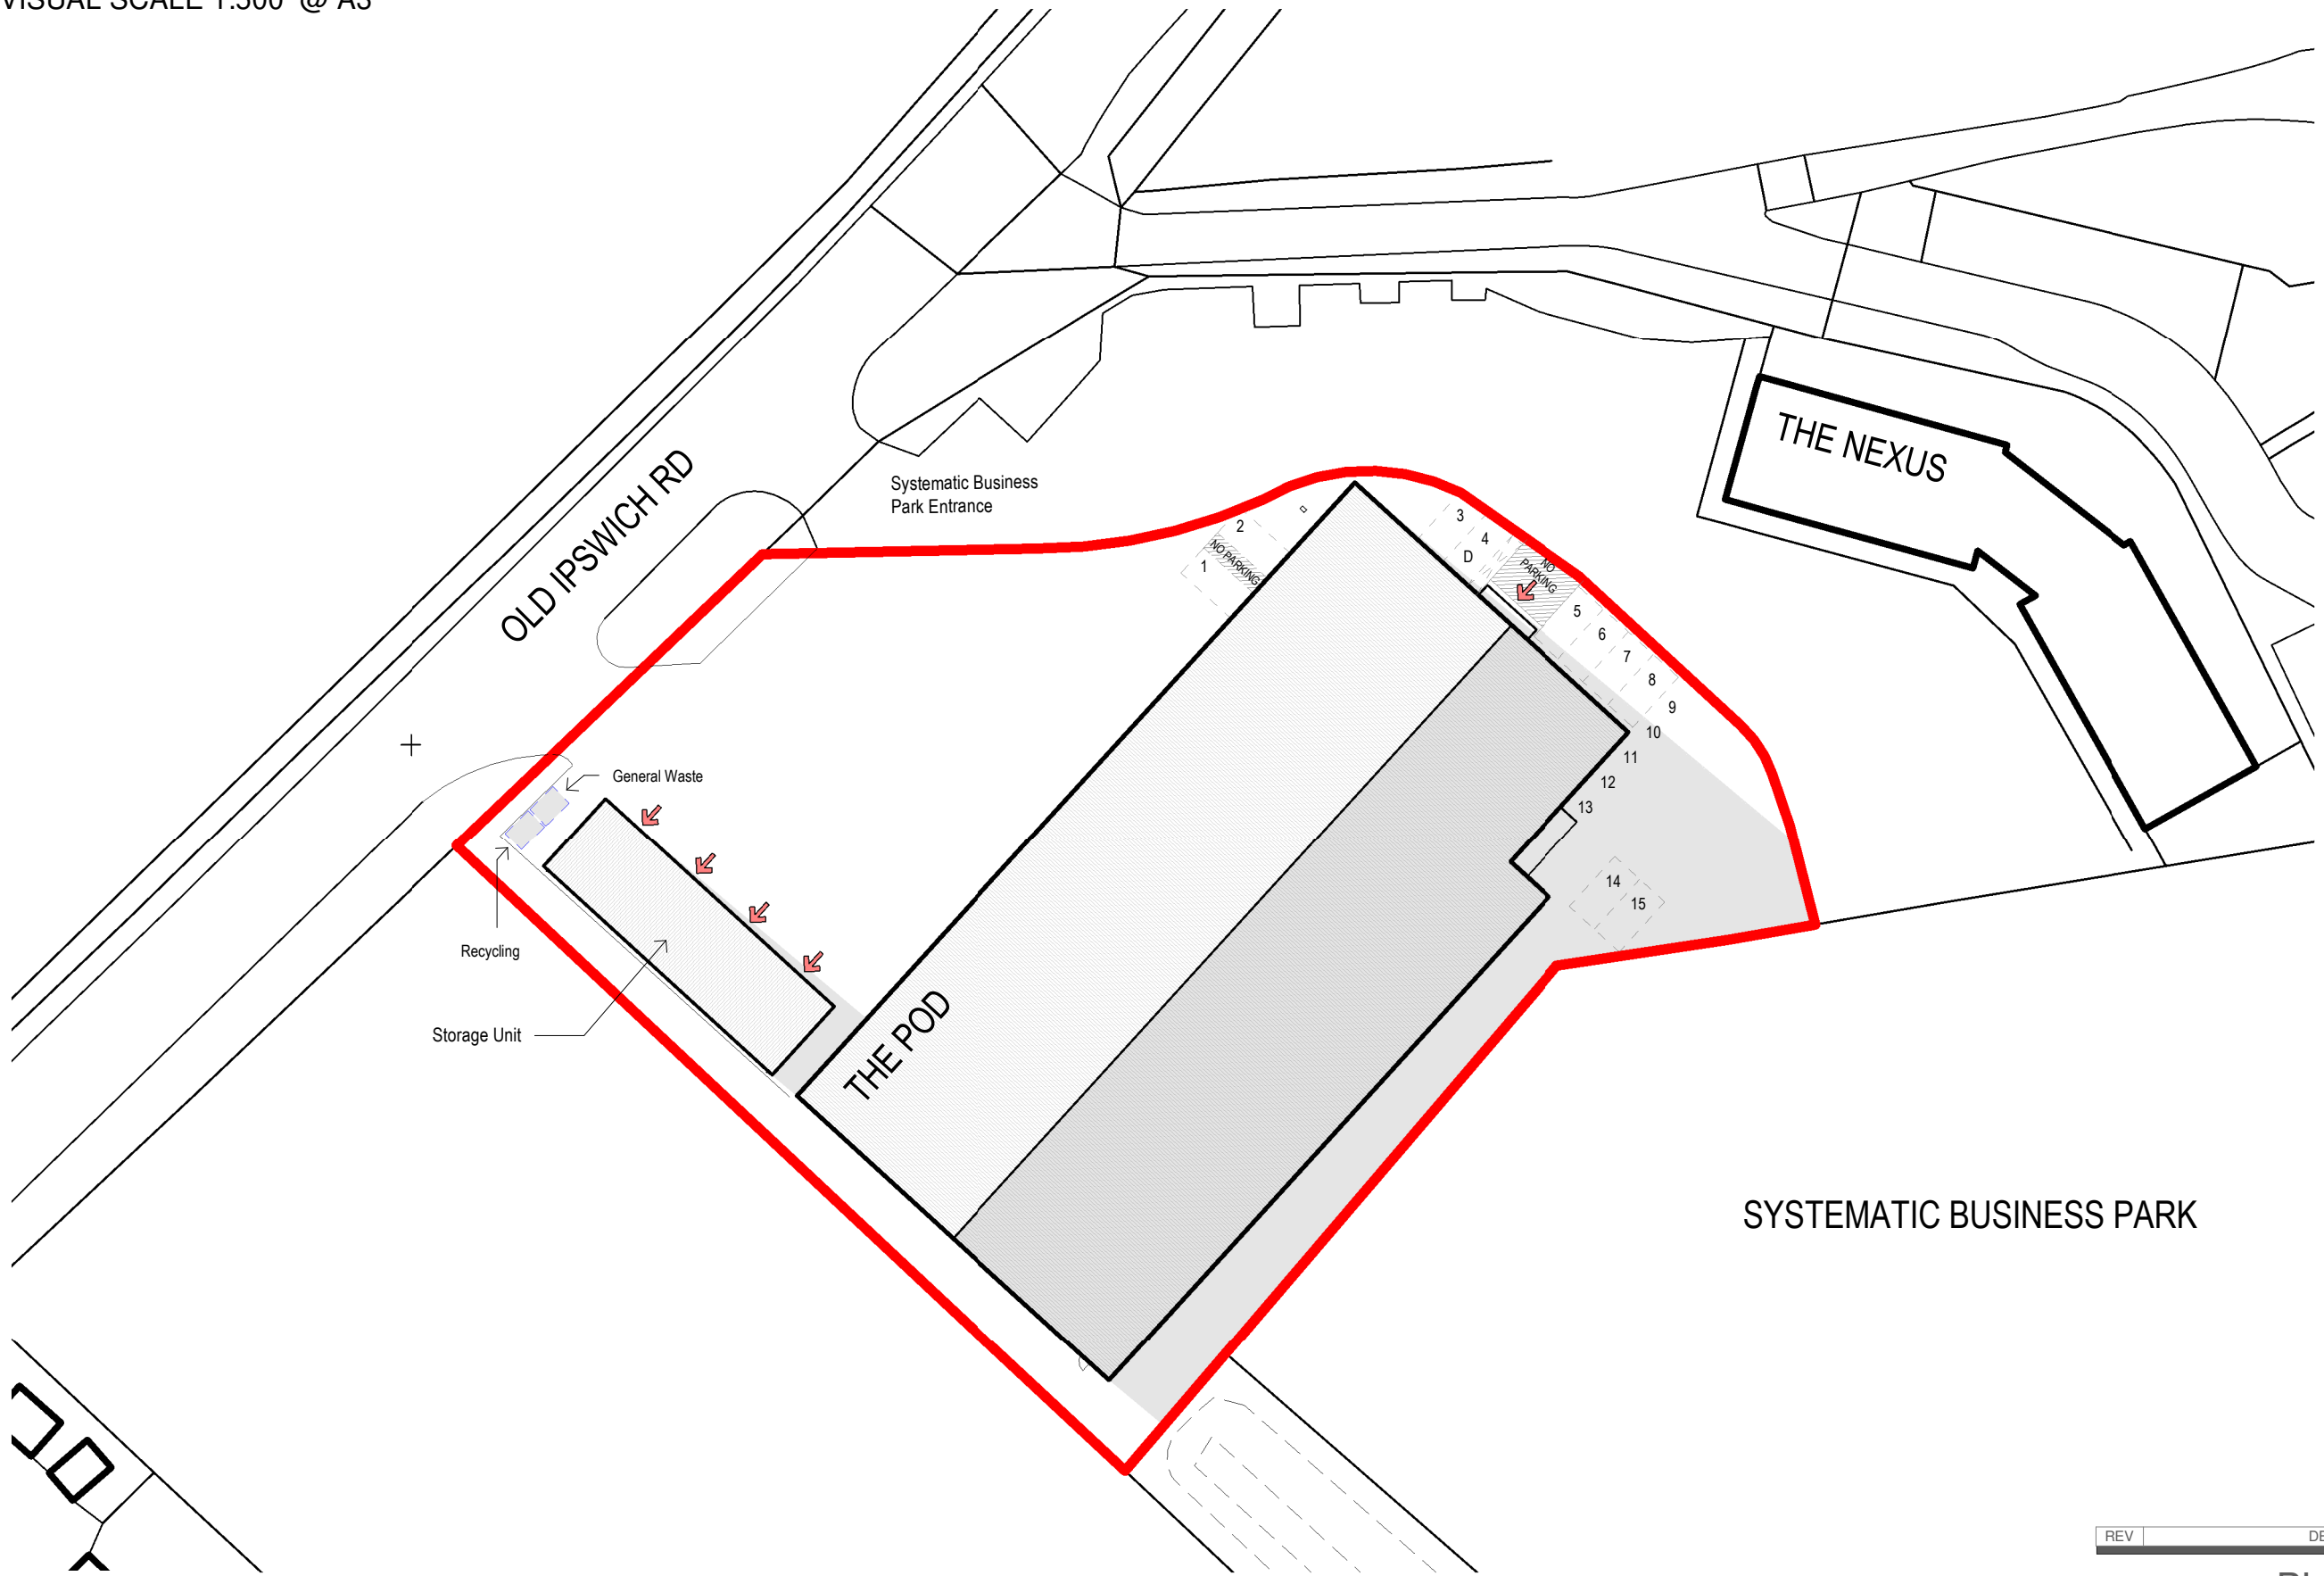


VISUAL SCALE 1:500 @ A3

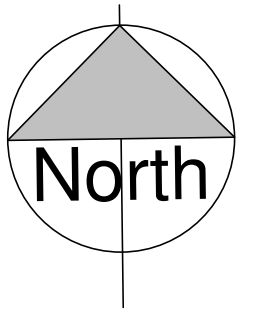

SYSTEMATIC BUSINESS PARK

REV	DESCRIPTION	DATE
-----	-------------	------

PLANNING

CLIENT
JA Brooks Mechanical Services

DRAWN
SN

DRAWING
Proposed Site Plan



PROJECT
Storage Unit @ The Pod

SCALE
1 : 500 @ A3

DRAWING NUMBER
2329-1103-

DATE
December 2023

