 



ELECTRICAL LEGEND:

- ⏏ Double switch socket
- ⏏ Switch with remote spur
- ⊗ Light Fixture ceiling... pendant
- ⊗ Light switch
- ⊗ Bulkhead Light Fixture ... PIR
- ⊗ Ceiling Mounted Exhaust Fan
- ⊗ Wall Mounted Exhaust Fan
- ⊗ Tv Outlet
- ⊗ Telephone Outlet
- ⊗ Smoke Detector ... hard wired
- ⊗ Heat Detector ... hard wired
- ⊗ Carbon monoxide Detector/hard wire
- ⊗ Radiator with TRV fitted
- ⊗ Door bell...electric
- ⊗ Door bell push
- ⊗ Cooker control unit
- ⊗ Shaver socket outlet
- ⊗ Consumer unit
- ⊗ Double switch + Broadband socket

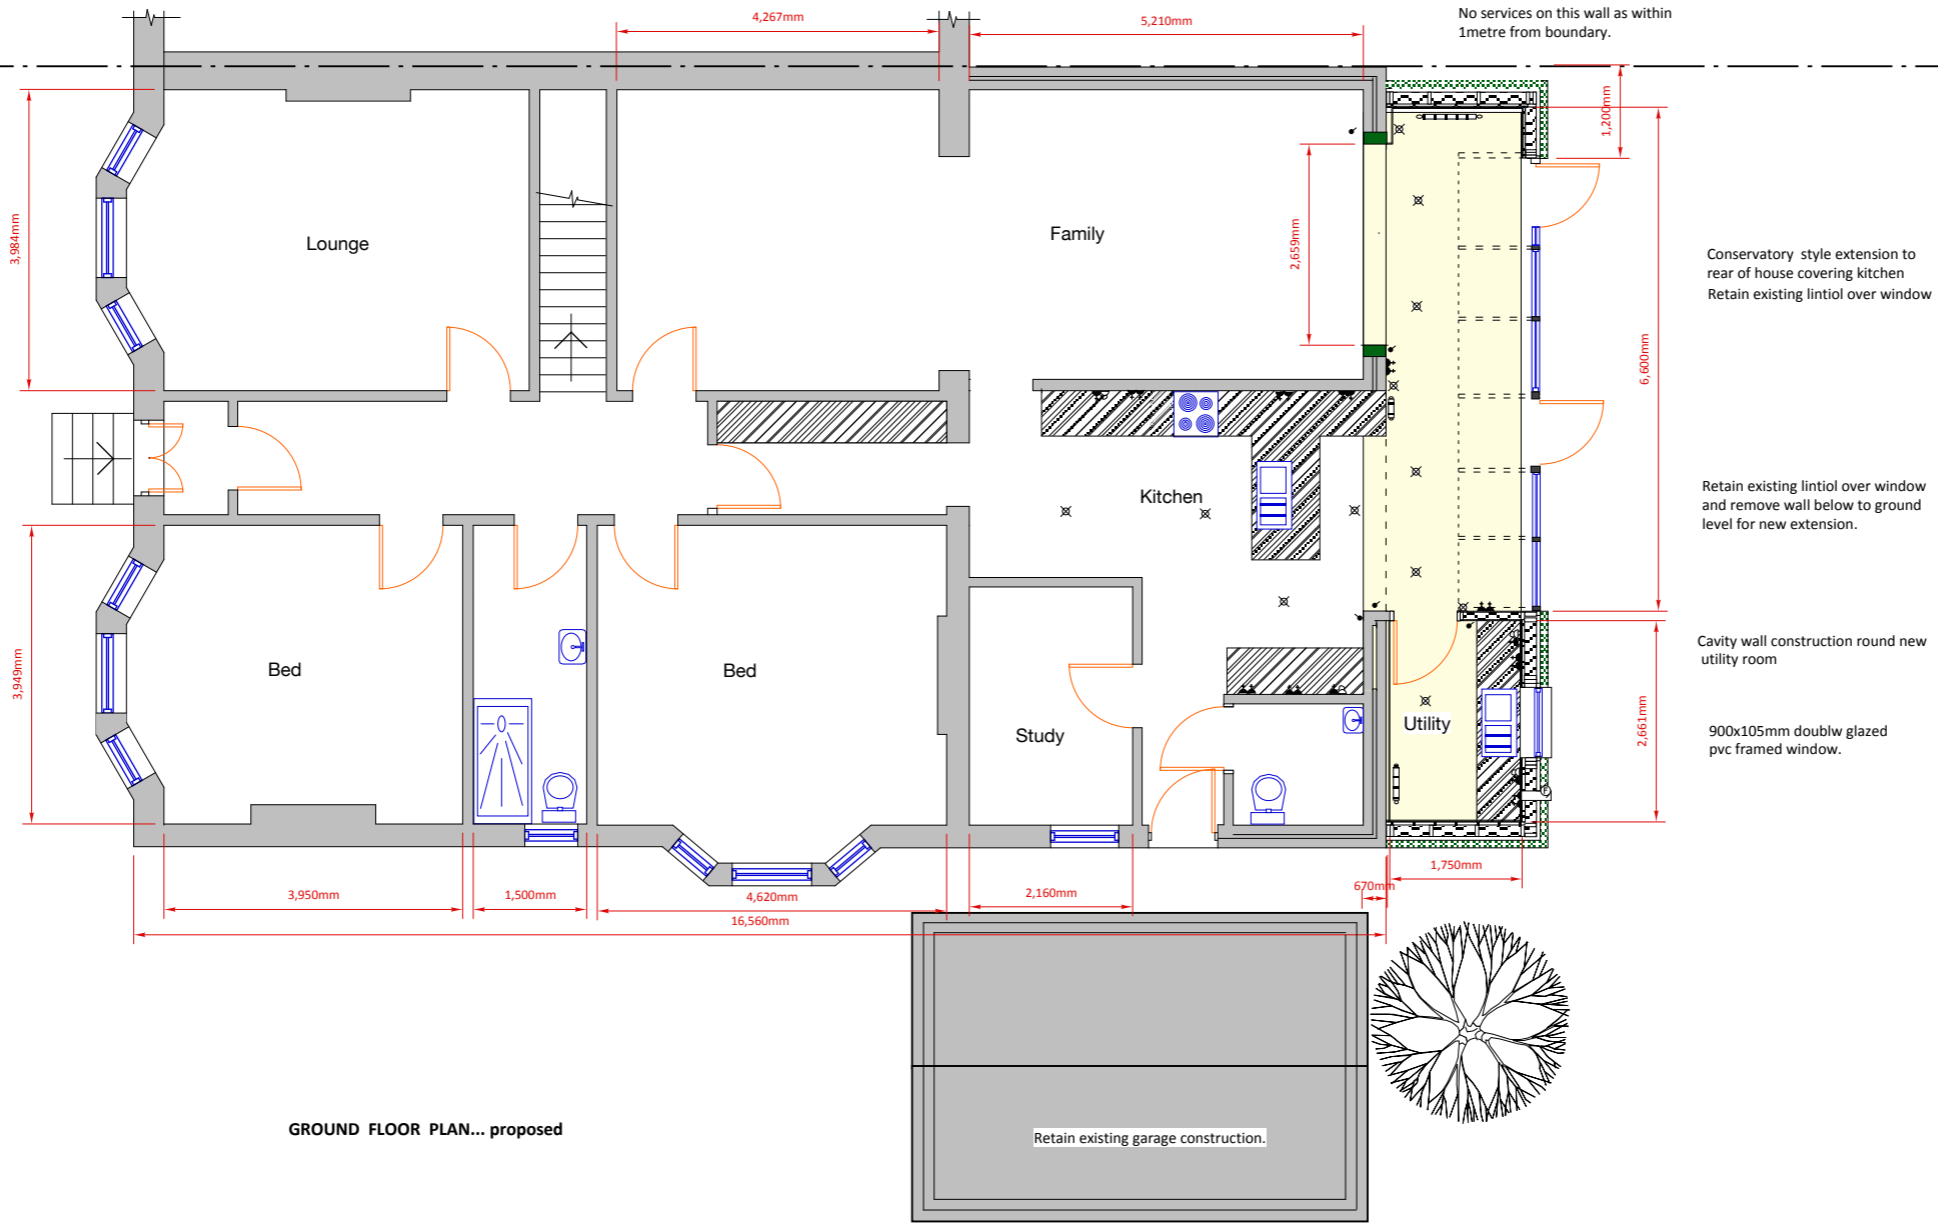

IF IN DOUBT ASK
DO NOT SCALE FROM THIS DRAWING

REV	DATE	REMARKS

CLIENT: Mr & Mrs A Baig
435 Kilmarnock Road, Glasgow

PROJECT: Ground & FF alterations to form sun lounge and bed /study

TITLE: Ground Floor Plan ... proposed

SCALE: Scale @A1 1: 50
Scale @A3 1: 100

DATE: 27.10.23

DRG No: A1576.23.06

KEA KEITH EDWARDS ARCHITECT

2 CALDON STREET, GLASGOW G12 8XK
tel: 0141 341 0694 - Email: kewards1701@gmail.com