


N


LEAD RAINWATER
SPOUTS

W

E

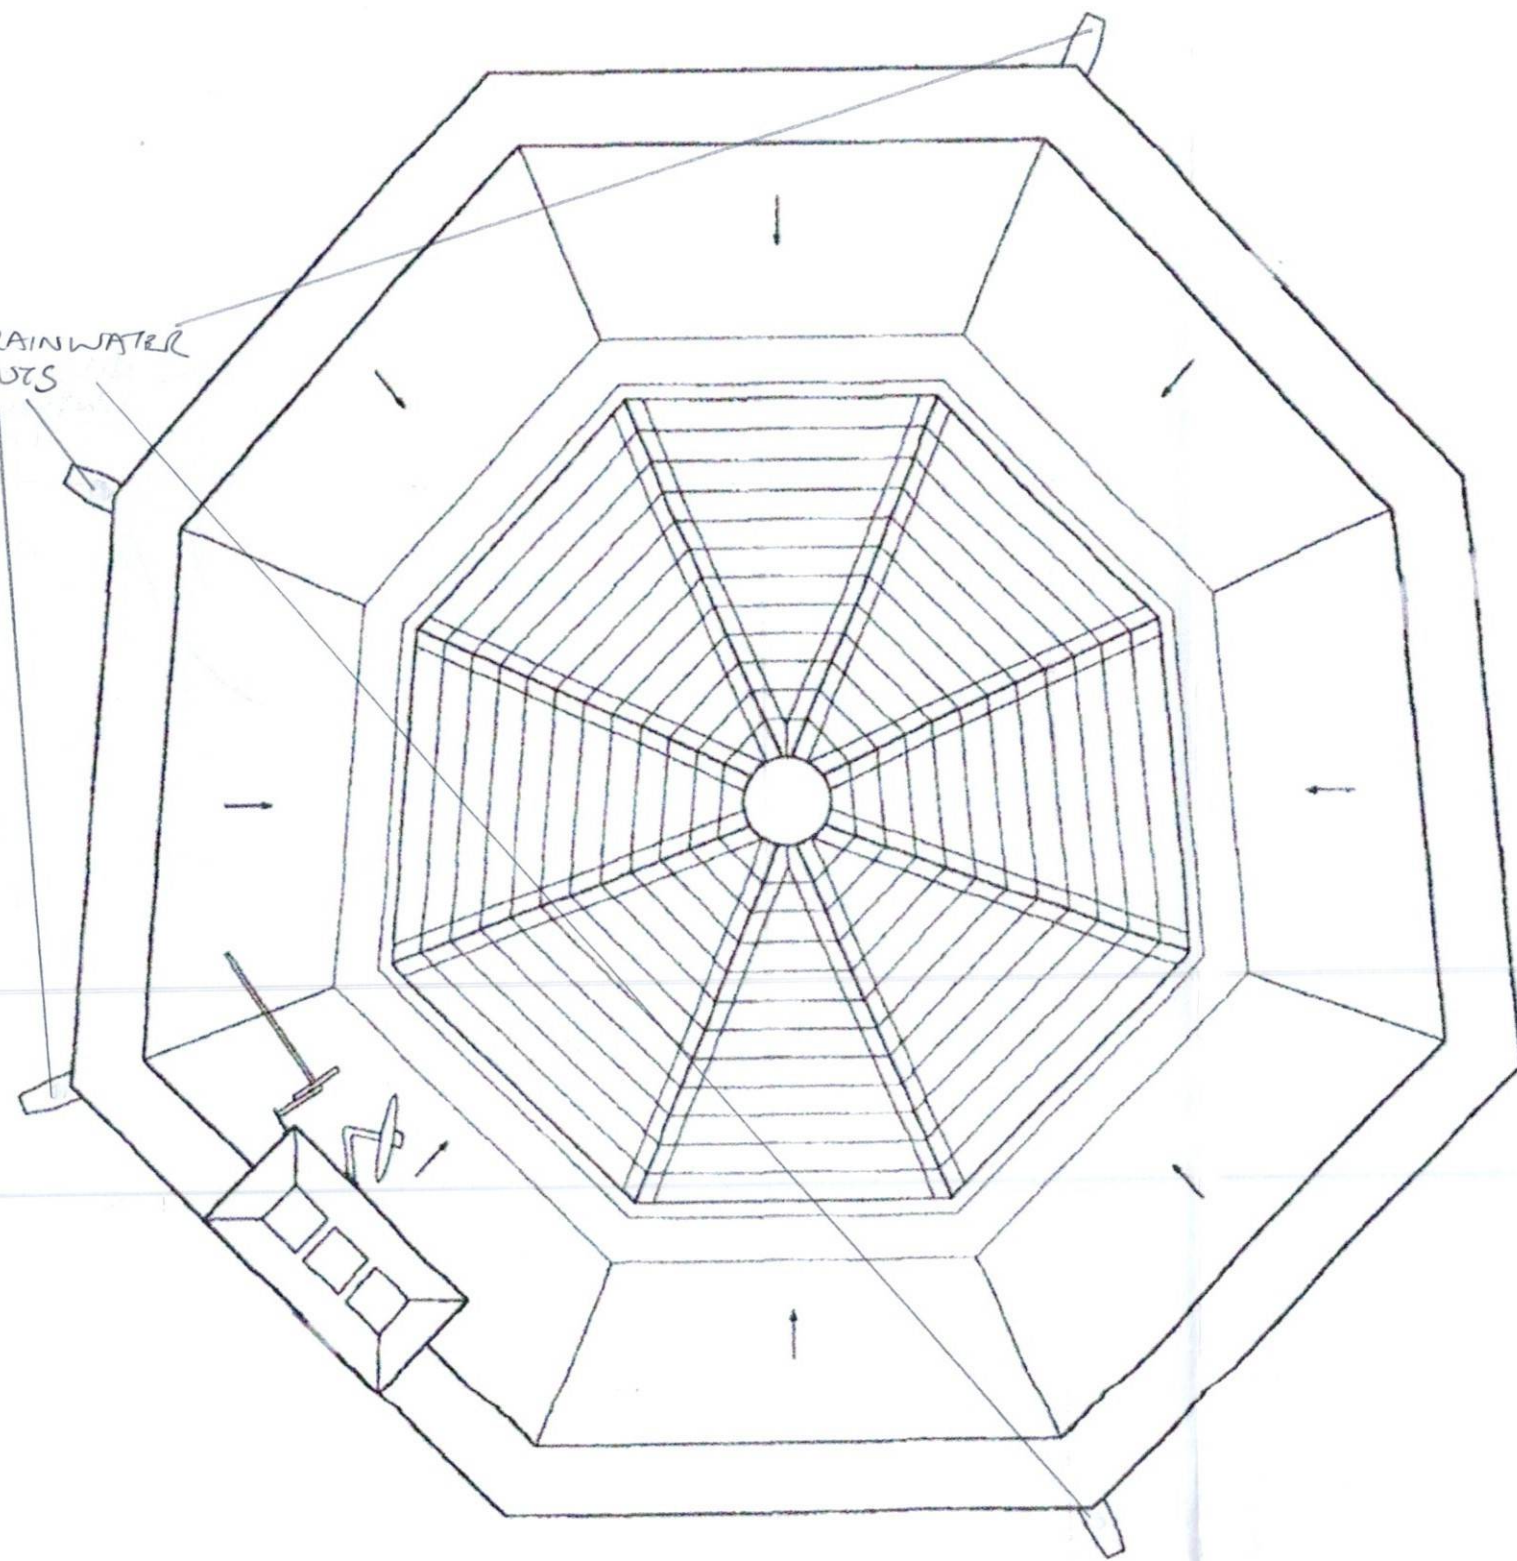

S

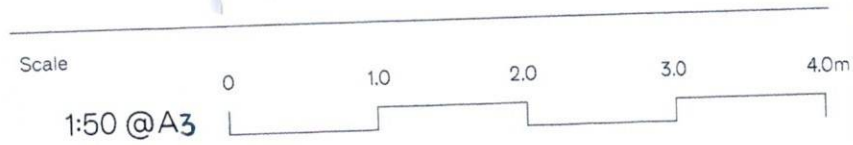

ALL DIMENSIONS TO BE CHECKED ON SITE. ANY DISCREPANCIES TO BE REPORTED TO THIS OFFICE.

CLIENT	COWDRAY HERITAGE TRUST		
JOB	PROPOSED DOWNPIPES		
TITLE	CONDUIT HOUSE - ROOF PLAN EXISTING		
DATE:	DEC 2023	DRAWN: SC	Scale: 1:50 @A3
COPPERSTONE LTD		CCL1.14	

MARTIN ARBIB
ARCHITECTS
100, MARKET STREET, LONDON
E1 1AN