

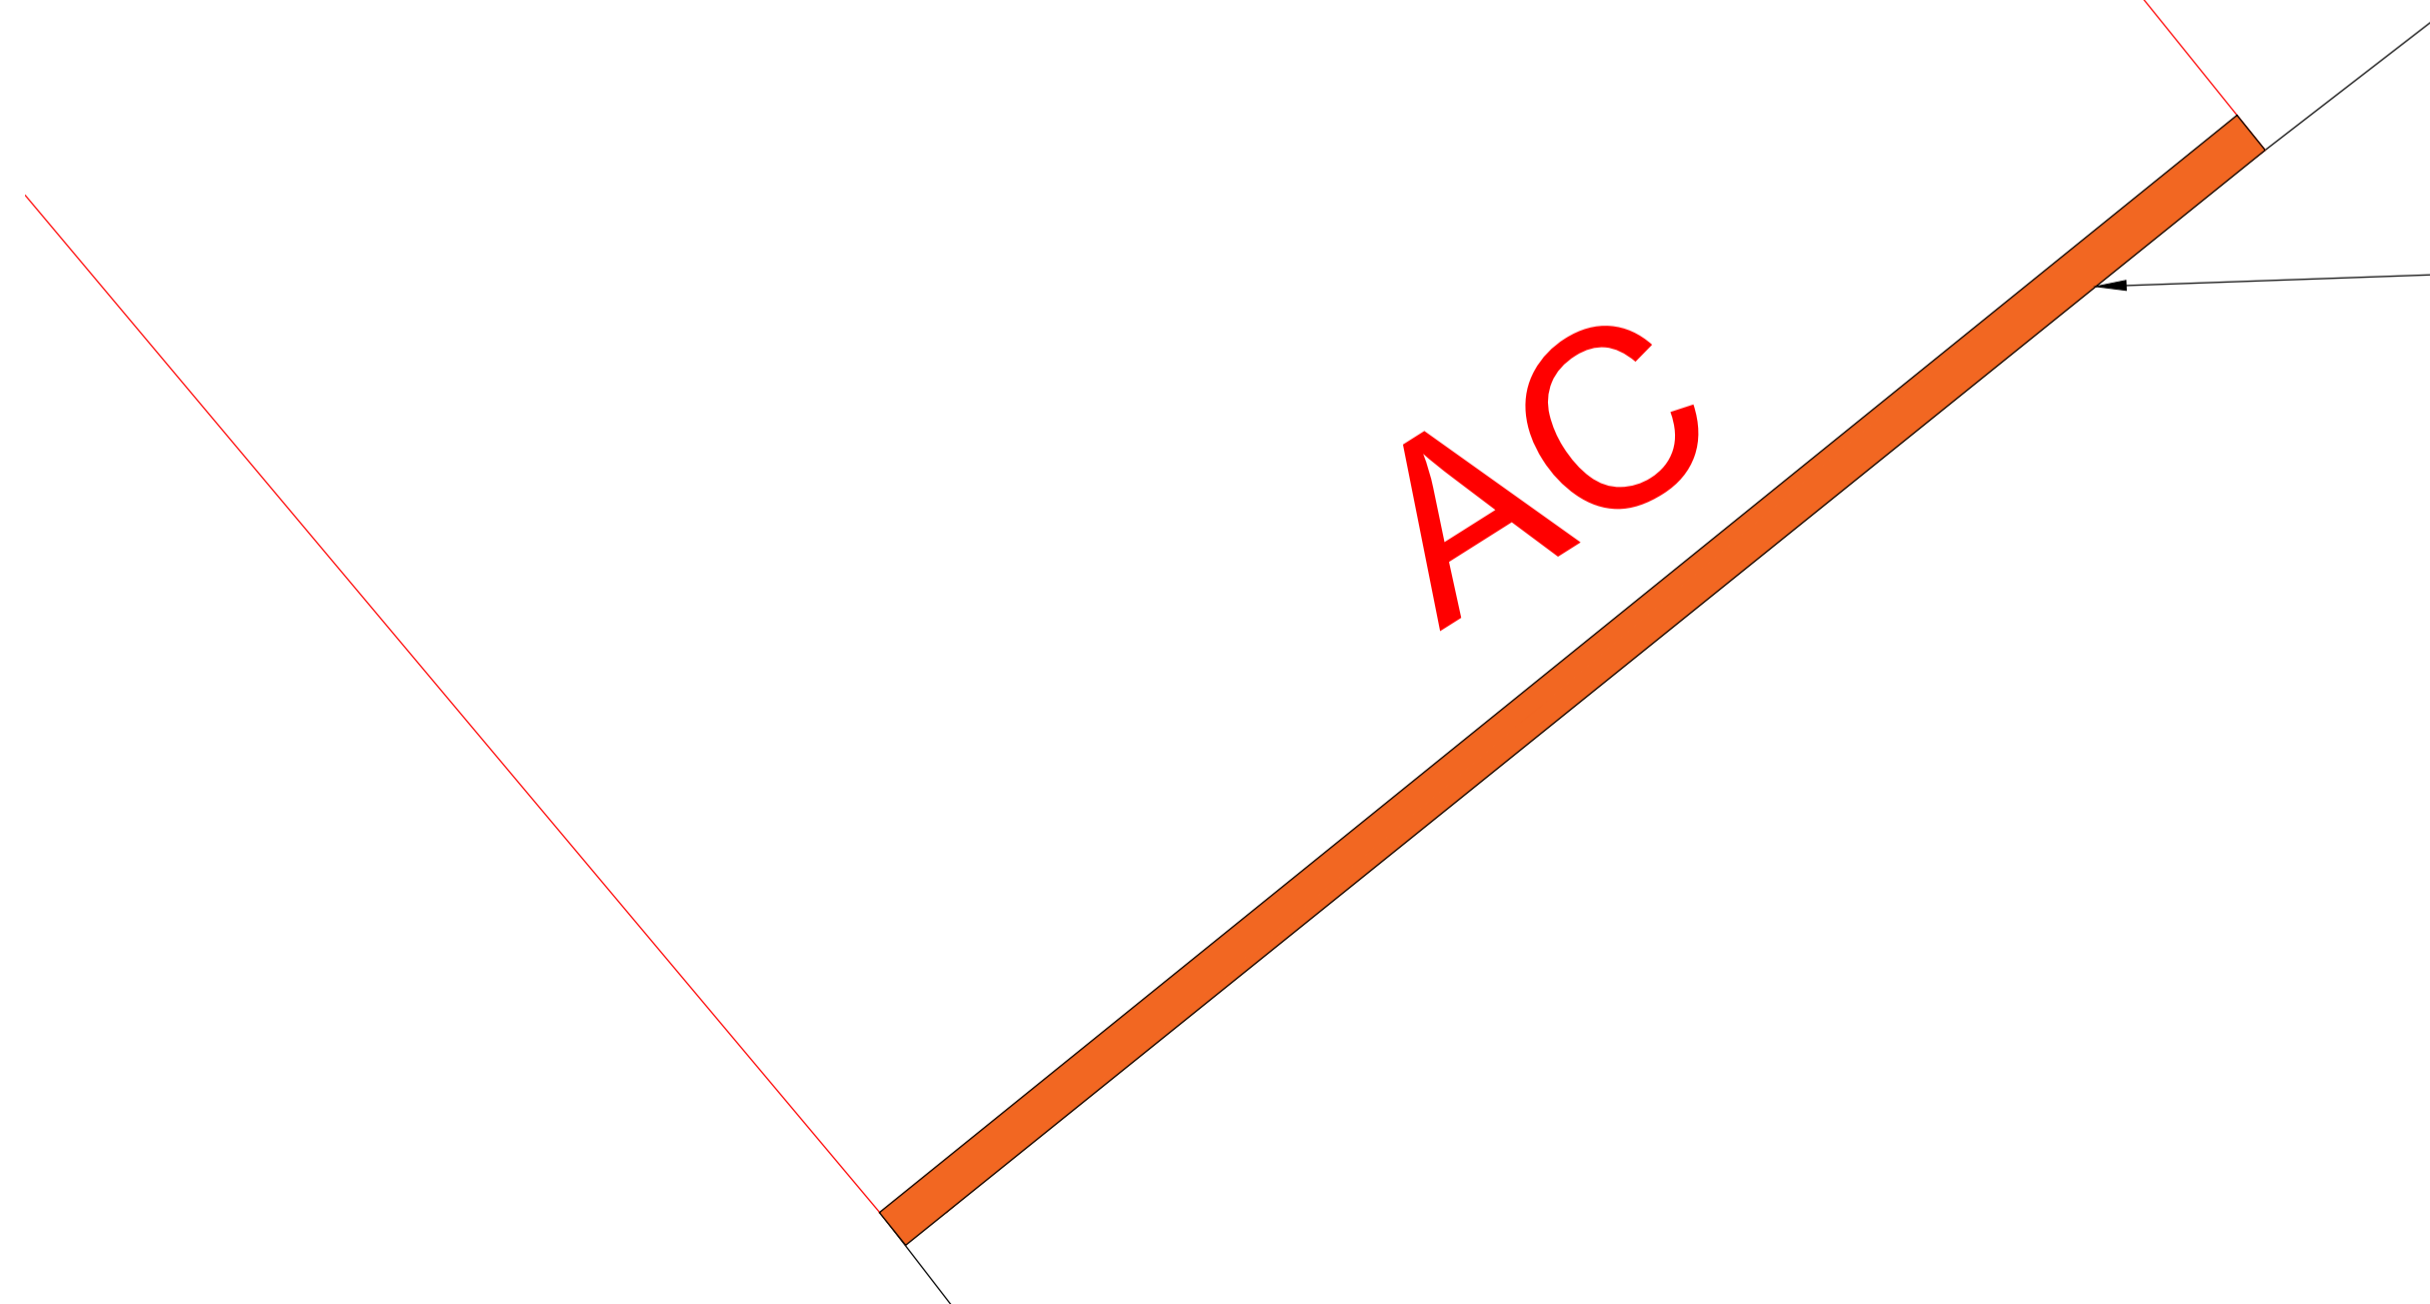



PROPOSED INTERNALLY ILLUMINATED FASCIA SIGNS AND INTERNALLY ILLUMINATED PROJECTION SIGN - SCALE 1:50 @ A1

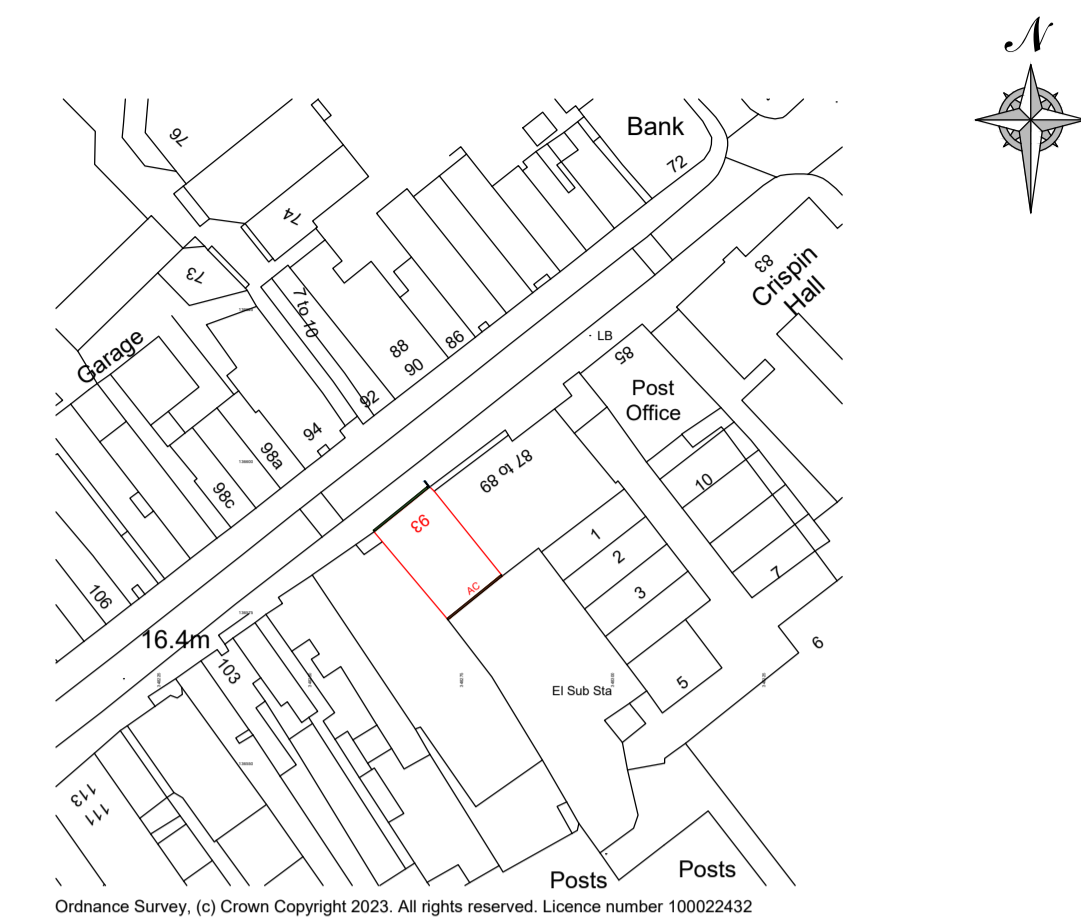

PROPOSED AC CONDENSER POSITION - SCALE 1:50 @ A1

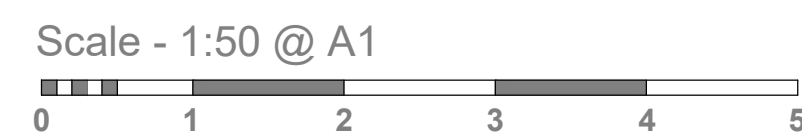

LOCATION PLAN - SCALE 1:1250 @ A1

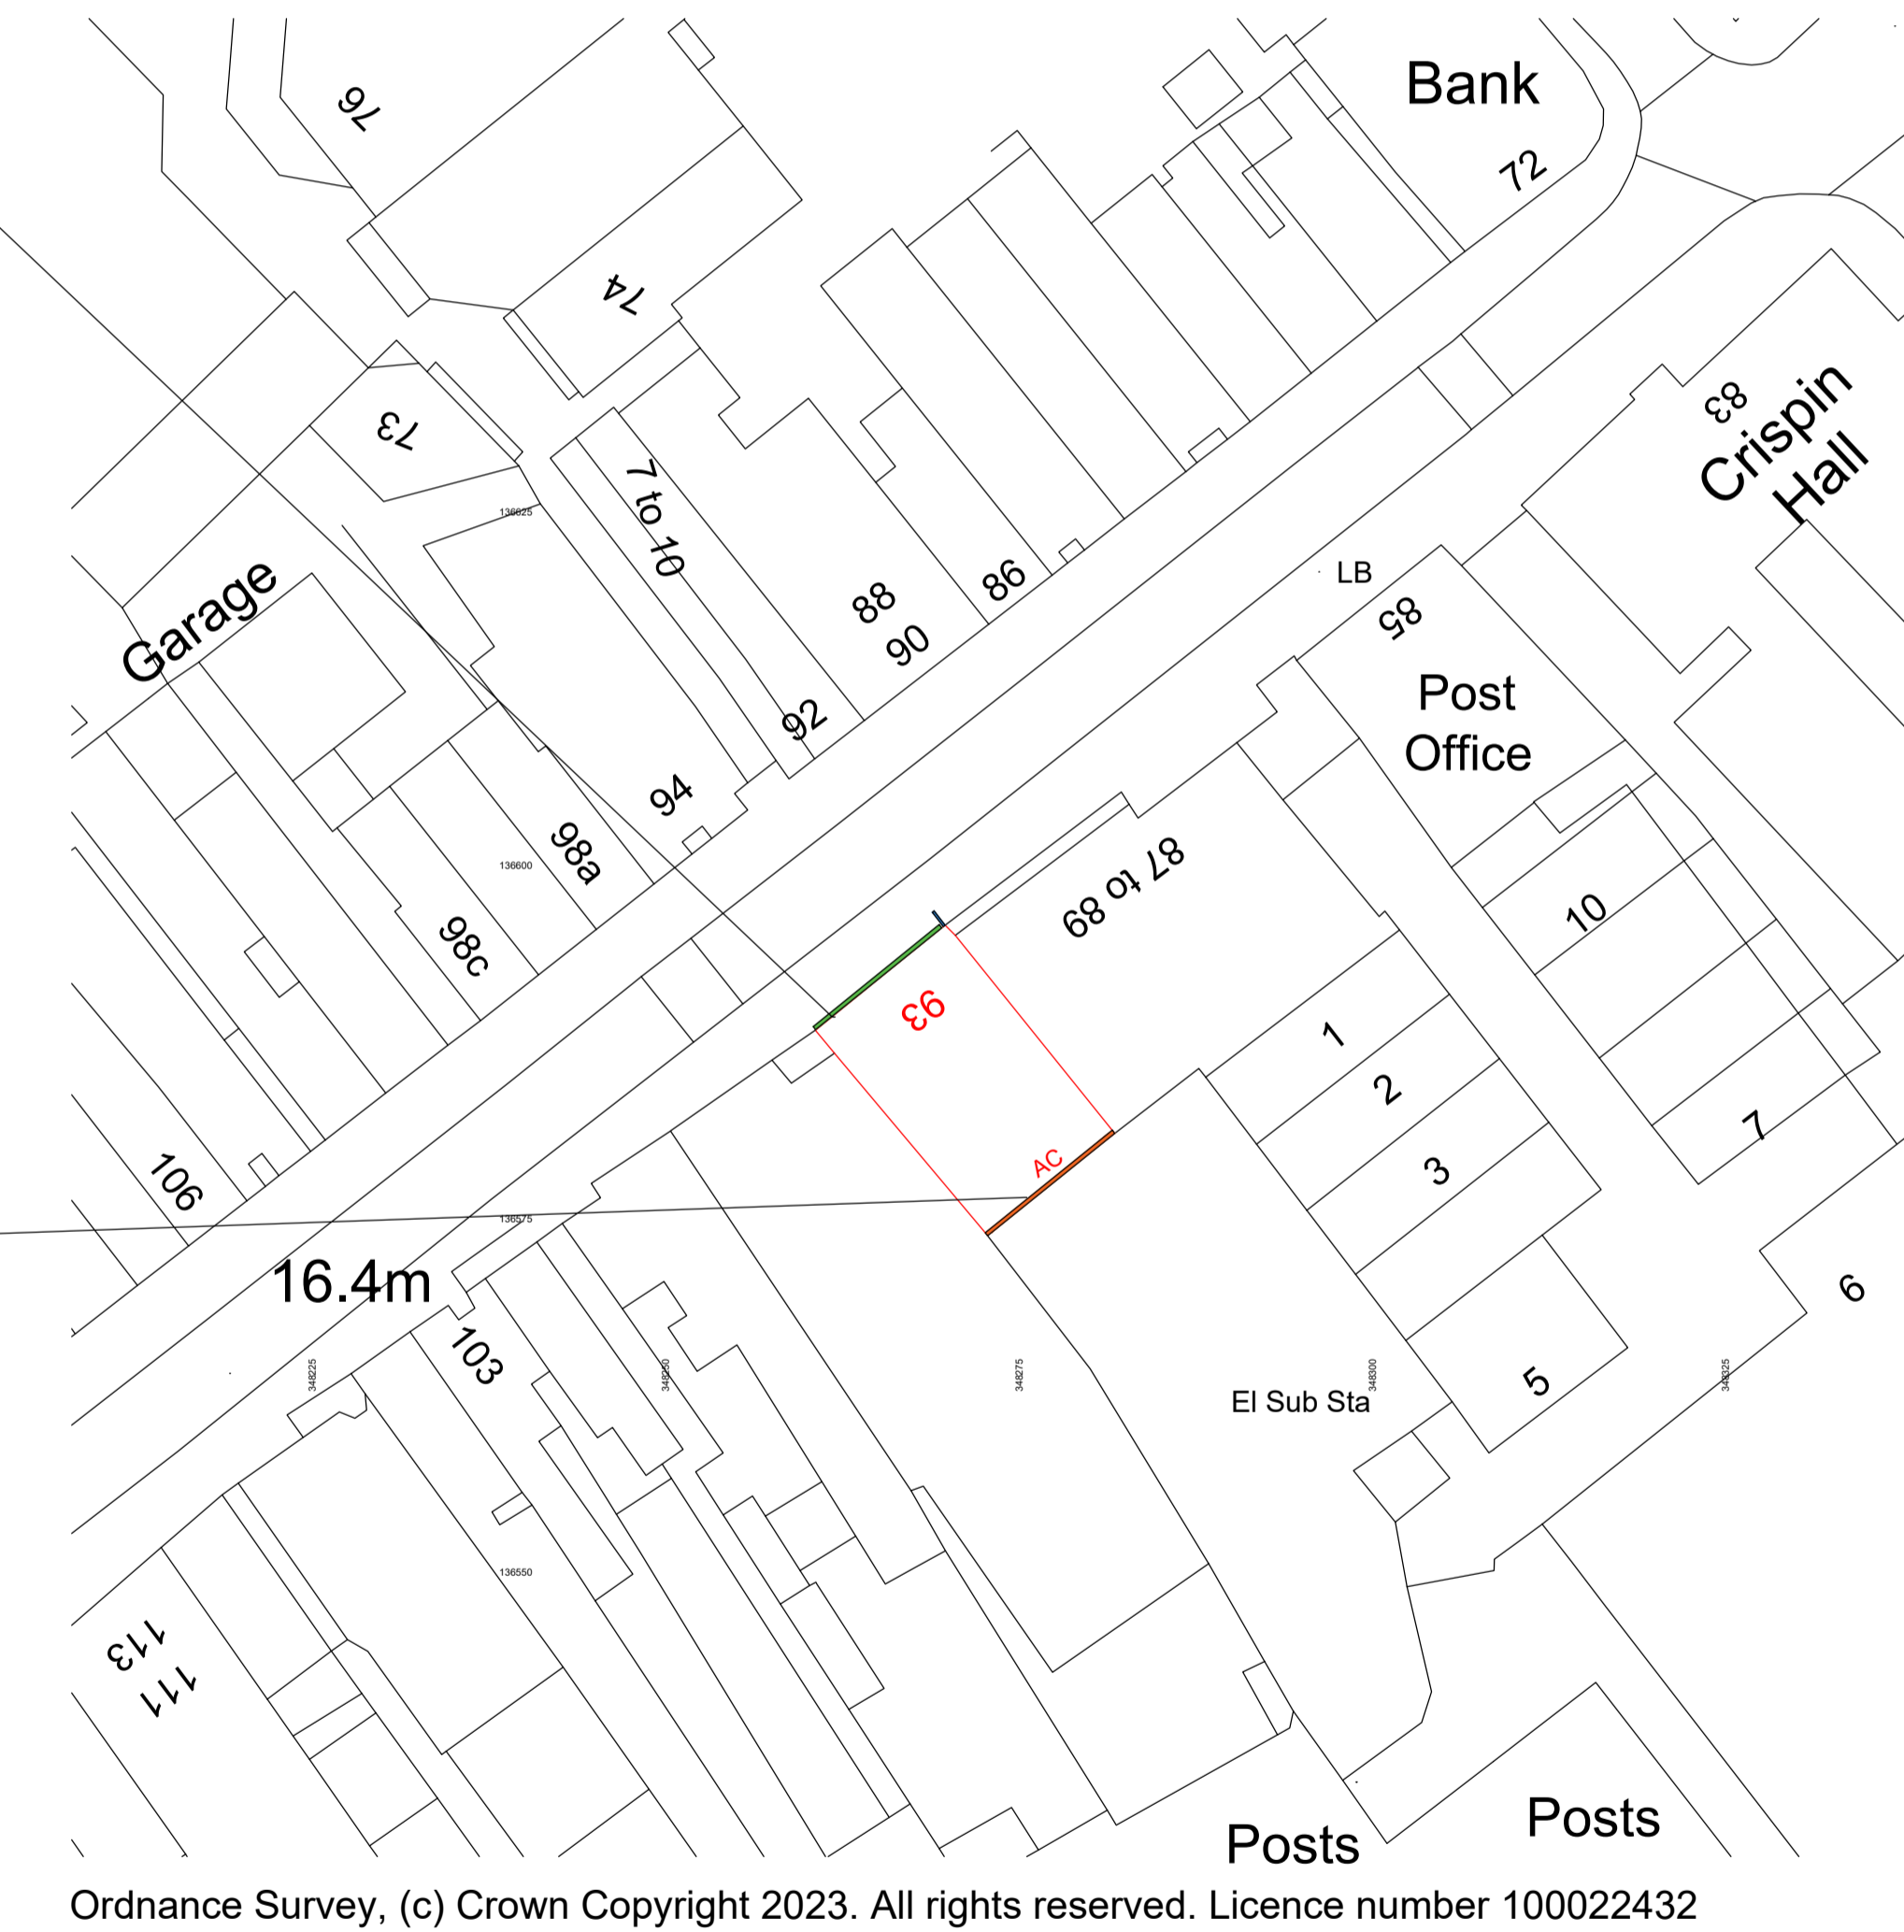

BLOCK PLAN - SCALE 1:500 @ A1



PLANNING LOCATION MAPS

Drawn By:

Amendments:

Rev	Init	Date	Description
-	-	-	-

Project:
93 High St,
Street,
BA16 0EZ

Title:
Location & Site Plan Drawings

Business Development, Tel: +44 (0)345 2020 241
 Cirrus House, Fax: +44 (0)845 2020 241
 10 Experian Way, E: jonathon.hardy@specsavers.com
 Nottingham
 NG2 1EP www.specsavers.com

Street Rebrand

Drawn By: RDS	Scale: AS SHOWN	Date: Dec 2023
Drawing Number: 557/106	Revision: -	