


**Location Plan**  
1 : 1250

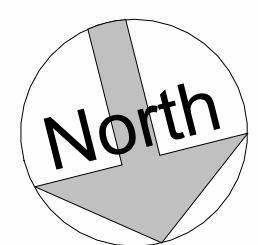

**West Elevation**  
1 : 100


**South Elevation**  
1 : 100

**East Elevation**  
1 : 100

**North Elevation**  
1 : 100



**Ground Floor Plan**  
1 : 50

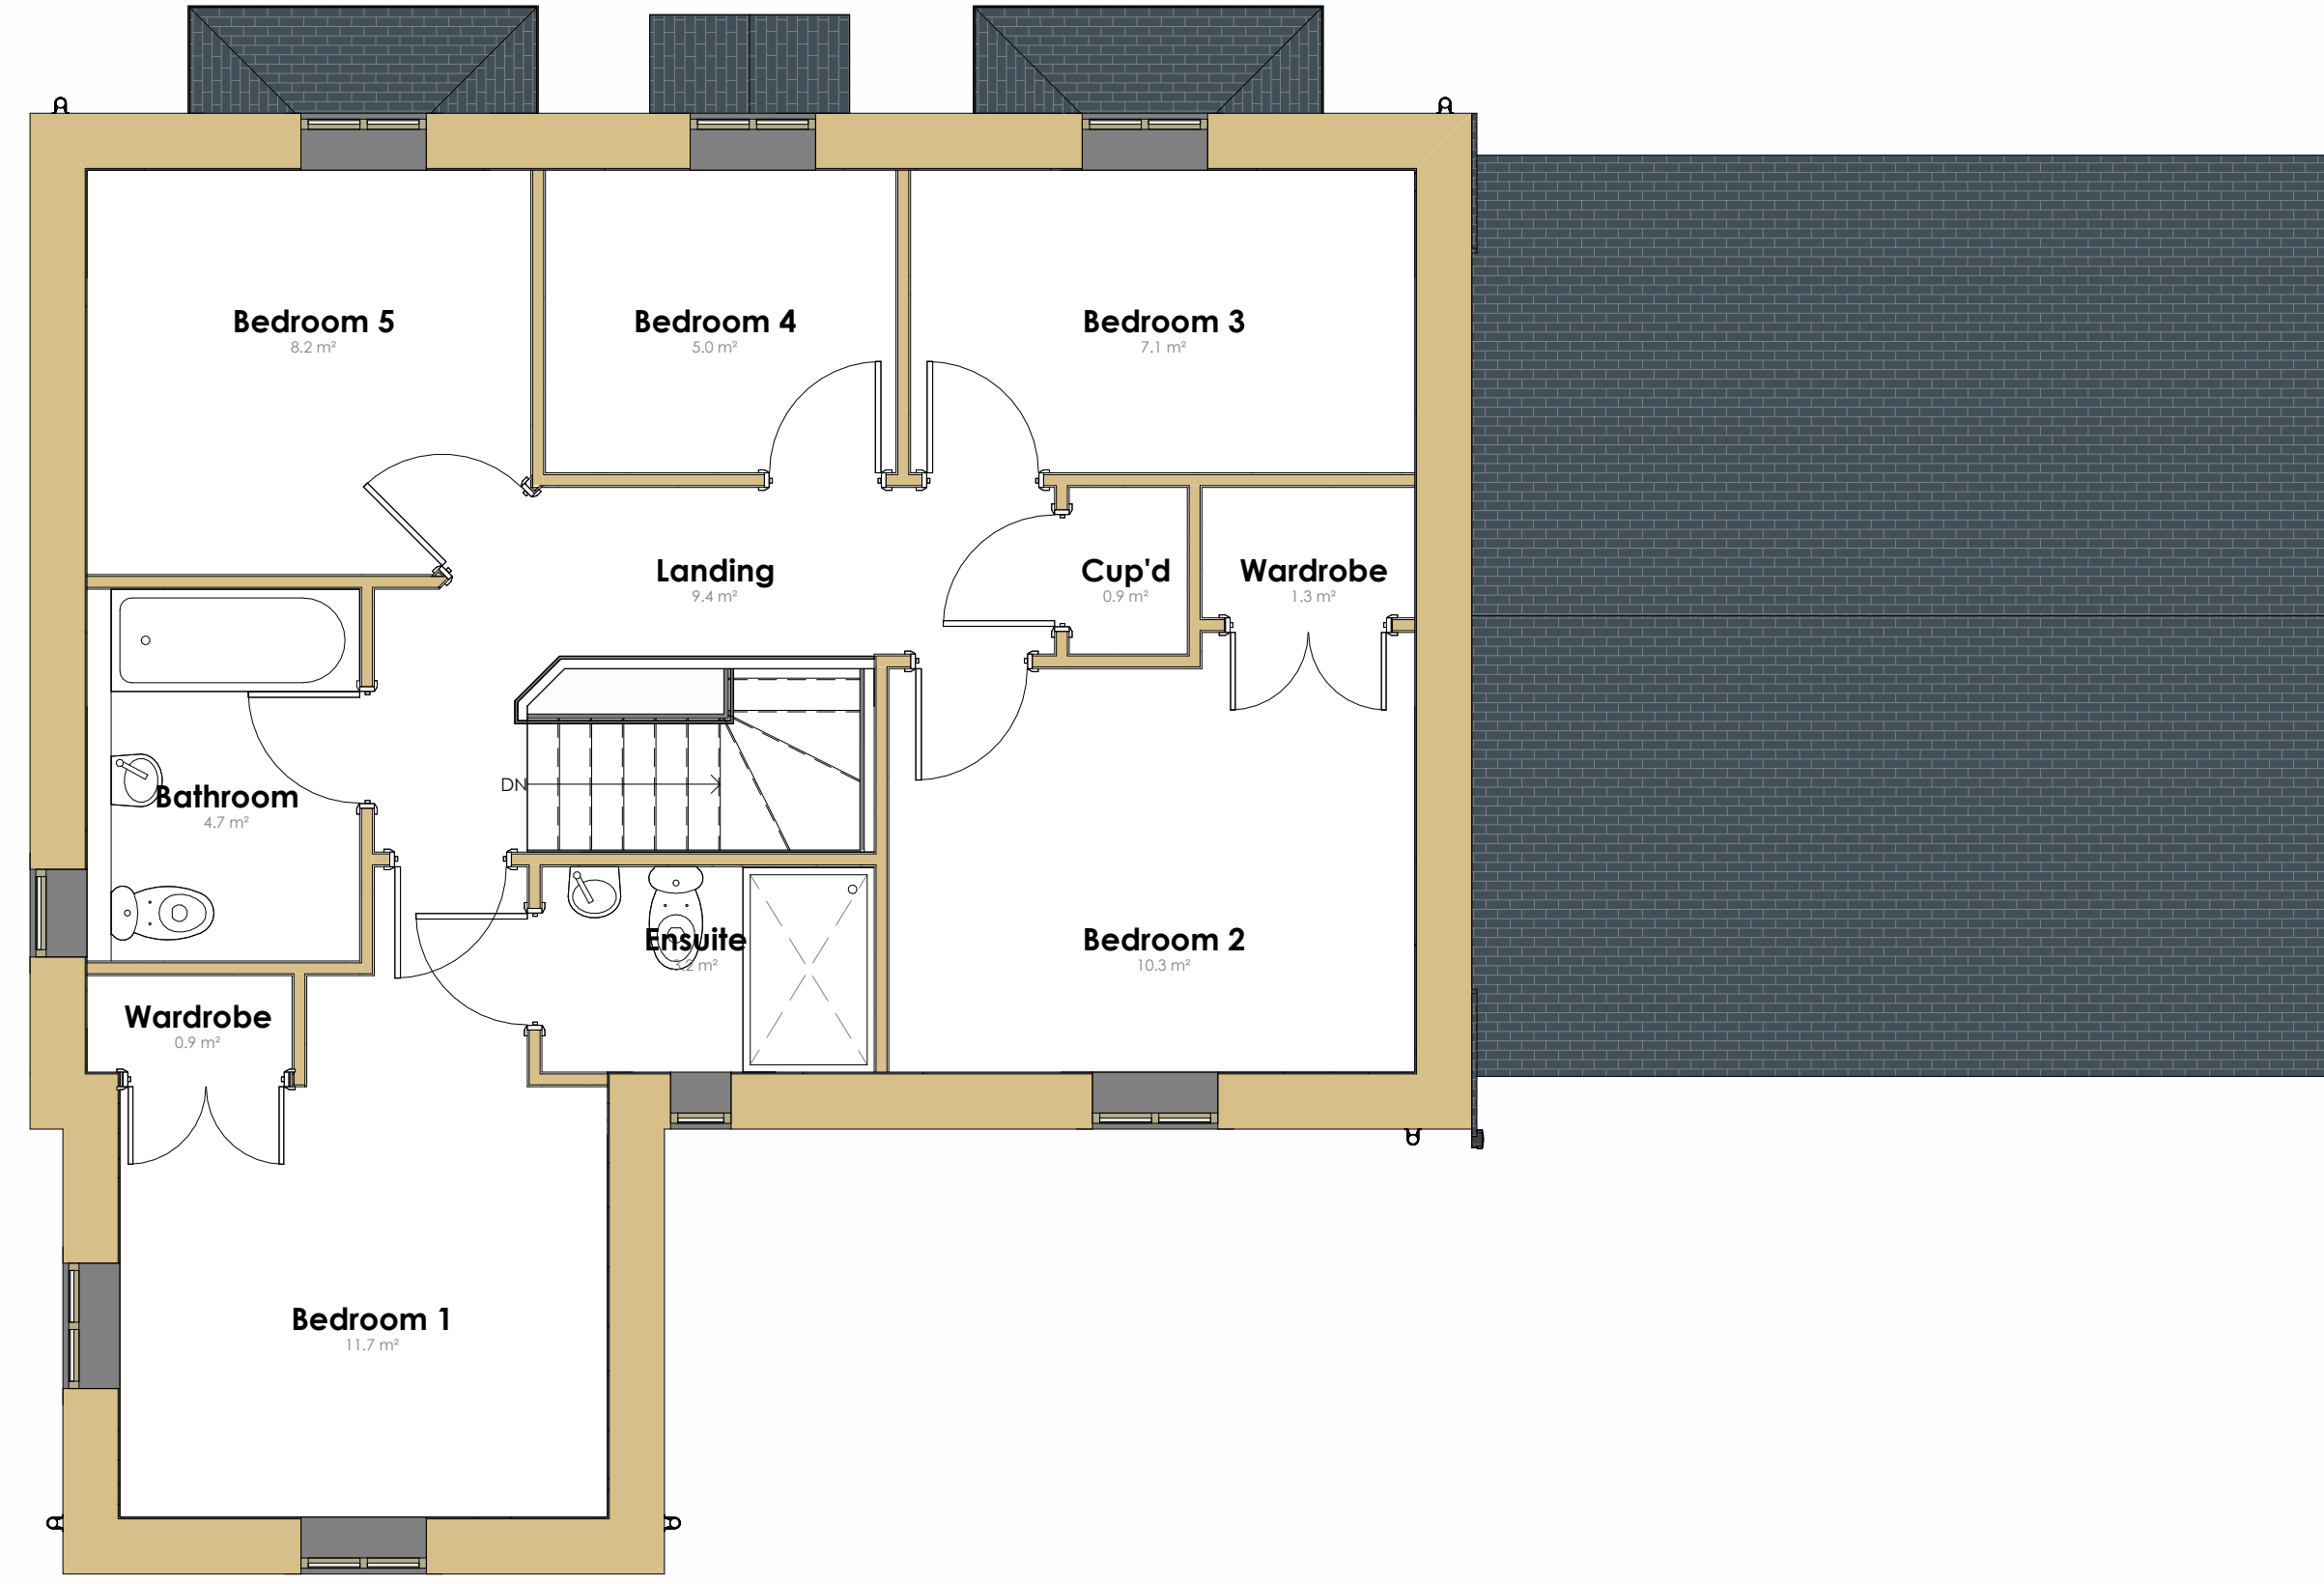

**First Floor Plan**  
1 : 50

**Client:**  
Mr L White

**Project:**  
2 Summers Way  
Moreton in Marsh  
Gloucestershire  
GL56 0GA

**Drawing:**  
Measured Survey

<b>Job Number:</b> DDC-2023-889	<b>Scale:</b> As Indicated	<b>Date:</b> Nov 2023	<b>Sheet:</b> A1
------------------------------------	-------------------------------	--------------------------	---------------------

<b>Drawing Number:</b> 001	<b>Drawn By:</b> CL	<b>Checked:</b> AJL
-------------------------------	------------------------	------------------------

001

**Units:**  
mm