

1 External Lighting
1 : 200

Lighting Fixture Schedule1

Type	Image	Description
B1		LED BOLLARD, 3000K, FINISH TBC, NON DIM
ST1		TRADITIONAL LED LANTERN, 3000K, NON DIM, NARROW PATH OPTIC
ST2		TRADITIONAL LED LANTERN, 3000K, NON DIM, ROTO SYMMETRICAL OPTIC
W1		LED WALL LIGHT, 300K, NON DIM, FINISH TBC


General Use illuminance Results 2

Calculation Points Name	AVERAGE COMPLIANCE: MAX 5% BELOW, MAX 30% ABOVE			UNIFORMITY COMPLIANCE: UO= TARGET MAINT FACTOR 0.8 REFLECTANCES C:70% W:30% F:20%			OTHER				
	AVG	TARGET	OK	UO	TARGET	OK	Min	Max	WP	CH	Wm2
00 DRIVE	15.7 lx	15 lx	✓	0.32	0.25	✓	58 lx	5 lx	0.05 m		
WALKWAY	198.2 lx			0.03			1677 lx	6 lx	0.10 m		
WALKWAY	136.5 lx			0.05			1363 lx	7 lx	0.10 m		
WALKWAY	116.1 lx			0.03			1352 lx	4 lx	0.10 m		
WALKWAY	73.2 lx			0.04			1110 lx	3 lx	0.10 m		
WALKWAY	73.8 lx			0.04			1156 lx	3 lx	0.10 m		
WALKWAY	66.2 lx			0.03			1268 lx	2 lx	0.10 m		
OL NORTH	0.3 lx			0.33			1 lx	0 lx	0.00 m		
OL WEST	0.4 lx			0.29			1 lx	0 lx	0.00 m		
OL SOUTH	0.5 lx			0.25			2 lx	0 lx	0.00 m		
OL EAST	0.3 lx			0.00			1 lx	0 lx	0.00 m		
SKY GLOW	0.7 lx			0.17			2 lx	0 lx	0.00 m		



Follow link for Video Walkthrough

<https://park-electrical.vids.io/videos/d390d1b7191ce9cf5a/sy1223-04-hallgarth-manoir-vid-1>

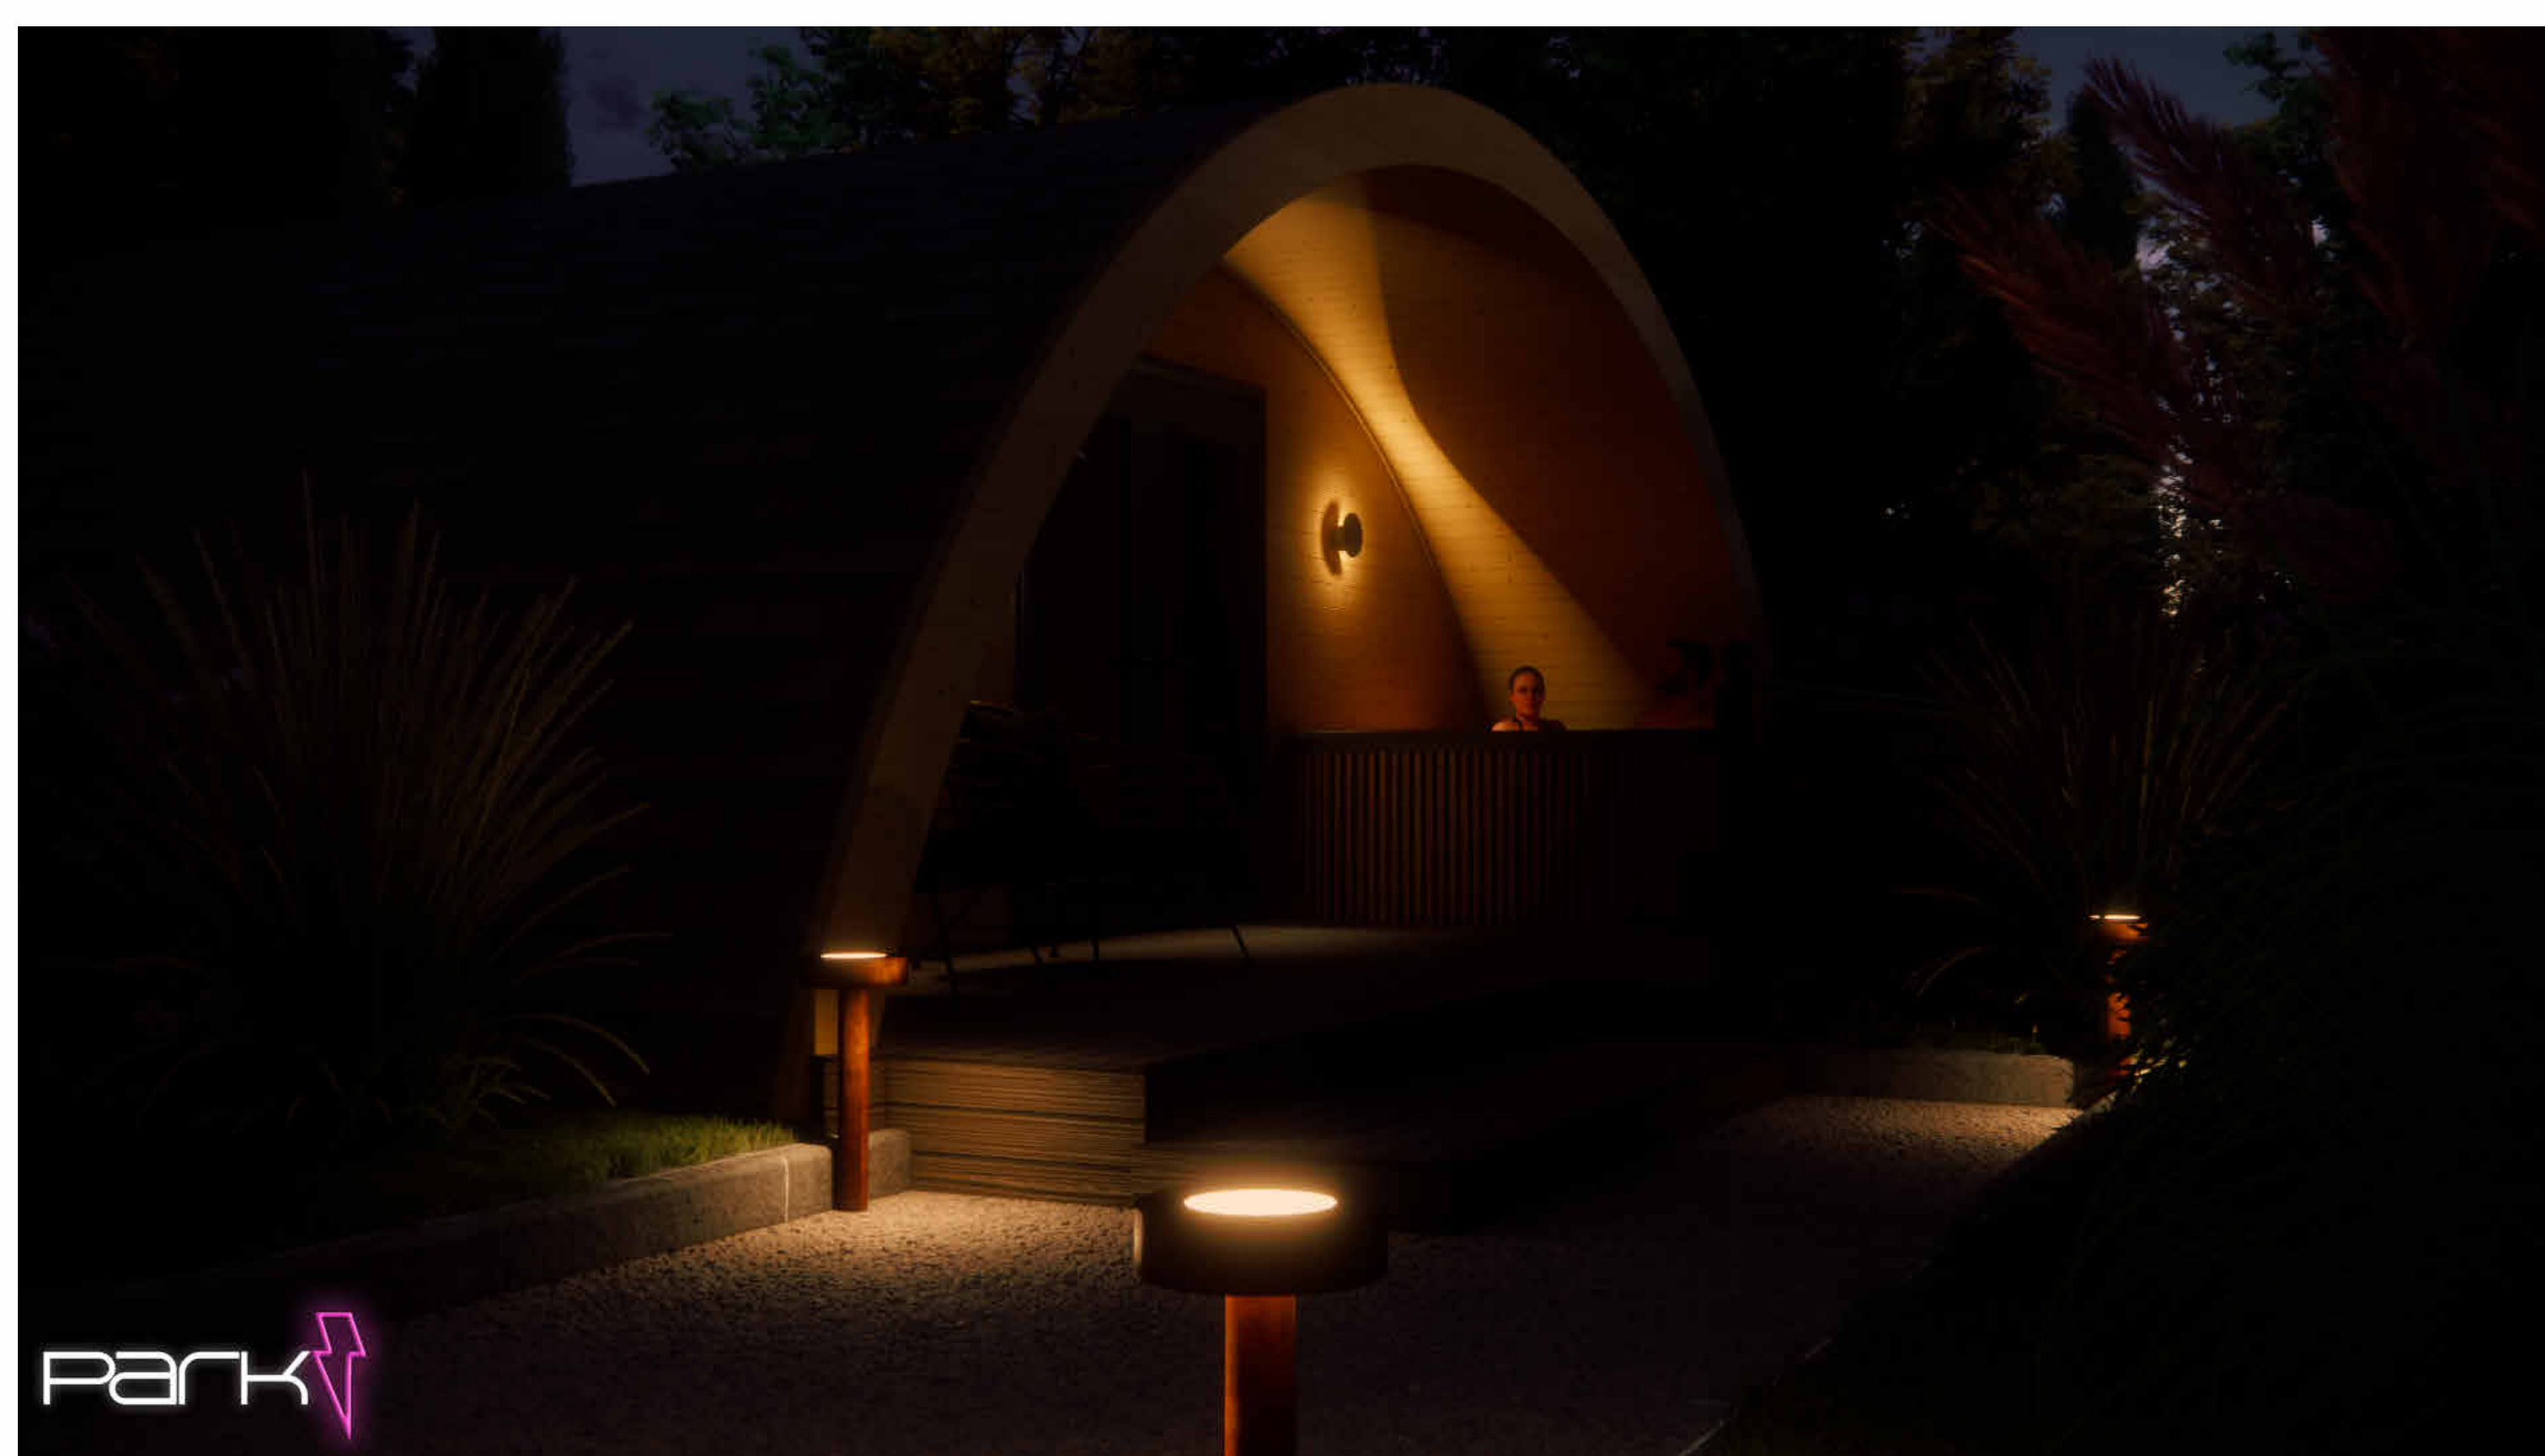

PARK

NUMBER
SY1223-04

PROJECT
Hallgarth Manor

TITLE
Lighting Layout

CLIENT
Owner

Rev	Description	Date

DO NOT SCALE

SCALE (@ A0) DRAWN BY CHECKED BY DATE
As indicated JW Checker 15/12/23

DRAWING NUMBER
L101

REV