
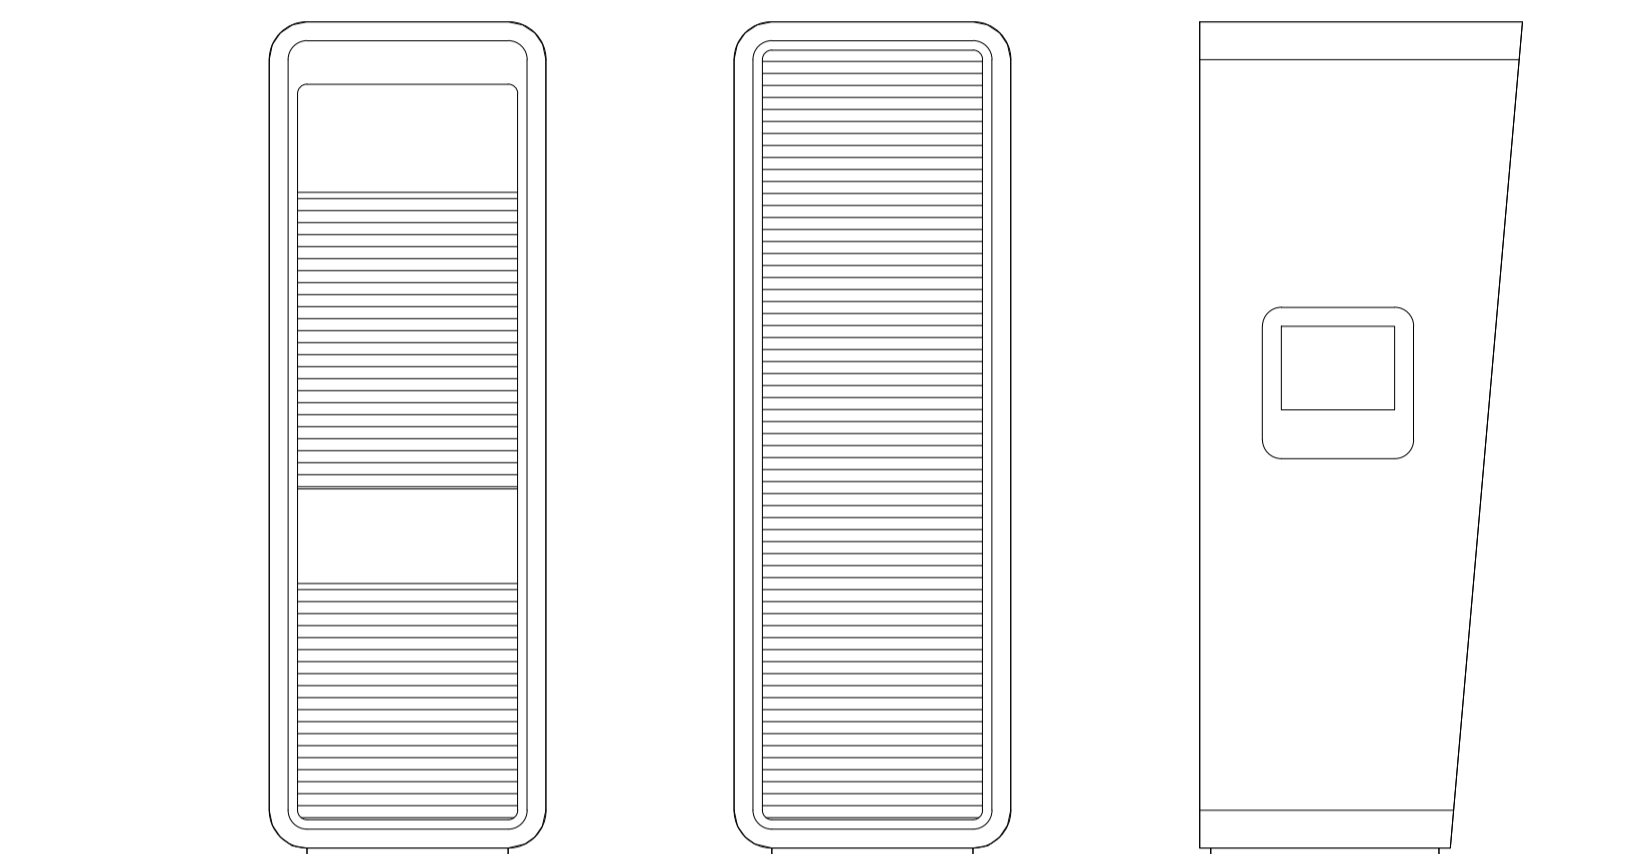
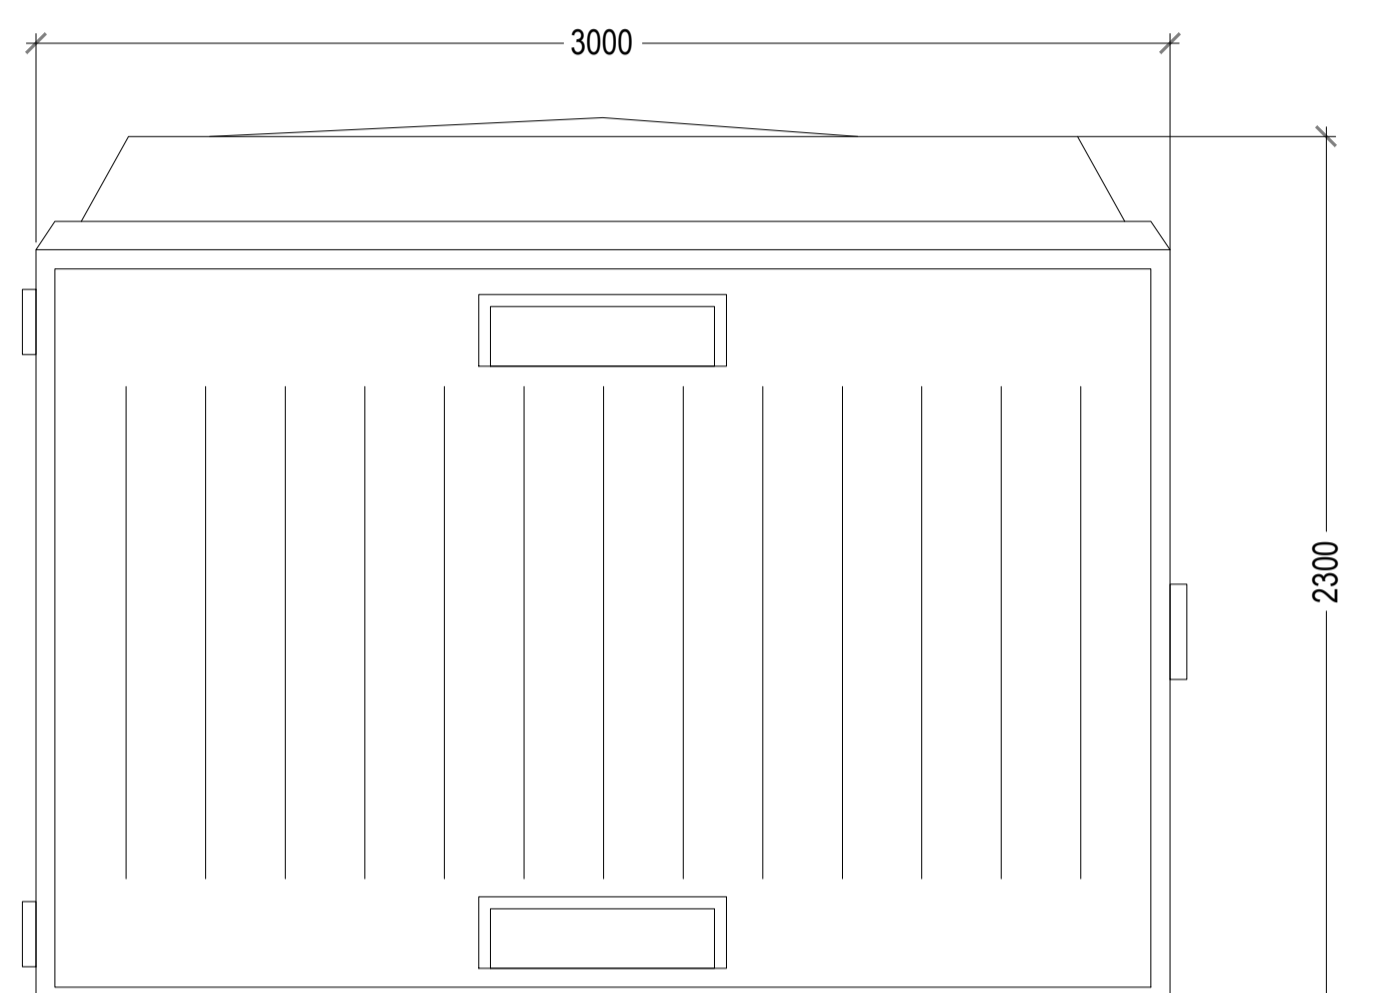


GENERAL NOTES

THIS DRAWING HAS BEEN PREPARED FOR PLANNING PURPOSES ONLY.

THIS DRAWING IS TO BE READ IN CONJUNCTION WITH THE FOLLOWING:

- BRACKNELL 10018951- PLG-00- 23 SITE LOCATION PLAN
- BRACKNELL 10018951- PLG-01- 23 BLOCK PLAN
- BRACKNELL 10018951- PLG-02- 23 EXISTING SITE LAYOUT
- BRACKNELL 10018951- PLG-03- 23 PROPOSED SITE LAYOUT
- BRACKNELL 10018951- PLG-04- 23 TRACKING PLAN
- BRACKNELL 10018951- PLG-05- 23 EV EQUIPMENT
- BRACKNELL 10018951- PLG-06- 23 EV CANOPY DETAIL
- BRACKNELL 10018951- PLG-07- 23 EXISTING SITE ELEVATIONS
- BRACKNELL 10018951- PLG-08- 23 PROPOSED SITE ELEVATIONS

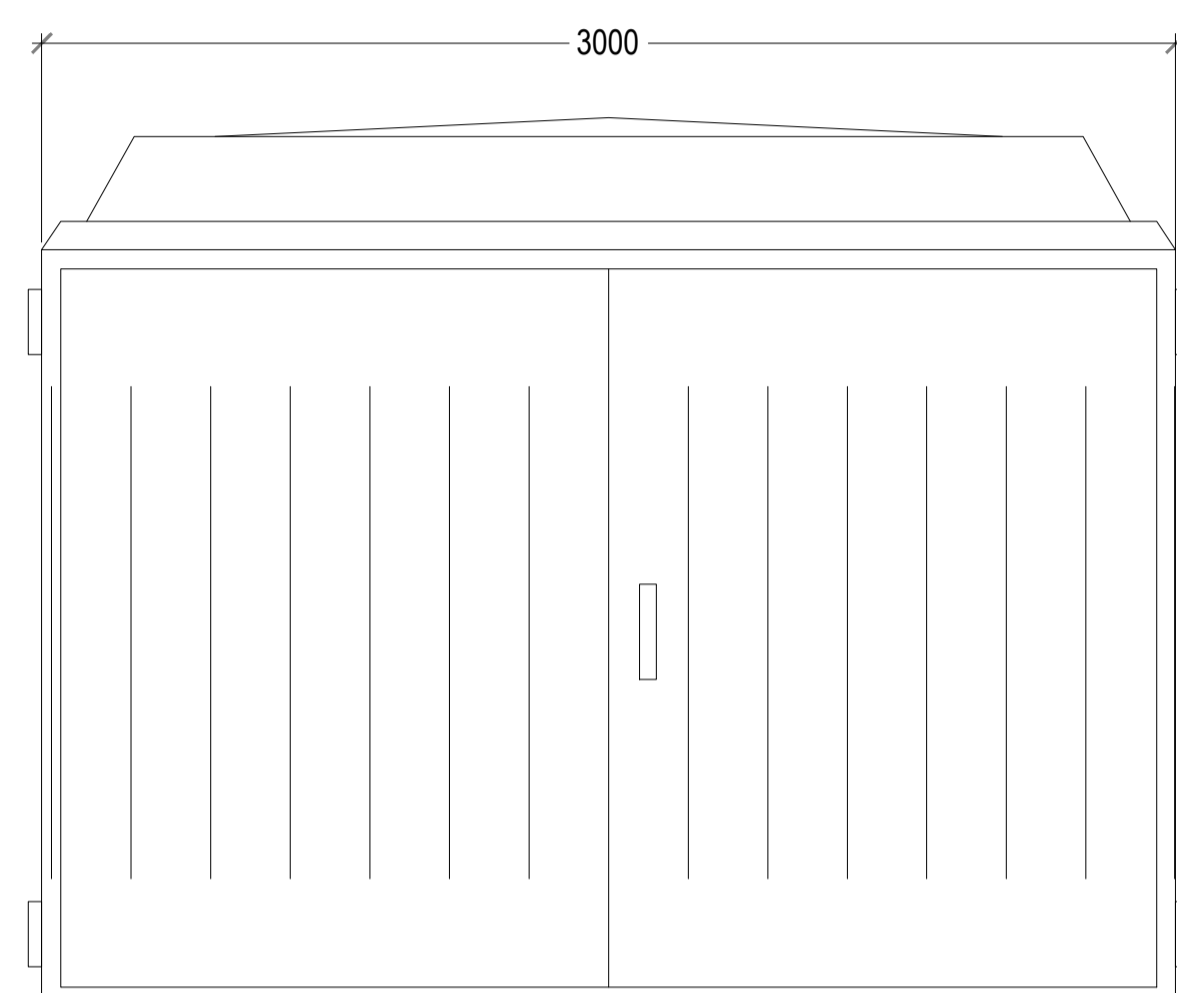

SUB-STATION ELEVATIONS (SIZE TO BE CONFIRMED)

(External finish Green)

Scale 1:20

FRONT ELEVATION


BACK ELEVATION

SIDE ELEVATION

CHARGING UNIT

Scale 1:20

SUPERSEDED

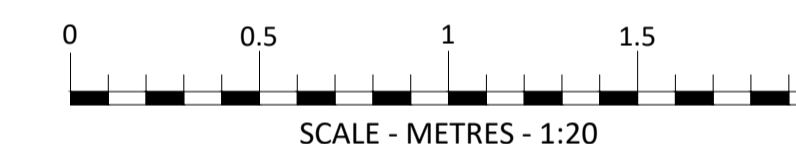

ALPITRONIC HYC 300 CHARGERS

PROJECT MANAGERS :



DESIGNERS :




MBH Design Studio Ltd.
Rosemount House, Rosemount Avenue, West Byfleet, Surrey, KT14 6LB
www.mbhtd.com t: 01932 352 727 f: 01932 351 545

PHASE: **PLANNING**

REV	DATE	BY

PROJECT: SHELL BRACKNELL
BAGSHOT ROAD, BRACKNELL
BERKSHIRE, RG12 9SE





TITLE: EV EQUIPMENT

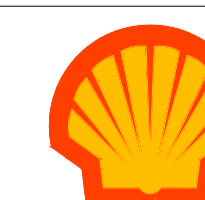

SHELL UK OIL PRODUCTS LTD.
SHELL CENTRE, YORK ROAD,
LONDON, SE1 7NA
UNITED KINGDOM

DRAWN BY: RS/WJS SCALE: 1:20@A1
DATE: 24.10.2023 PLOT DATE: 09.11.2023
CAD FILE: M:\ARTELIA\EX-COTEBA\M\ARTELIA\EX-COTEBA\SHL114271\Bracknell

 DWG No: 10018951 PLG-05 23

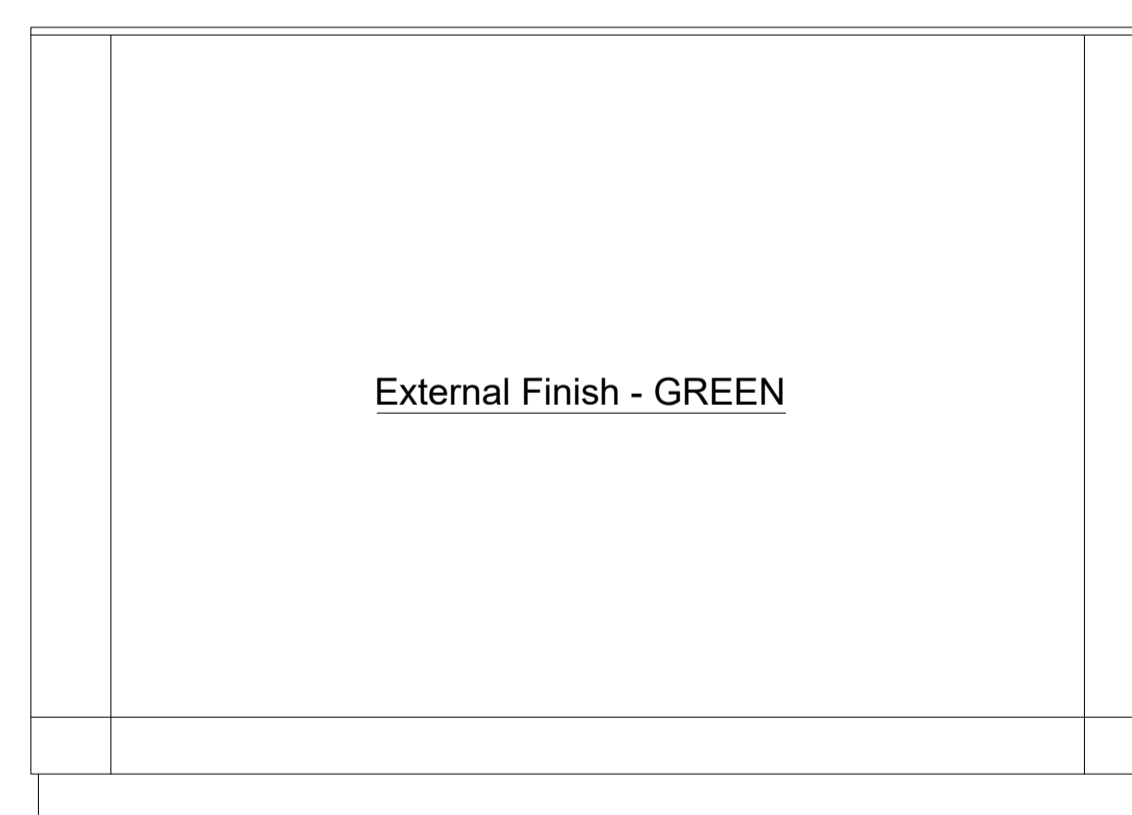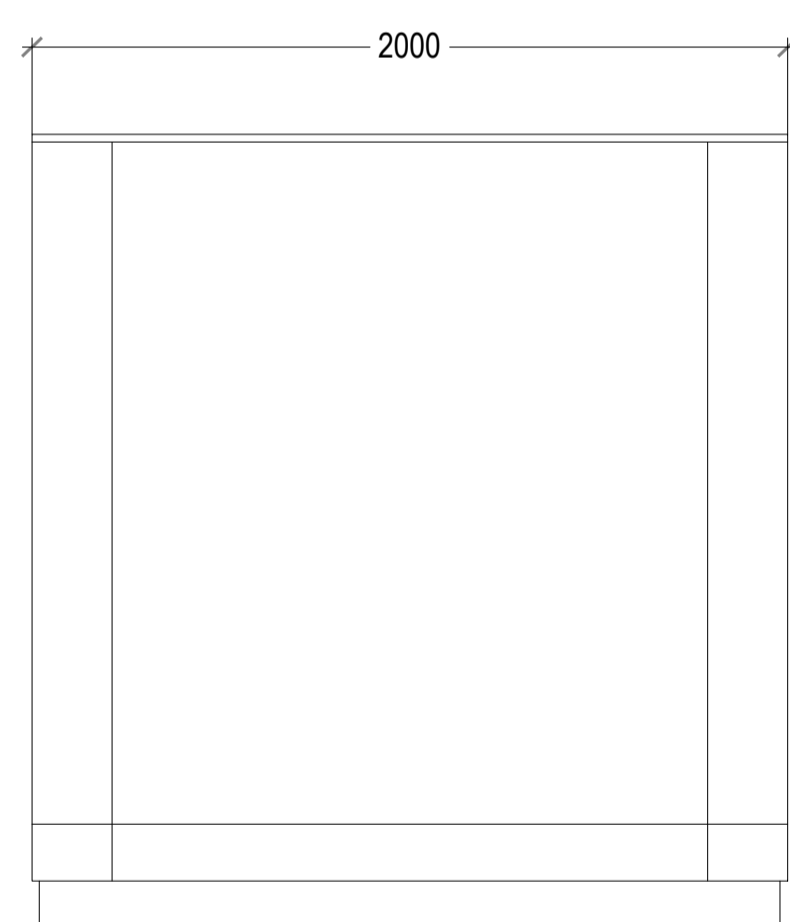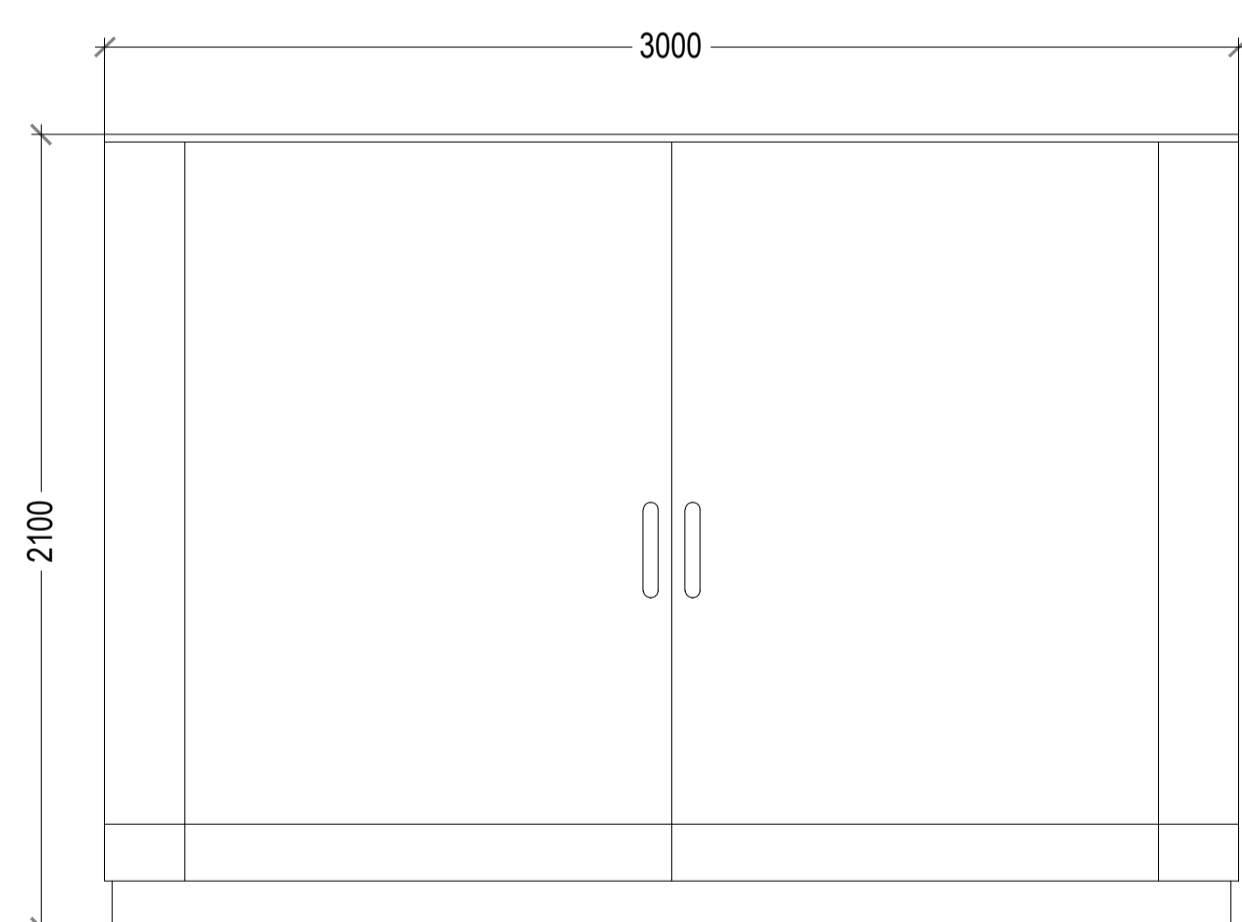

Front Elevation

Side Elevation

Rear Elevation

Side Elevation

TYPICAL MAINS GRP CABINET ELEVATIONS

Scale 1:20