
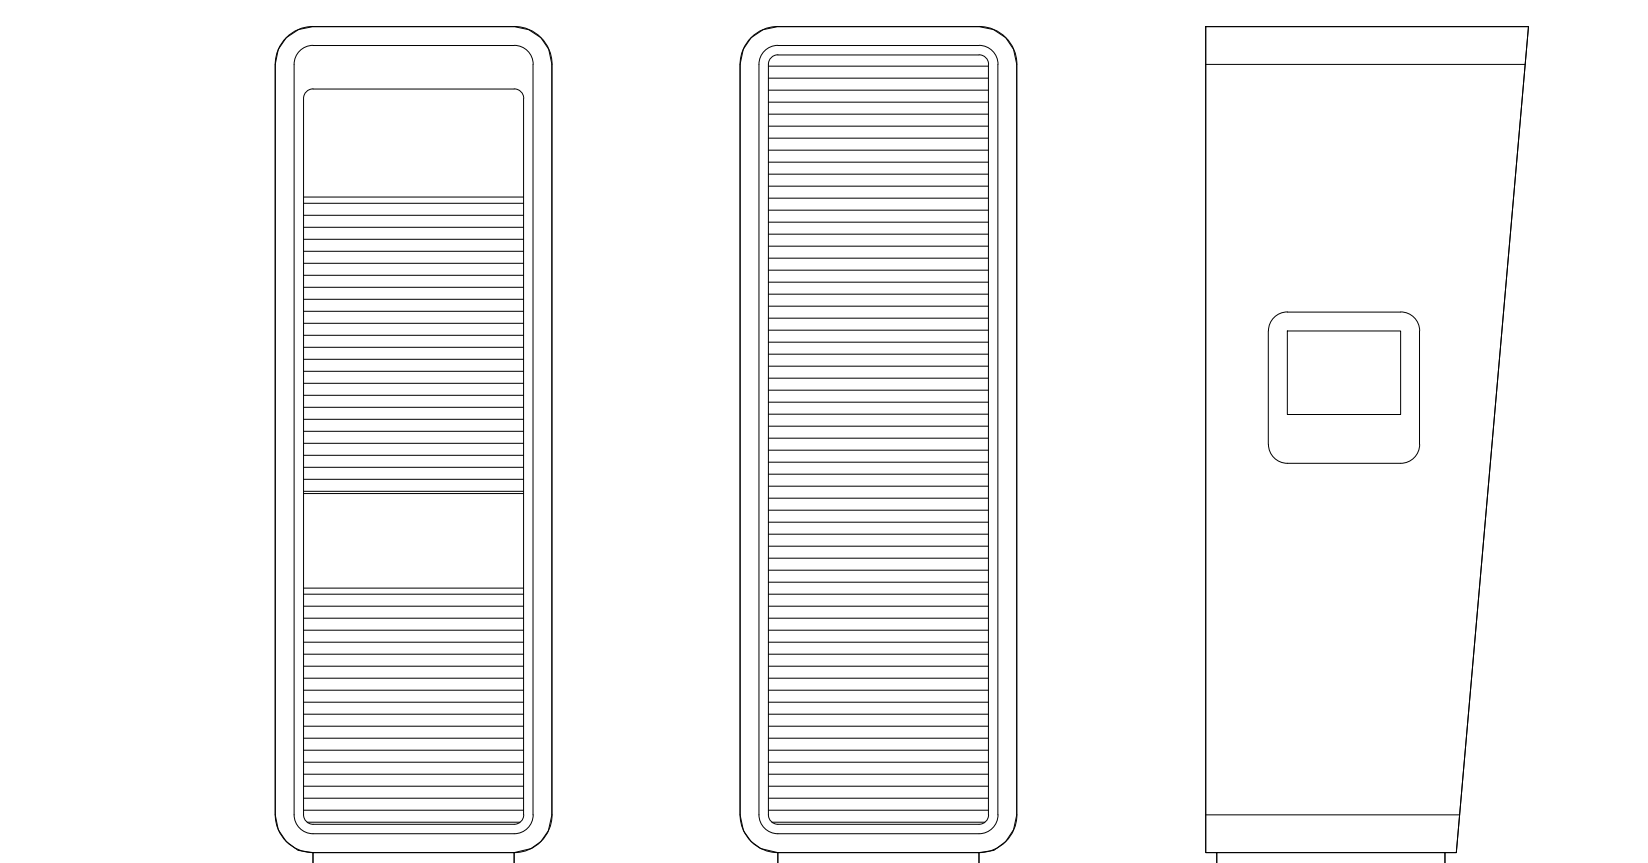
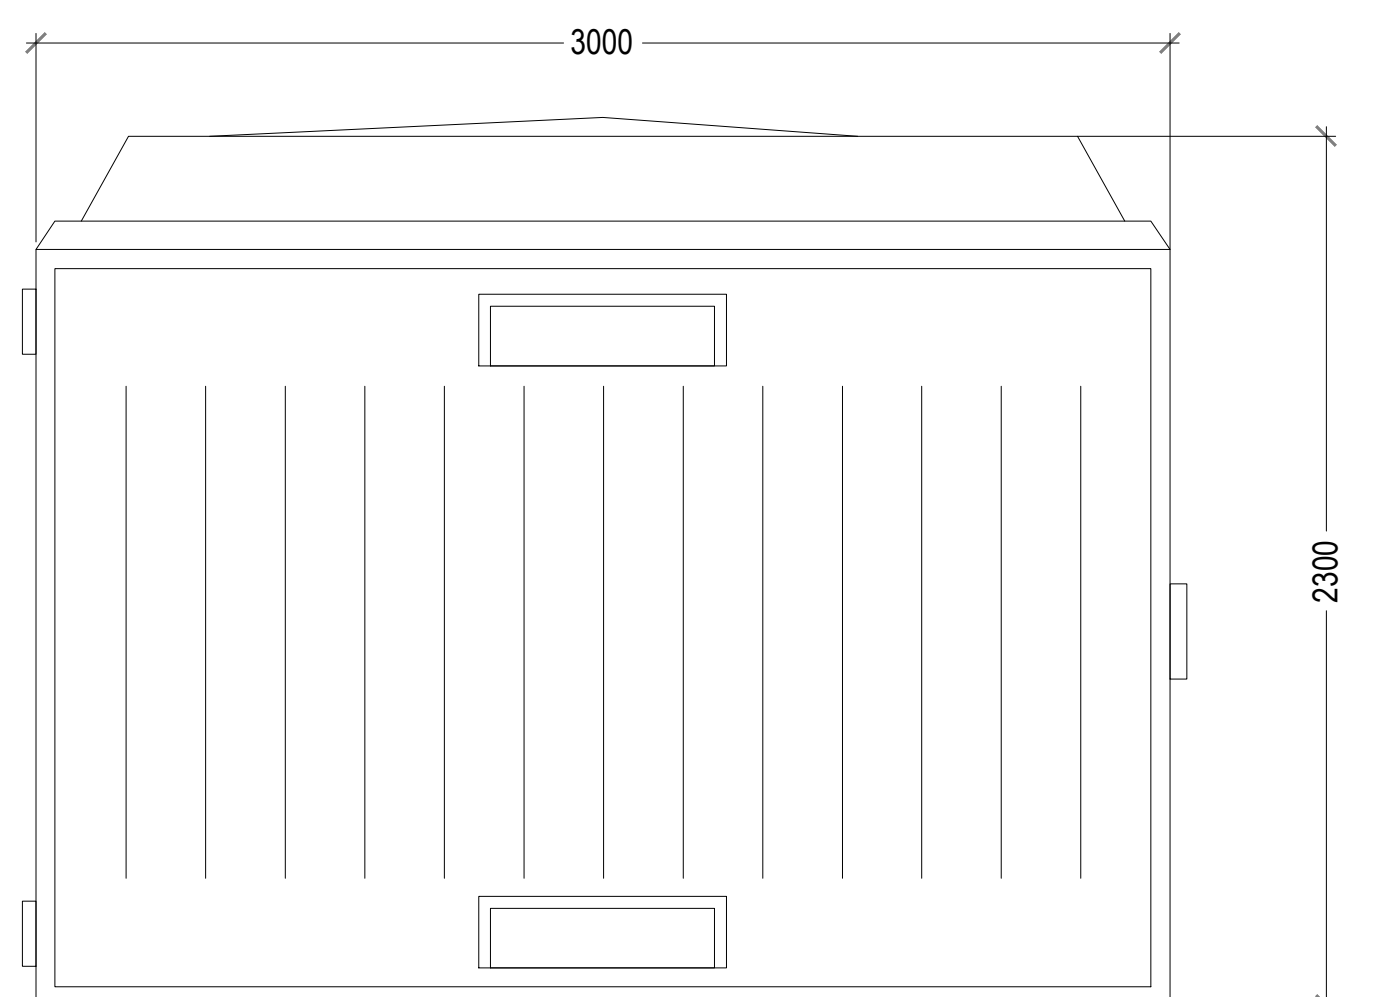


**GENERAL NOTES**

THIS DRAWING HAS BEEN PREPARED FOR PLANNING PURPOSES ONLY.





THIS DRAWING IS TO BE READ IN CONJUNCTION WITH THE FOLLOWING:

- BRACKNELL 10018951- PLG-00- 23 SITE LOCATION PLAN
- BRACKNELL 10018951- PLG-01- 23 BLOCK PLAN
- BRACKNELL 10018951- PLG-02- 23 EXISTING SITE LAYOUT
- BRACKNELL 10018951- PLG-03- 23 PROPOSED SITE LAYOUT
- BRACKNELL 10018951- PLG-04- 23 TRACKING PLAN
- BRACKNELL 10018951- PLG-05- 23 EV EQUIPMENT
- BRACKNELL 10018951- PLG-06- 23 EV CANOPY DETAIL
- BRACKNELL 10018951- PLG-07- 23 EXISTING SITE ELEVATIONS
- BRACKNELL 10018951- PLG-08- 23 PROPOSED SITE ELEVATIONS

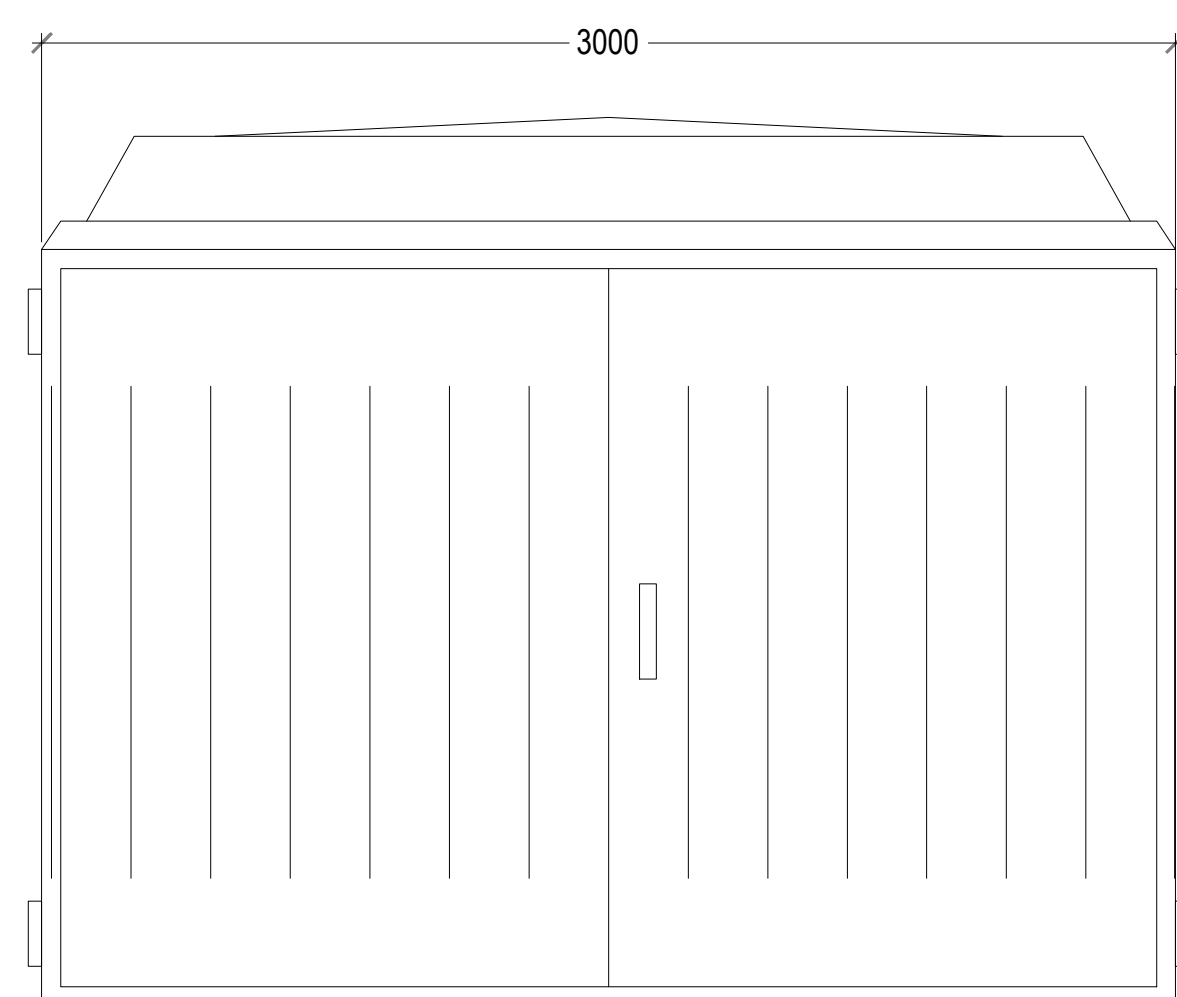

**SUB-STATION ELEVATIONS (SIZE TO BE CONFIRMED)**  
 (External finish Green)  
 Scale 1:20

**FRONT ELEVATION    BACK ELEVATION    SIDE ELEVATION**  
**CHARGING UNIT**  
 Scale 1:20

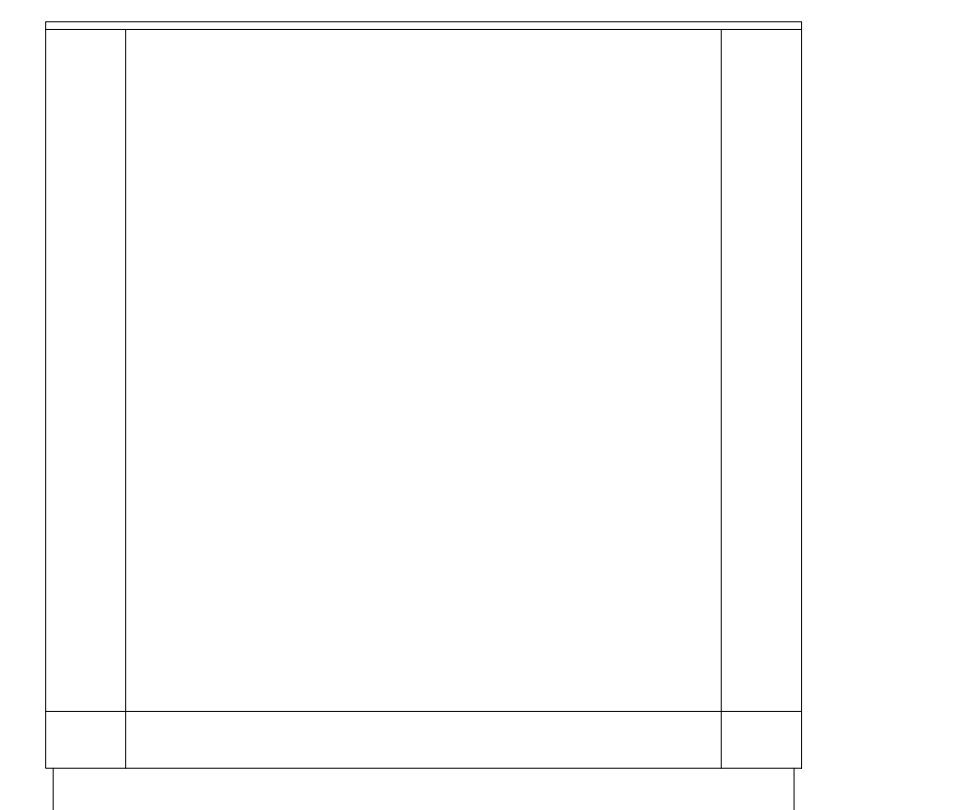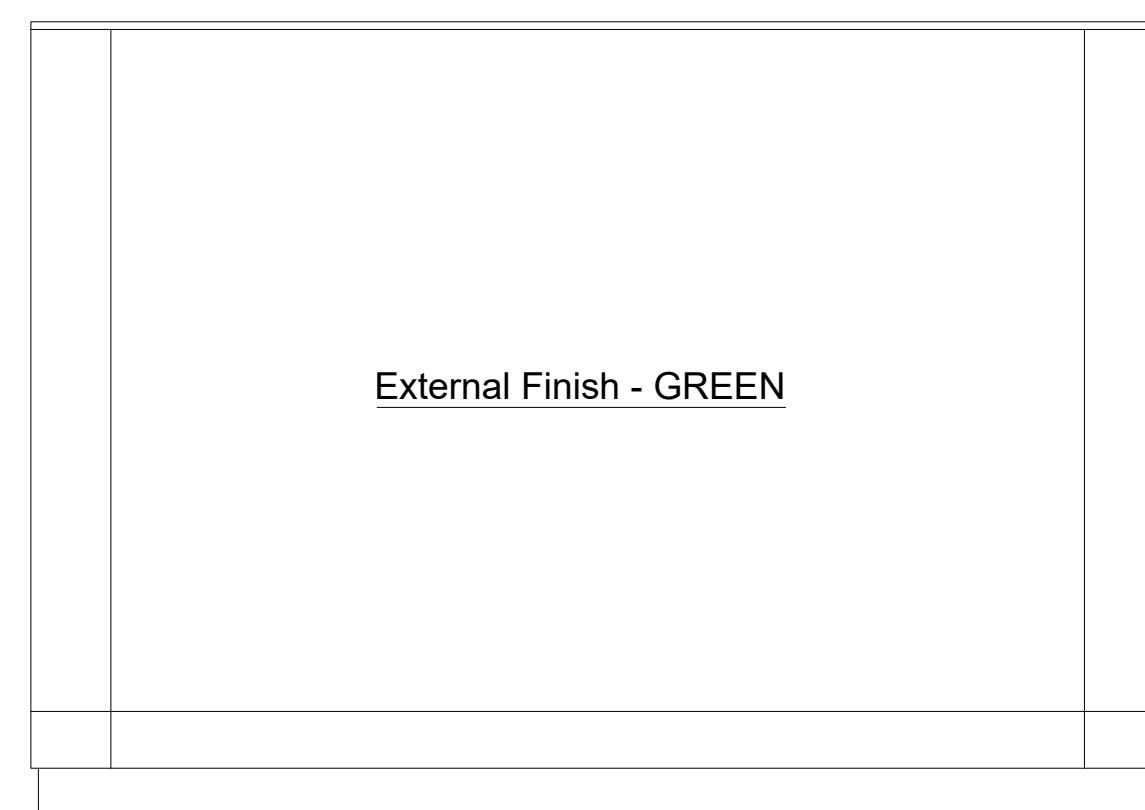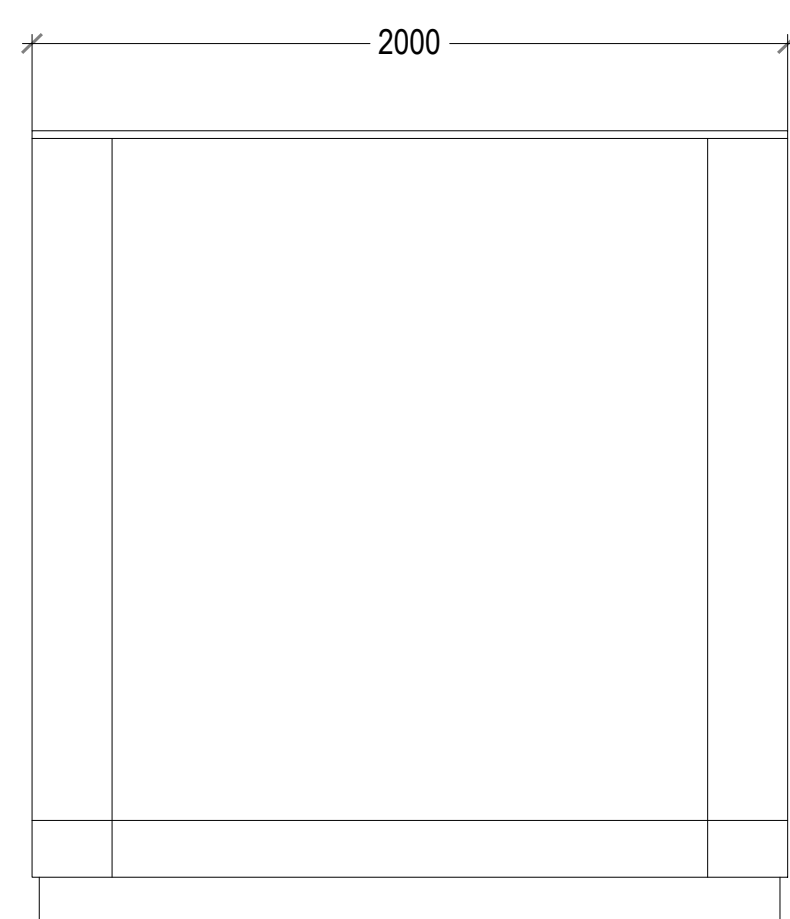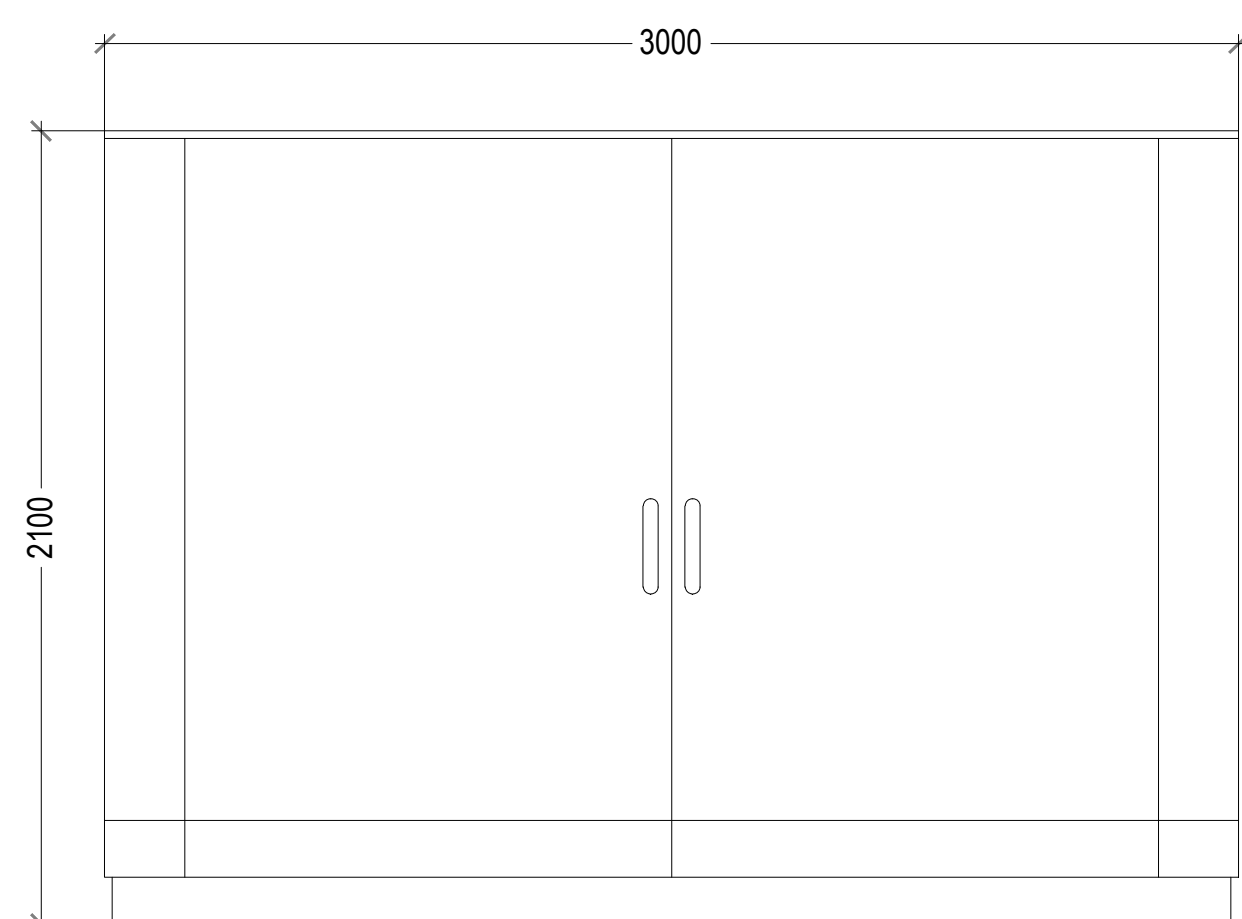


**Front Elevation**

**Side Elevation**

**Rear Elevation**

**Side Elevation**

**TYPICAL MAINS GRP CABINET ELEVATIONS**  
 Scale 1:20

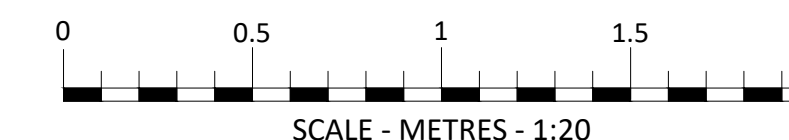

**ALPITRONIC HYC 300 CHARGERS**

PROJECT MANAGERS :



DESIGNERS :




MBH Design Studio Ltd.  
 Rosemount House, Rosemount Avenue, West Byfleet, Surrey, KT14 6LB  
 www.mbhstd.com    t: 01932 352 727    f: 01932 351 545

PHASE : **PLANNING**

REV	DATE	BY

PROJECT : SHELL BRACKNELL  
 BAGSHOT ROAD, BRACKNELL  
 BERKSHIRE, RG12 9SE

TITLE : EV EQUIPMENT

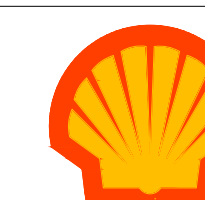

SHELL UK OIL PRODUCTS LTD.  
 SHELL CENTRE, YORK ROAD,  
 LONDON, SE1 7NA  
 UNITED KINGDOM

DRAWN BY : RS/WJS    SCALE : 1:20@A1  
 DATE : 24.10.2023    PLOT DATE : 09.11.2023  
 CAD FILE : M:\ARTELIA\EX-COTEBA\M\ARTELIA\EX-COTEBA\SHELL\14271\Bracknell

DWG No : 10018951    PLG-05    23